



General Notes :

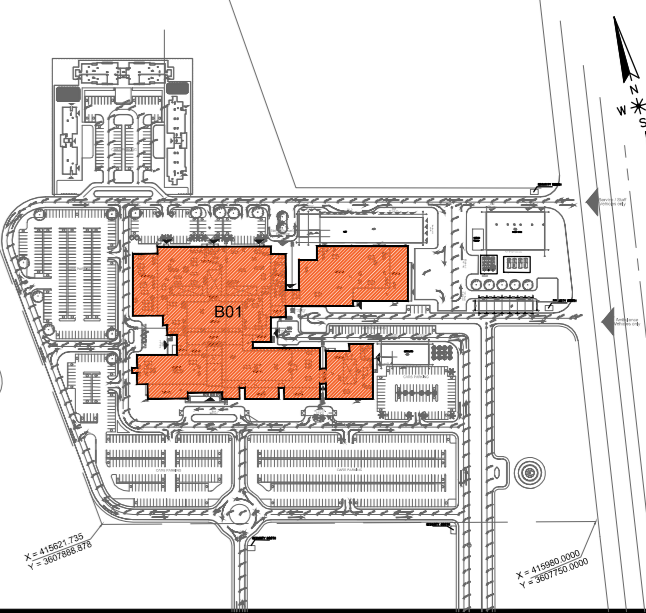

MINISTRY OF HIGHER EDUCATION
AND SCIENTIFIC RESEARCH
University Of Karbala

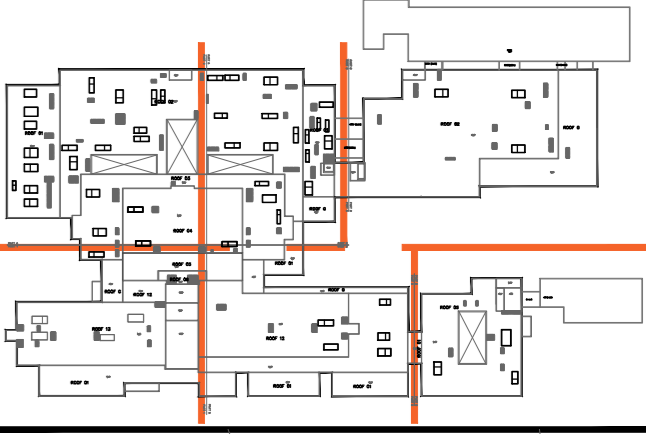

PROJECT MANAGEMENT CONSULTANT
AM TECH

MAIN CONTRACTOR
FOURTH DIMENSION
Consulting Engineering & Construction
CIB.C

PRINCIPAL ENGINEERING CONSULTANT
ARABTECH JARDANEH

CONSULTING HEALTH PLANNERS
HDP healthcare designers
and project managers

CONSULTING INTERNATIONAL ARCHITECTS
LEO A DALY
PLANNING ARCHITECTURE ENGINEERING INTERIORS

THIS DRAWING IS THE
COPYRIGHT OF ARABTECH
JARDANEH ENGINEERS &
ARCHITECTS AND MUST NOT BE
REPRODUCED, COPIED OR USED
WITHOUT THE CONSULTANTS
AUTHORIZATION

REV.	DESCRIPTION	APPRO. BY	DATE

DRAWN BY: E.D. DESIGNED BY: H.O.M.S.H.
CHECKED BY: M.K.H. APPROVED BY: F.J.
QC REVIEW BY: B.M. DWG ISSUE DATE: 26.10.2014


PROJECT:
**KARBALA 600 BED TEACHING
UNIVERSITY HOSPITAL, IRAQ**

CONCEPT DESIGN STAGE
PRELIMINARY DESIGN STAGE
DESIGN DEVELOPMENT STAGE
CONSTRUCTION DRAWINGS STAGE



DRAWING TITLE:

**GROUND FLOOR PLAN
LIGHTING LAYOUT
OVERALL**

A01 01586 DWG KUH-EL-101 BLOCK B01
1:250 01 of 01 REV. RO

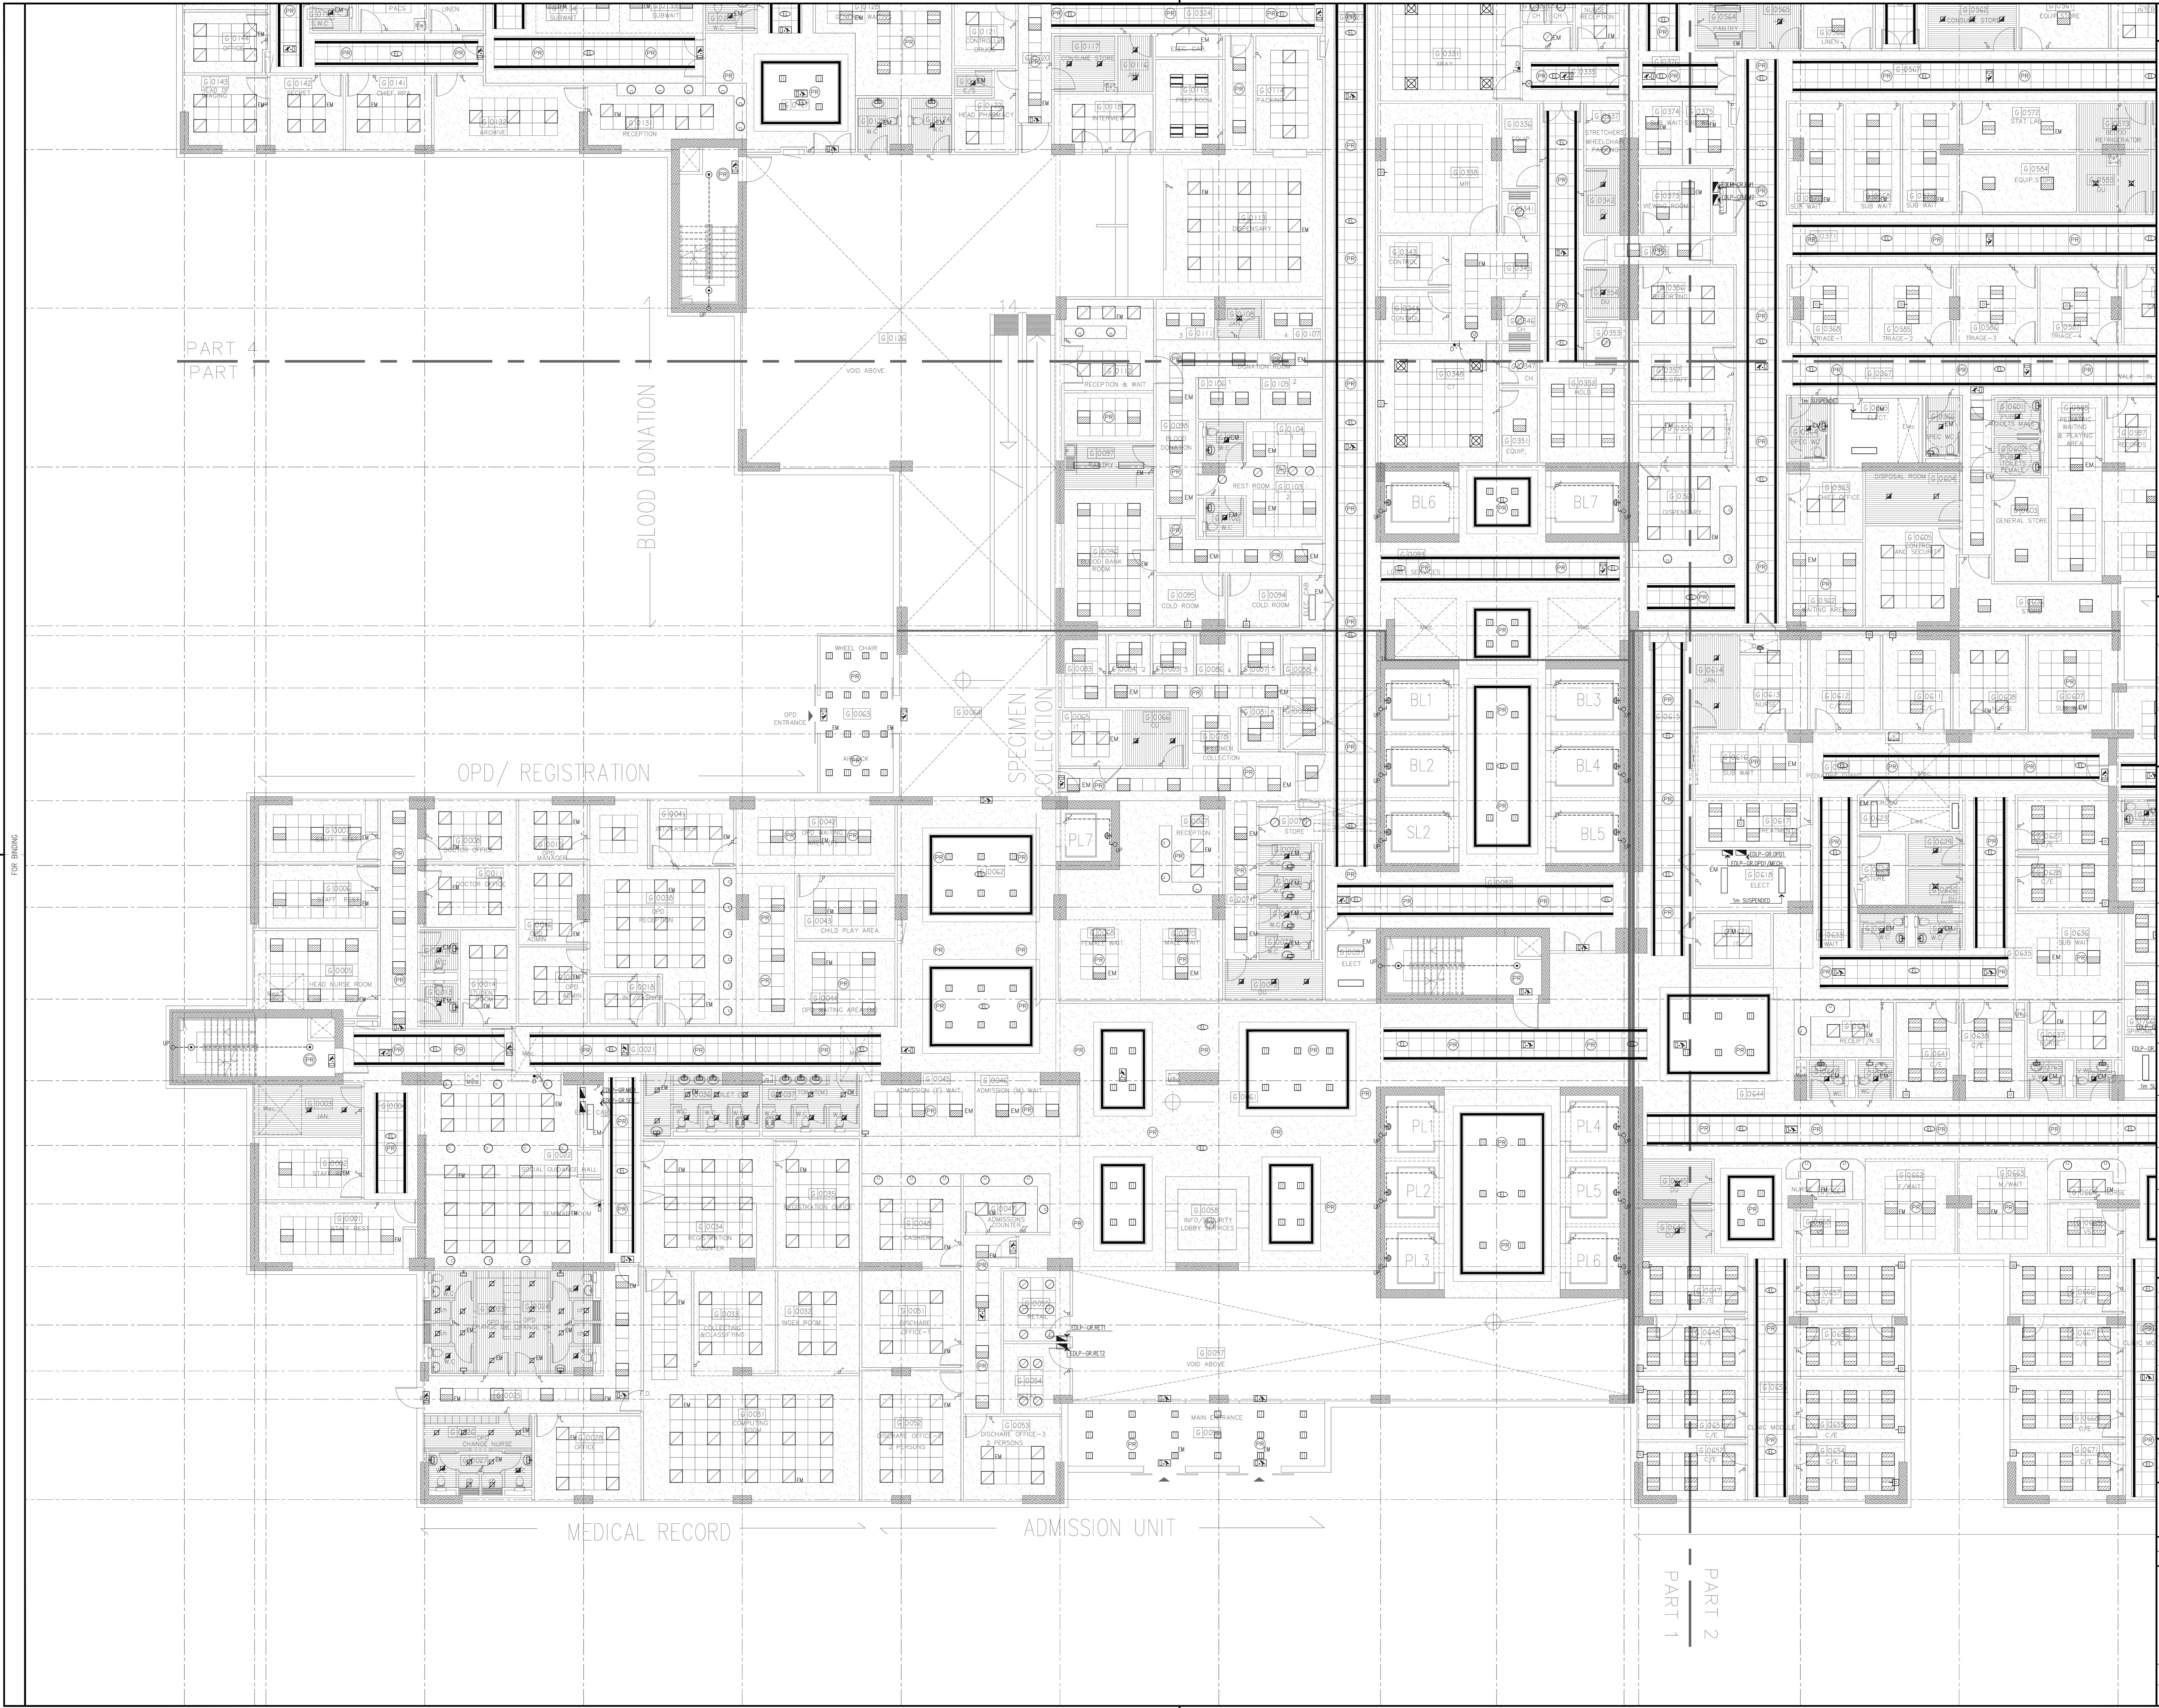

General Notes :

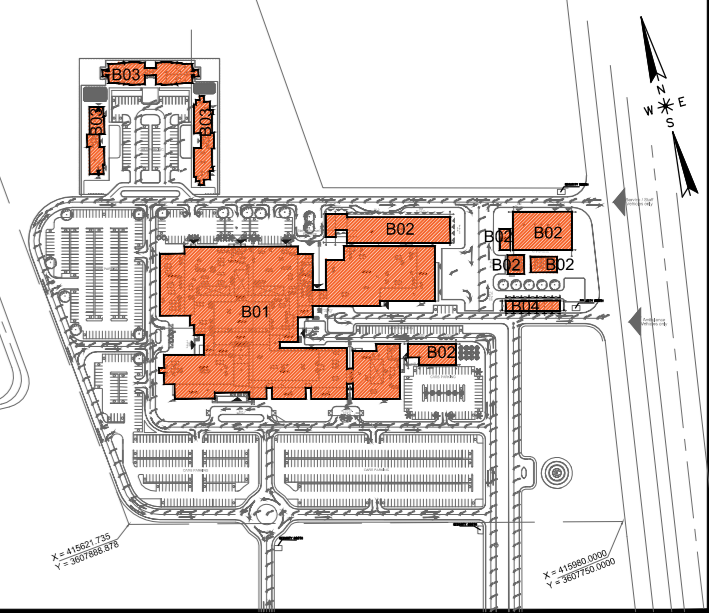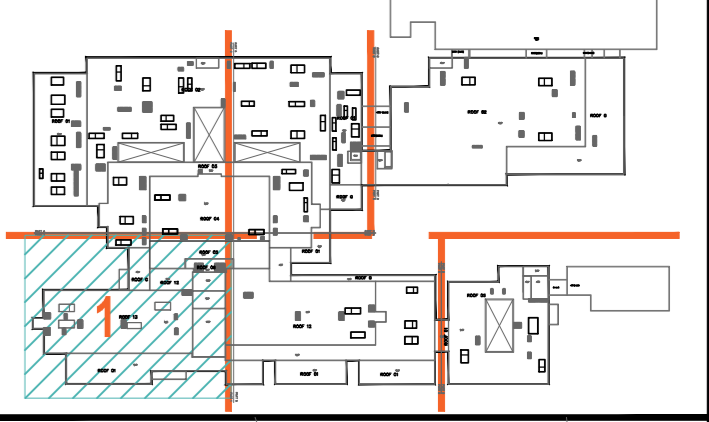

MINISTRY OF HIGHER EDUCATION
AND SCIENTIFIC RESEARCH
University Of Karbala



PROJECT MANAGEMENT CONSULTANT
AM TECH

MAIN CONTRACTOR
FOURTH DIMENSION
Consulting Engineering & Construction

PRINCIPAL ENGINEERING CONSULTANT
ARABTECH JARDANEH

CONSULTING HEALTH PLANNERS
HDP healthcare designers
and project managers

CONSULTING INTERNATIONAL ARCHITECTS
LEO A DALY

THIS DRAWING IS THE
COPYRIGHT OF ARABTECH
JARDANEH ENGINEERS &
ARCHITECTS AND MUST NOT BE
REPRODUCED, COPIED OR USED
WITHOUT THE CONSULTANTS
AUTHORIZATION

REV.	DESCRIPTION	APPRO. BY	DATE
1			
2			
3			
4			
5			
6			
7			
8			
9			
10			


DRAWN BY: E.D. DESIGNED BY: H.O.M./SH
CHECKED BY: M.M.H. APPROVED BY: F.J.
QC REVIEW BY: B.M. DWG ISSUE DATE: 26.10.2014

PROJECT:
**KARBALA 600 BED TEACHING
UNIVERSITY HOSPITAL, IRAQ**

CONCEPT DESIGN STAGE
PRELIMINARY DESIGN STAGE
DESIGN DEVELOPMENT STAGE
CONSTRUCTION DRAWINGS STAGE

DRAWING TITLE:
**GROUND FLOOR PLAN
LIGHTING LAYOUT
PART 1**

JOB # 01586 DWG KUH-EL-102 BLOCK B01
1:100 1/4" = 1'-0" Sht. 01 of 06 REV. RO

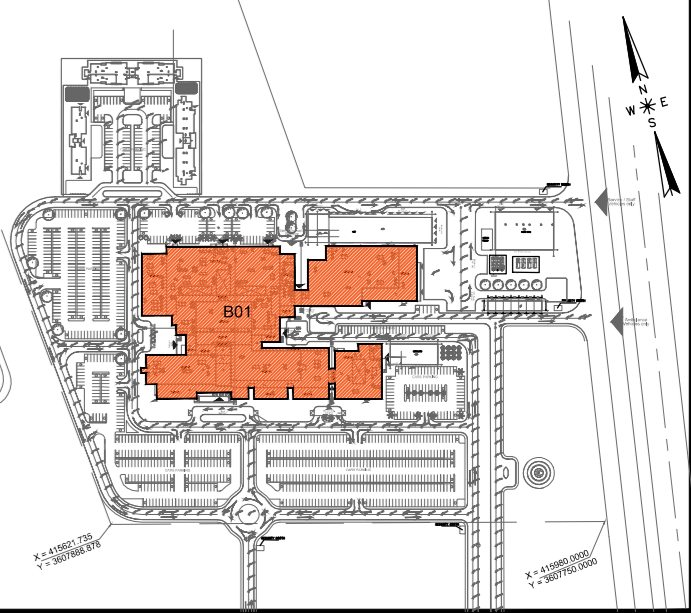




MAIN Contractor :



FOURTH DIMENSION
Contracting Engineering procurement



C.B.C

CONSULTING HEALTH PLANNERS :

HDP | healthcare designers
and project managers

THIS DRAWING IS THE
COPYRIGHT OF ARABTECH
JARDANEH ENGINEERS &
ARCHITECTS AND MUST NOT BE
RETAINED, COPIED OR USED
WITHOUT THE CONSULTANTS'
AUTHORIZATION



DRAWN BY:	E.D	DESIGNED BY:	H.O/M.SH
CHECKED BY:	M.KH	APPROVED BY:	F.J
QC REVIEW BY:	B.M	DWG ISSUE DATE: 26.10.2014	

CONCEPT DESIGN STAGE	PRELIMINARY DESIGN STAGE
DESIGN DEVELOPMENT STAGE	CONSTRUCTION DRAWINGS STAGE

DB 01586	DWG KUH-EL-104	BLOCK * B01
1:100 ⊗ (A0)	Sht. 03 of 06	REV. * R0

CAD FILE NAME: 01586-EL-104-B01-R0.DWG

General Notes :

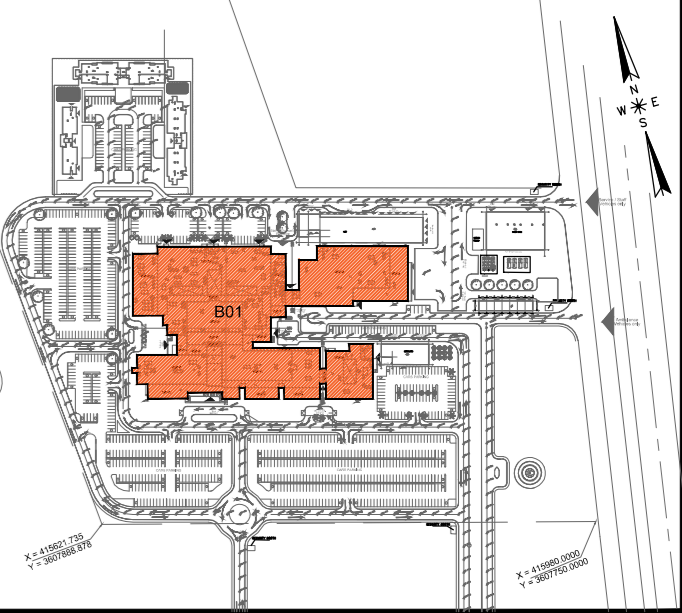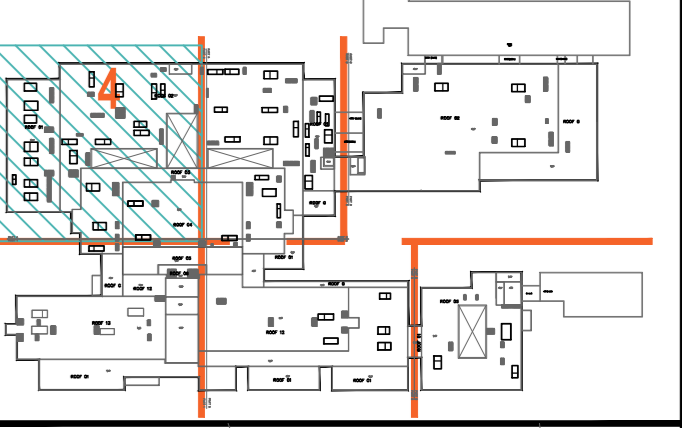

OWNER:
MINISTRY OF HIGHER EDUCATION
AND SCIENTIFIC RESEARCH
University Of Karbala



PRINCIPAL ENGINEERING CONSULTANT:
ARABTECH JARDANEH

CONSULTING HEALTH PLANNERS:
HDP healthcare designers
and project managers

CONSULTING INTERNATIONAL ARCHITECTS:
LEO A DALY

THIS DRAWING IS THE
COPYRIGHT OF ARABTECH
JARDANEH ENGINEERS &
ARCHITECTS AND MUST NOT BE
REPRODUCED, COPIED OR USED
WITHOUT THE CONSULTANTS
AUTHORIZATION

REV.	DESCRIPTION	APPRO. BY	DATE
1			26/10/2014

DRAWN BY: E.D. DESIGNED BY: H.O.M.S.H.
CHECKED BY: M.M.H. APPROVED BY: F.J.
QC REVIEW BY: B.M. DWG ISSUE DATE: 26.10.2014

PROJECT:
**KARBALA 600 BED TEACHING
UNIVERSITY HOSPITAL, IRAQ**

CONCEPT DESIGN STAGE
PRELIMINARY DESIGN STAGE
DESIGN DEVELOPMENT STAGE
CONSTRUCTION DRAWINGS STAGE

DRAWING TITLE:

**GROUND FLOOR PLAN
LIGHTING LAYOUT
PART 4**

JOB # 01586 DWG KUH-EL-105 BLOCK B01
1:100 (A0) Sht. 04 of 06 REV. R0

EMERGENCY THE

MORGUE

MEDICAL IMAGING


PART 5
PART 4

PART 4
PART 1

ATION

VOID ABOVE

This architectural floor plan shows a building layout with various rooms and corridors. A specific room, labeled with a large red number '6', is highlighted with a blue hatched pattern. This room is located in the upper right portion of the plan. The rest of the building is shown in a standard line-drawing style with labels for different areas.

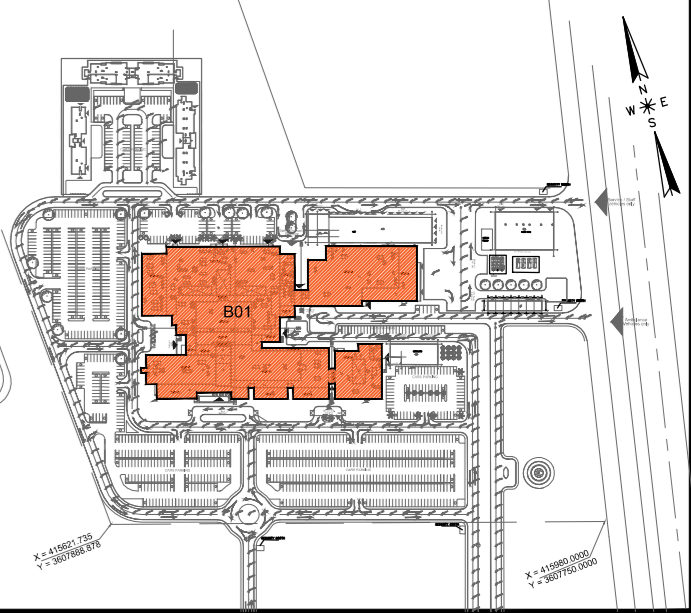

MAIN Contractor :



FOURTH DIMENSION
Contracting Engineering procurement



C.B.C

CONSULTING HEALTH PLANNERS :

HDP | healthcare designers
and project managers

CONSULTING INTERNATIONAL ARCHITECTS :
LEO A DALY PLANNING ARCHITECTURE ENGINEERING INTERIORS

THIS DRAWING IS THE
COPYRIGHT OF ARABTECH
JARDANEH ENGINEERS &
CHITECTS AND MUST NOT BE
RETAINED, COPIED OR USED
WITHOUT THE CONSULTANTS'
AUTHORIZATION

[illegible]

DRAWN BY:	E.D	DESIGNED BY:	H.O/M.SH
CHECKED BY:	M.KH	APPROVED BY:	F.J
QC REVIEW BY:	B.M	DWG ISSUE DATE: 26.10.2014	

PROJECT:
KARBALA 600 BED TEACHING
UNIVERSITY HOSPITAL, IRAQ



CONCEPT DESIGN STAGE	PRELIMINARY DESIGN STAGE
DESIGN DEVELOPMENT STAGE	CONSTRUCTION DRAWINGS STAGE

GROUND FLOOR PLAN
LIGHTING LAYOUT
PART 6

01586	DWG KUH-EL-107	BLOCK *	B01
1:100 (A0)	Sheet 06 of 06	REV. *	R0

SAVED BY: Afif.qlbssed ON: 25.10.2014 @ 08:49 CAD FILE NAME: 01586-EL-107-B01-R0.DWG

General Notes :

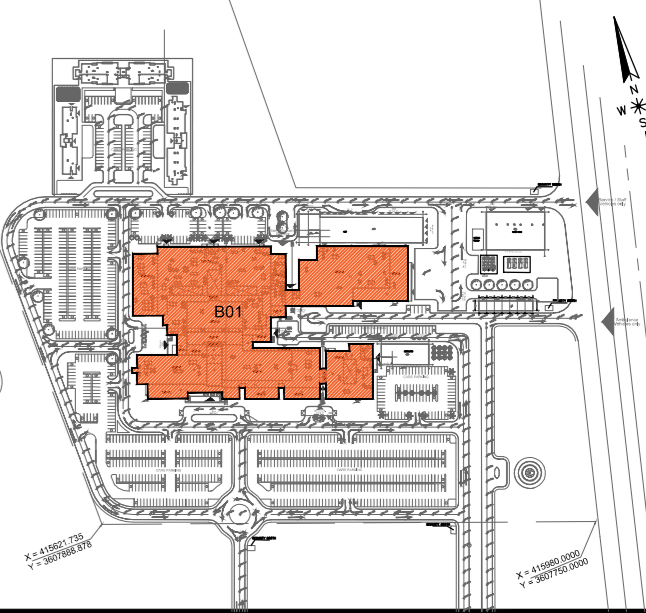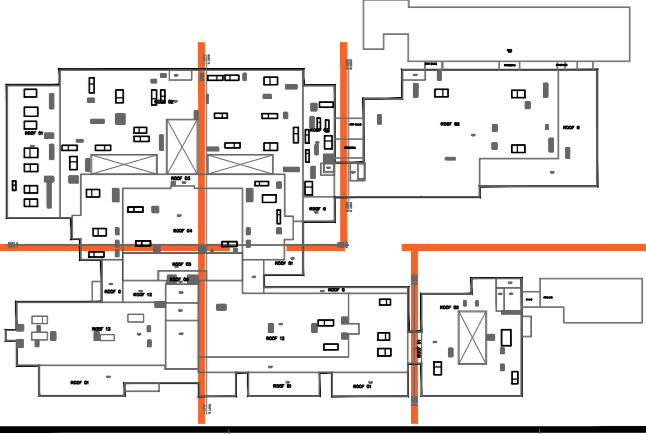

MINISTRY OF HIGHER EDUCATION
AND SCIENTIFIC RESEARCH
University Of Karbala



PROJECT MANAGEMENT CONSULTANT
AM TECH

MAIN CONTRACTOR
FOURTH DIMENSION
Consulting Engineering & Construction
CIS C

PRINCIPAL ENGINEERING CONSULTANT
ARABTECH JARDANEH

CONSULTING HEALTH PLANNERS
HDP healthcare designers
and project managers

CONSULTING INTERNATIONAL ARCHITECTS
LEO A DALY
PLANNING ARCHITECTURE ENGINEERING INTERIORS

THIS DRAWING IS THE
COPYRIGHT OF ARABTECH
JARDANEH ENGINEERS &
ARCHITECTS AND MUST NOT BE
REPRODUCED, COPIED OR USED
WITHOUT THE CONSULTANTS
AUTHORIZATION

REV.	DESCRIPTION	APPRO. BY	DATE

DRAWN BY: E.D. DESIGNED BY: H.O.M.S.H.
CHECKED BY: M.K.H. APPROVED BY: F.J.
QC REVIEW BY: B.M. DWG ISSUE DATE: 26.10.2014


PROJECT:
**KARBALA 600 BED TEACHING
UNIVERSITY HOSPITAL, IRAQ**

CONCEPT DESIGN STAGE
PRELIMINARY DESIGN STAGE
DESIGN DEVELOPMENT STAGE
CONSTRUCTION DRAWINGS STAGE



DRAWING TITLE:

FIRST FLOOR PLAN
LIGHTING LAYOUT
OVERALL

A01 01586 DWG KUH-EL-108 BLOCK B01
1:250 1/4" (A0) Sht. 01 of 01 REV. RO

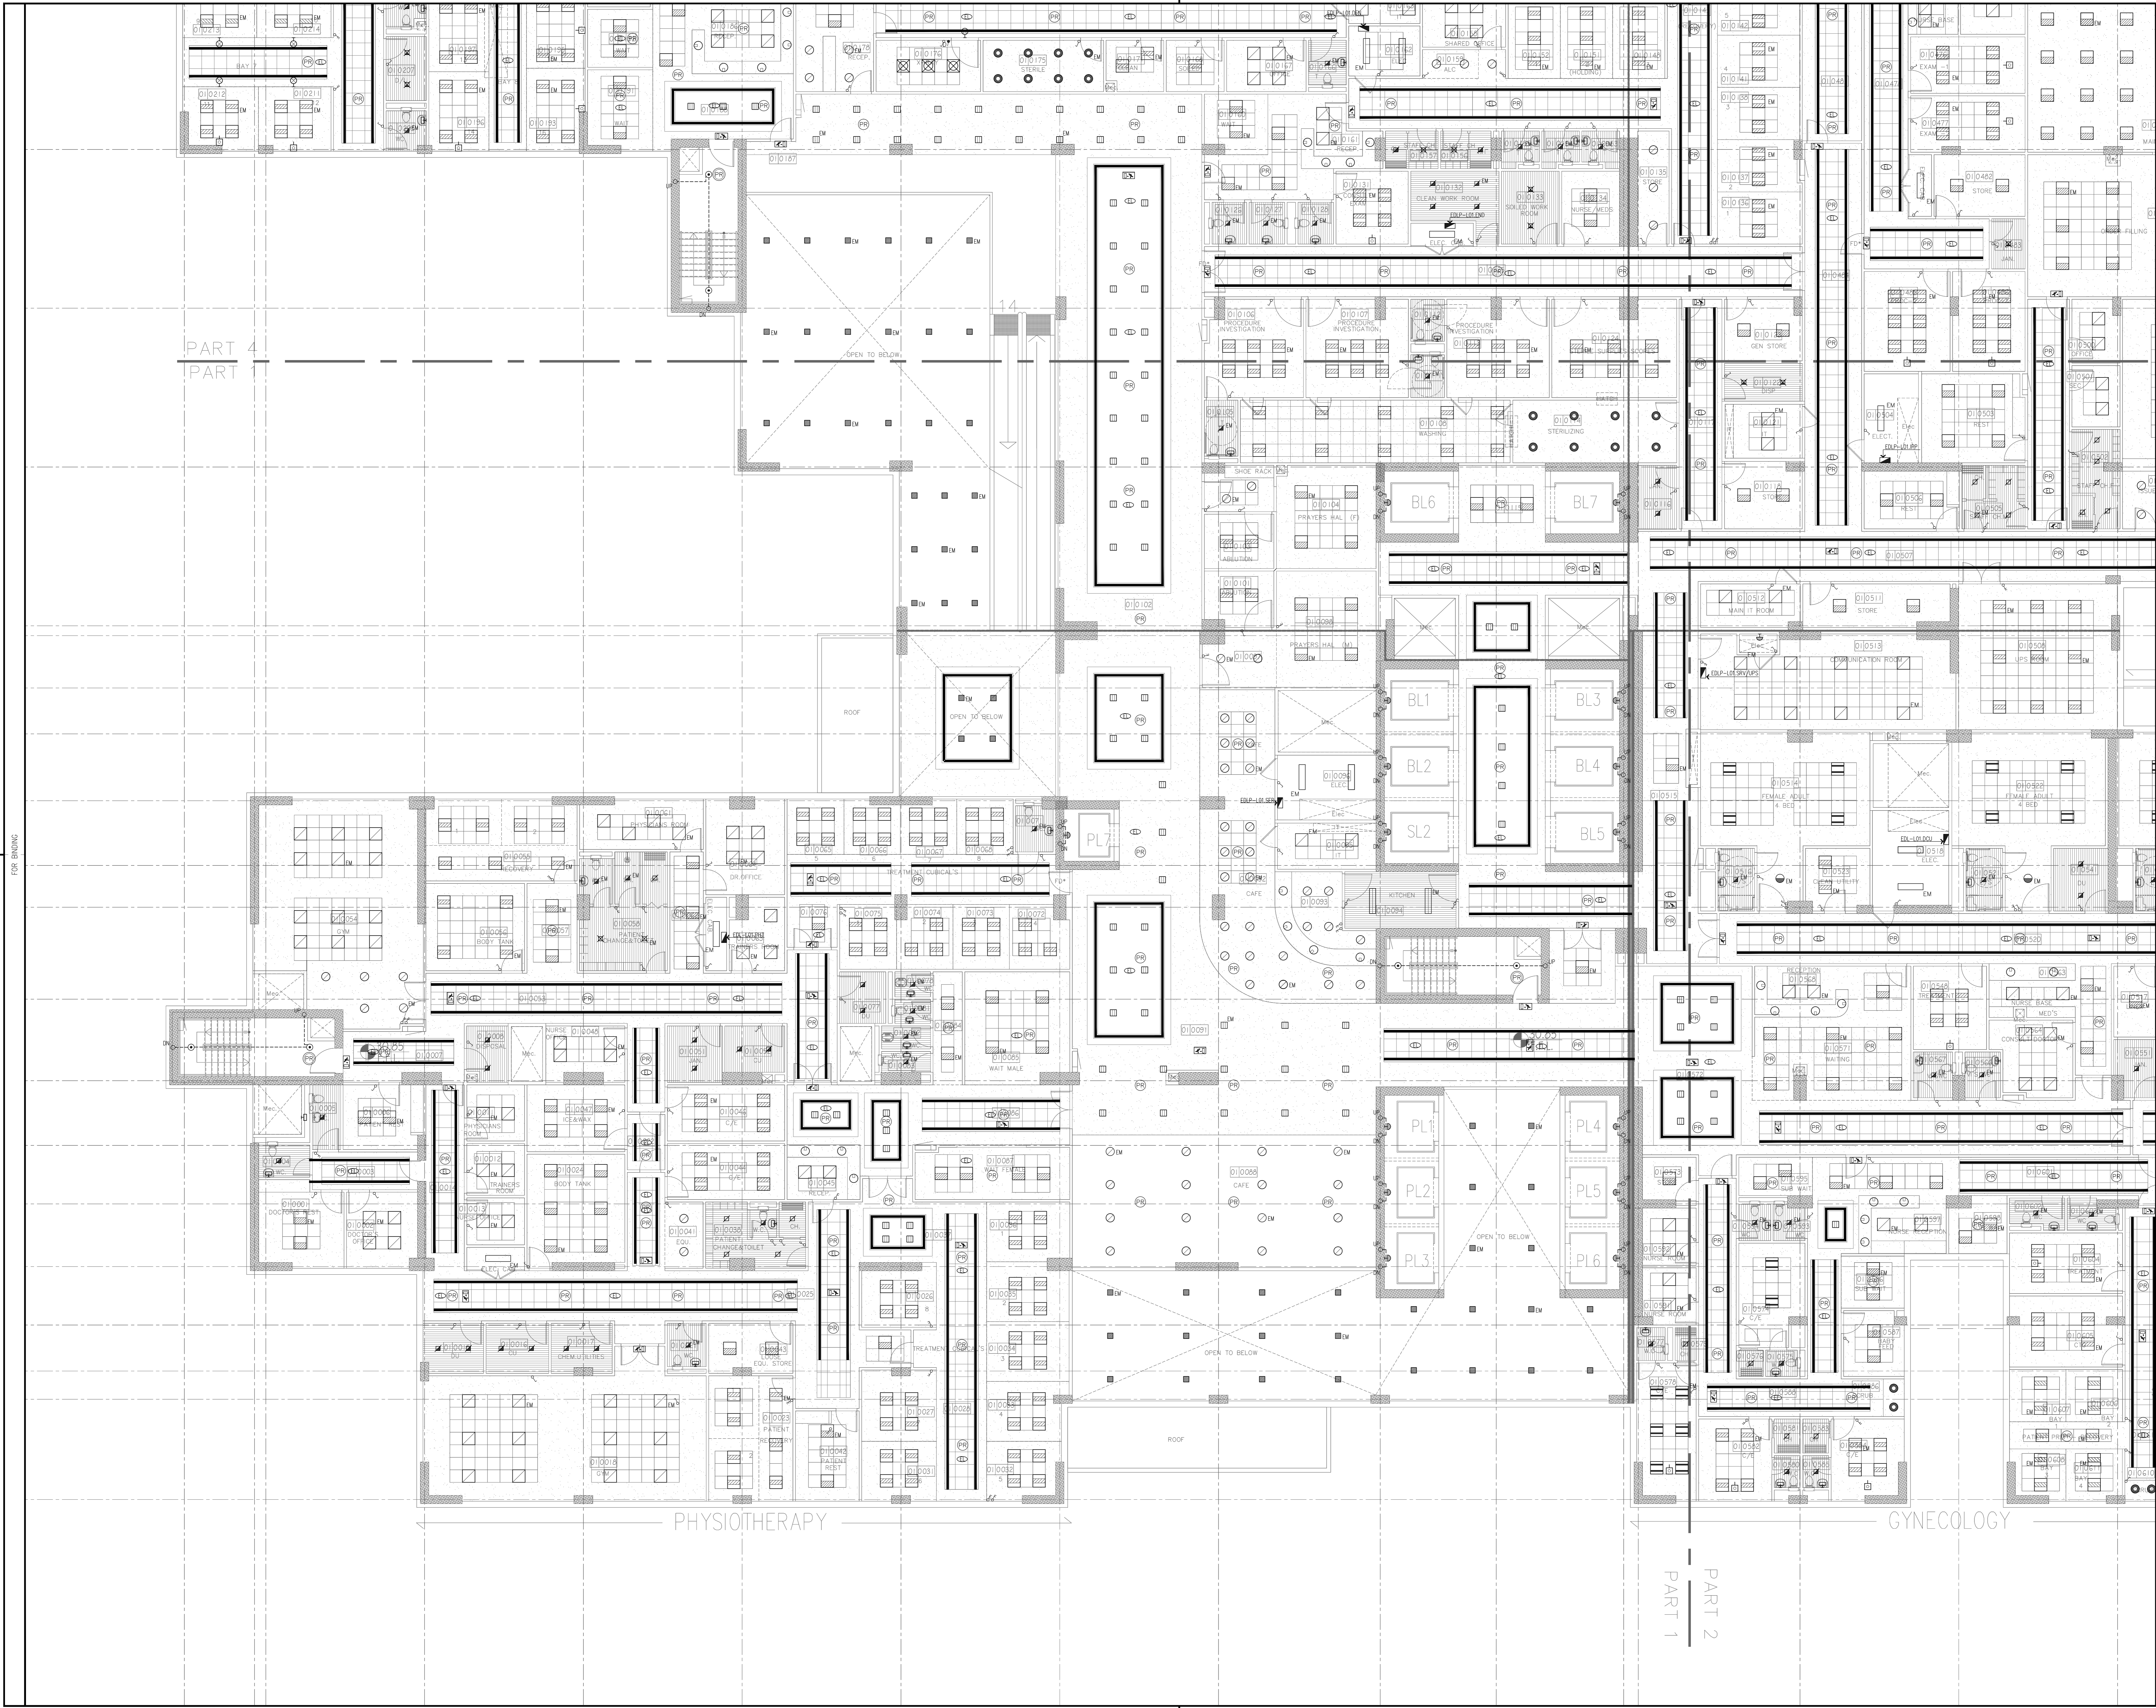

General Notes :

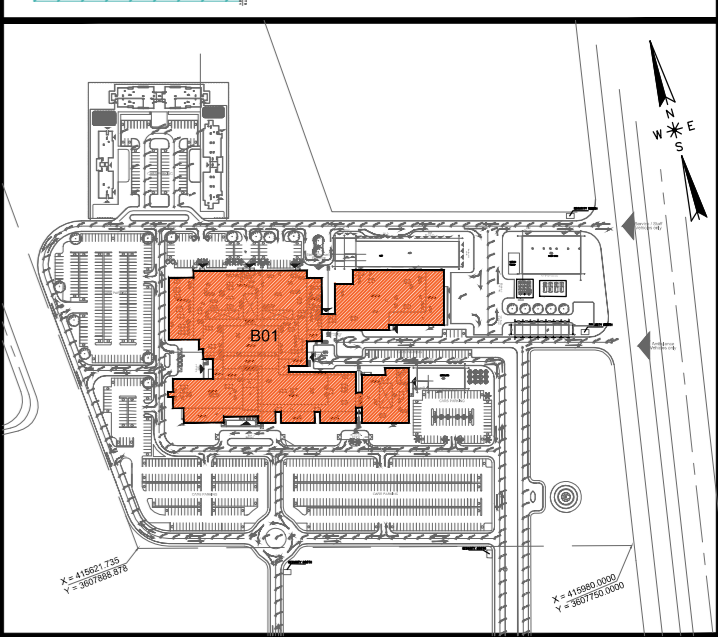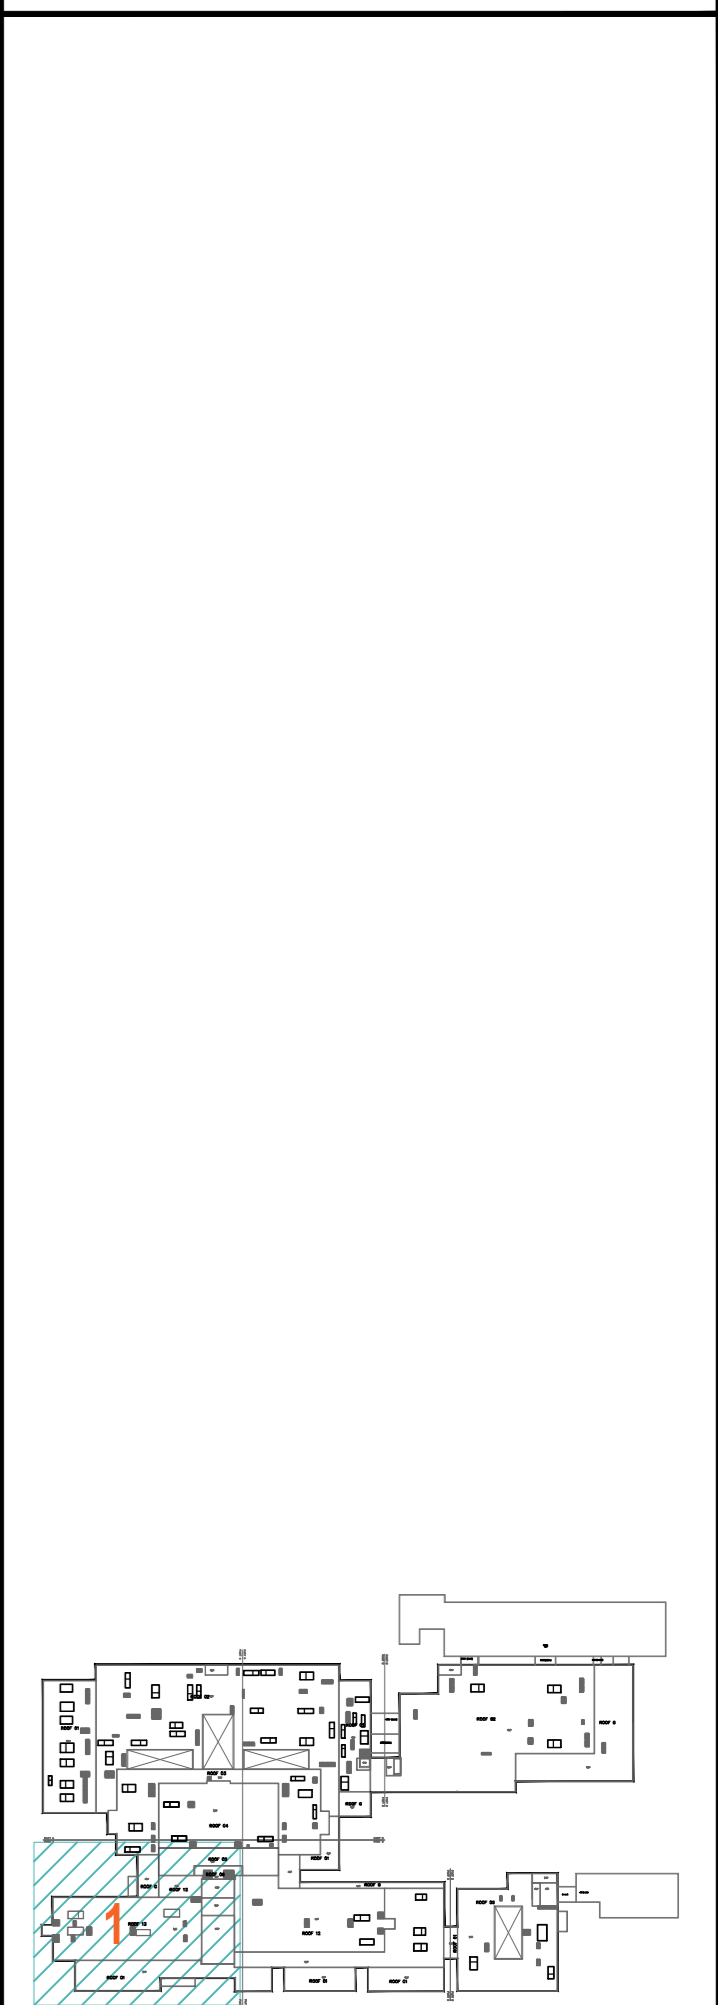

MINISTRY OF HIGHER EDUCATION
AND SCIENTIFIC RESEARCH
University Of Karbala



PROJECT MANAGEMENT CONSULTANT
AM TECH



MAIN CONTRACTOR
FOURTH DIMENSION
Consulting Engineering & Construction

PRINCIPAL ENGINEERING CONSULTANT
ARABTECH JARDANEH

CONSULTING HEALTH PLANNERS
HDP healthcare designers
and project managers

CONSULTING INTERNATIONAL ARCHITECTS
LEO A DALY
PLANNING ARCHITECTURE ENGINEERING INTERIORS

THIS DRAWING IS THE
COPYRIGHT OF ARABTECH
JARDANEH ENGINEERS &
ARCHITECTS AND MUST NOT BE
REPRODUCED, COPIED OR USED
WITHOUT THE CONSULTANTS
AUTHORIZATION

REV.	DESCRIPTION	APPRO. BY	DATE
1			
2			
3			
4			
5			
6			
7			
8			
9			
10			


DRAWN BY: E.D. DESIGNED BY: H.O.M.H.
CHECKED BY: M.M.H. APPROVED BY: F.J.
QC REVIEW BY: B.M. DWG ISSUE DATE: 26.10.2014

PROJECT:
**KARBALA 600 BED TEACHING
UNIVERSITY HOSPITAL, IRAQ**

CONCEPT DESIGN STAGE
PRELIMINARY DESIGN STAGE
DESIGN DEVELOPMENT STAGE
CONSTRUCTION DRAWINGS STAGE

DRAWING TITLE:
**FIRST FLOOR PLAN
LIGHTING LAYOUT
PART 1**

A08 01586 DWG KUH-EL-109 BLOCK B01
1:100 01 of 06 REV. R0

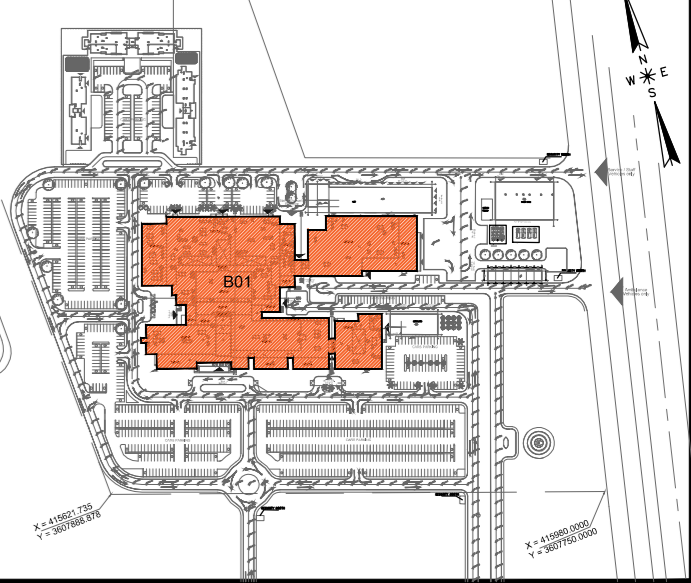

MAIN Contractor :  

CONSULTING HEALTH PLANNERS :

HDP | healthcare designers
and project managers

CONSULTING INTERNATIONAL ARCHITECTS :
LEO A DALY PLANNING ARCHITECTURE ENGINEERING INTERIORS

[illegible]



PROJECT:
KARBALA 600 BED TEACHING
UNIVERSITY HOSPITAL, IRAQ

CONCEPT DESIGN STAGE	PRELIMINARY DESIGN STAGE
DESIGN DEVELOPMENT STAGE	CONSTRUCTION DRAWINGS STAGE

DRAWING TITLE:

01586	DWG KUH-EL-111	BLOCK *	B01
1:100 @ (A0)	Sheet 03 of 06	REV. *	R0

General Notes :

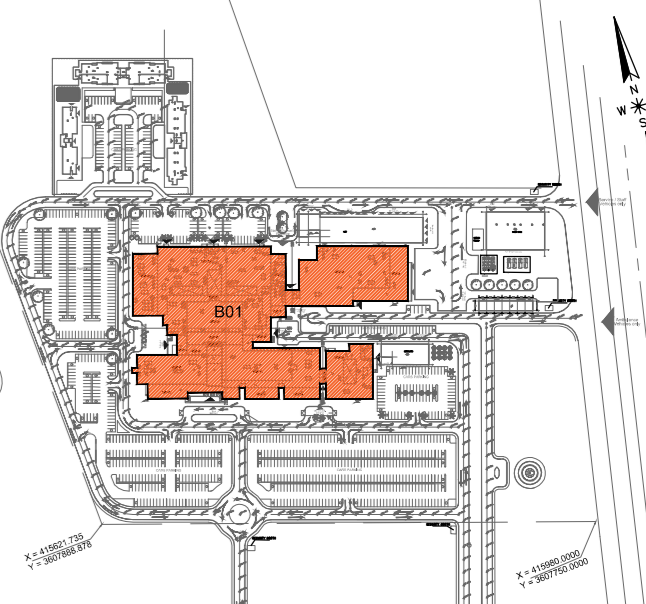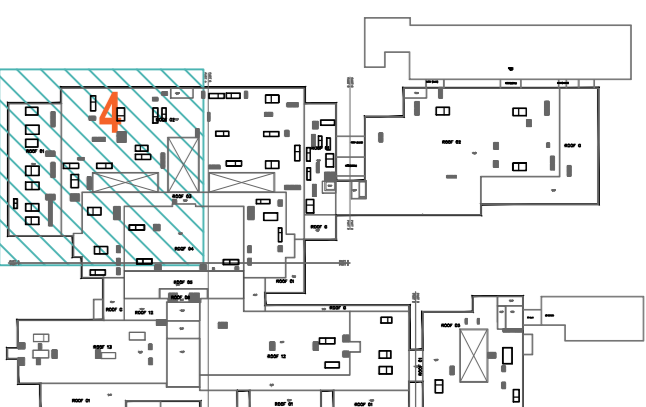

OWNER:
MINISTRY OF HIGHER EDUCATION
AND SCIENTIFIC RESEARCH
University Of Karbala



PROJECT MANAGEMENT CONSULTANT:
AM TECH

MAIN CONTRACTOR:
FOURTH DIMENSION
Consulting Engineering & Construction

PRINCIPAL ENGINEERING CONSULTANT:
ARABTECH JARDANEH

CONSULTING HEALTH PLANNERS:
HDP healthcare designers
and project managers

CONSULTING INTERNATIONAL ARCHITECTS:
LEO A DALY
PLANNING ARCHITECTURE ENGINEERING INTERIORS

THIS DRAWING IS THE
COPYRIGHT OF ARABTECH
JARDANEH ENGINEERS &
ARCHITECTS AND MUST NOT BE
REPRODUCED, COPIED OR USED
WITHOUT THE CONSULTANTS
AUTHORIZATION

REV.	DESCRIPTION	APPRO. BY	DATE
1			
2			
3			
100			

DRAWN BY: E.D. DESIGNED BY: H.O.M.S.H.
CHECKED BY: M.K.H. APPROVED BY: F.J.
QC REVIEW BY: B.M. DWG ISSUE DATE: 26.10.2014


PROJECT:
**KARBALA 600 BED TEACHING
UNIVERSITY HOSPITAL, IRAQ**

CONCEPT DESIGN STAGE PRELIMINARY DESIGN STAGE
DESIGN DEVELOPMENT STAGE CONSTRUCTION DRAWINGS STAGE



DRAWING TITLE:

FIRST FLOOR PLAN
LIGHTING LAYOUT
PART 4

JOB # 01586 DWG KUH-EL-112 BLOCK B01
I:100 S:401 Sh. 04 of 06 REV. R0

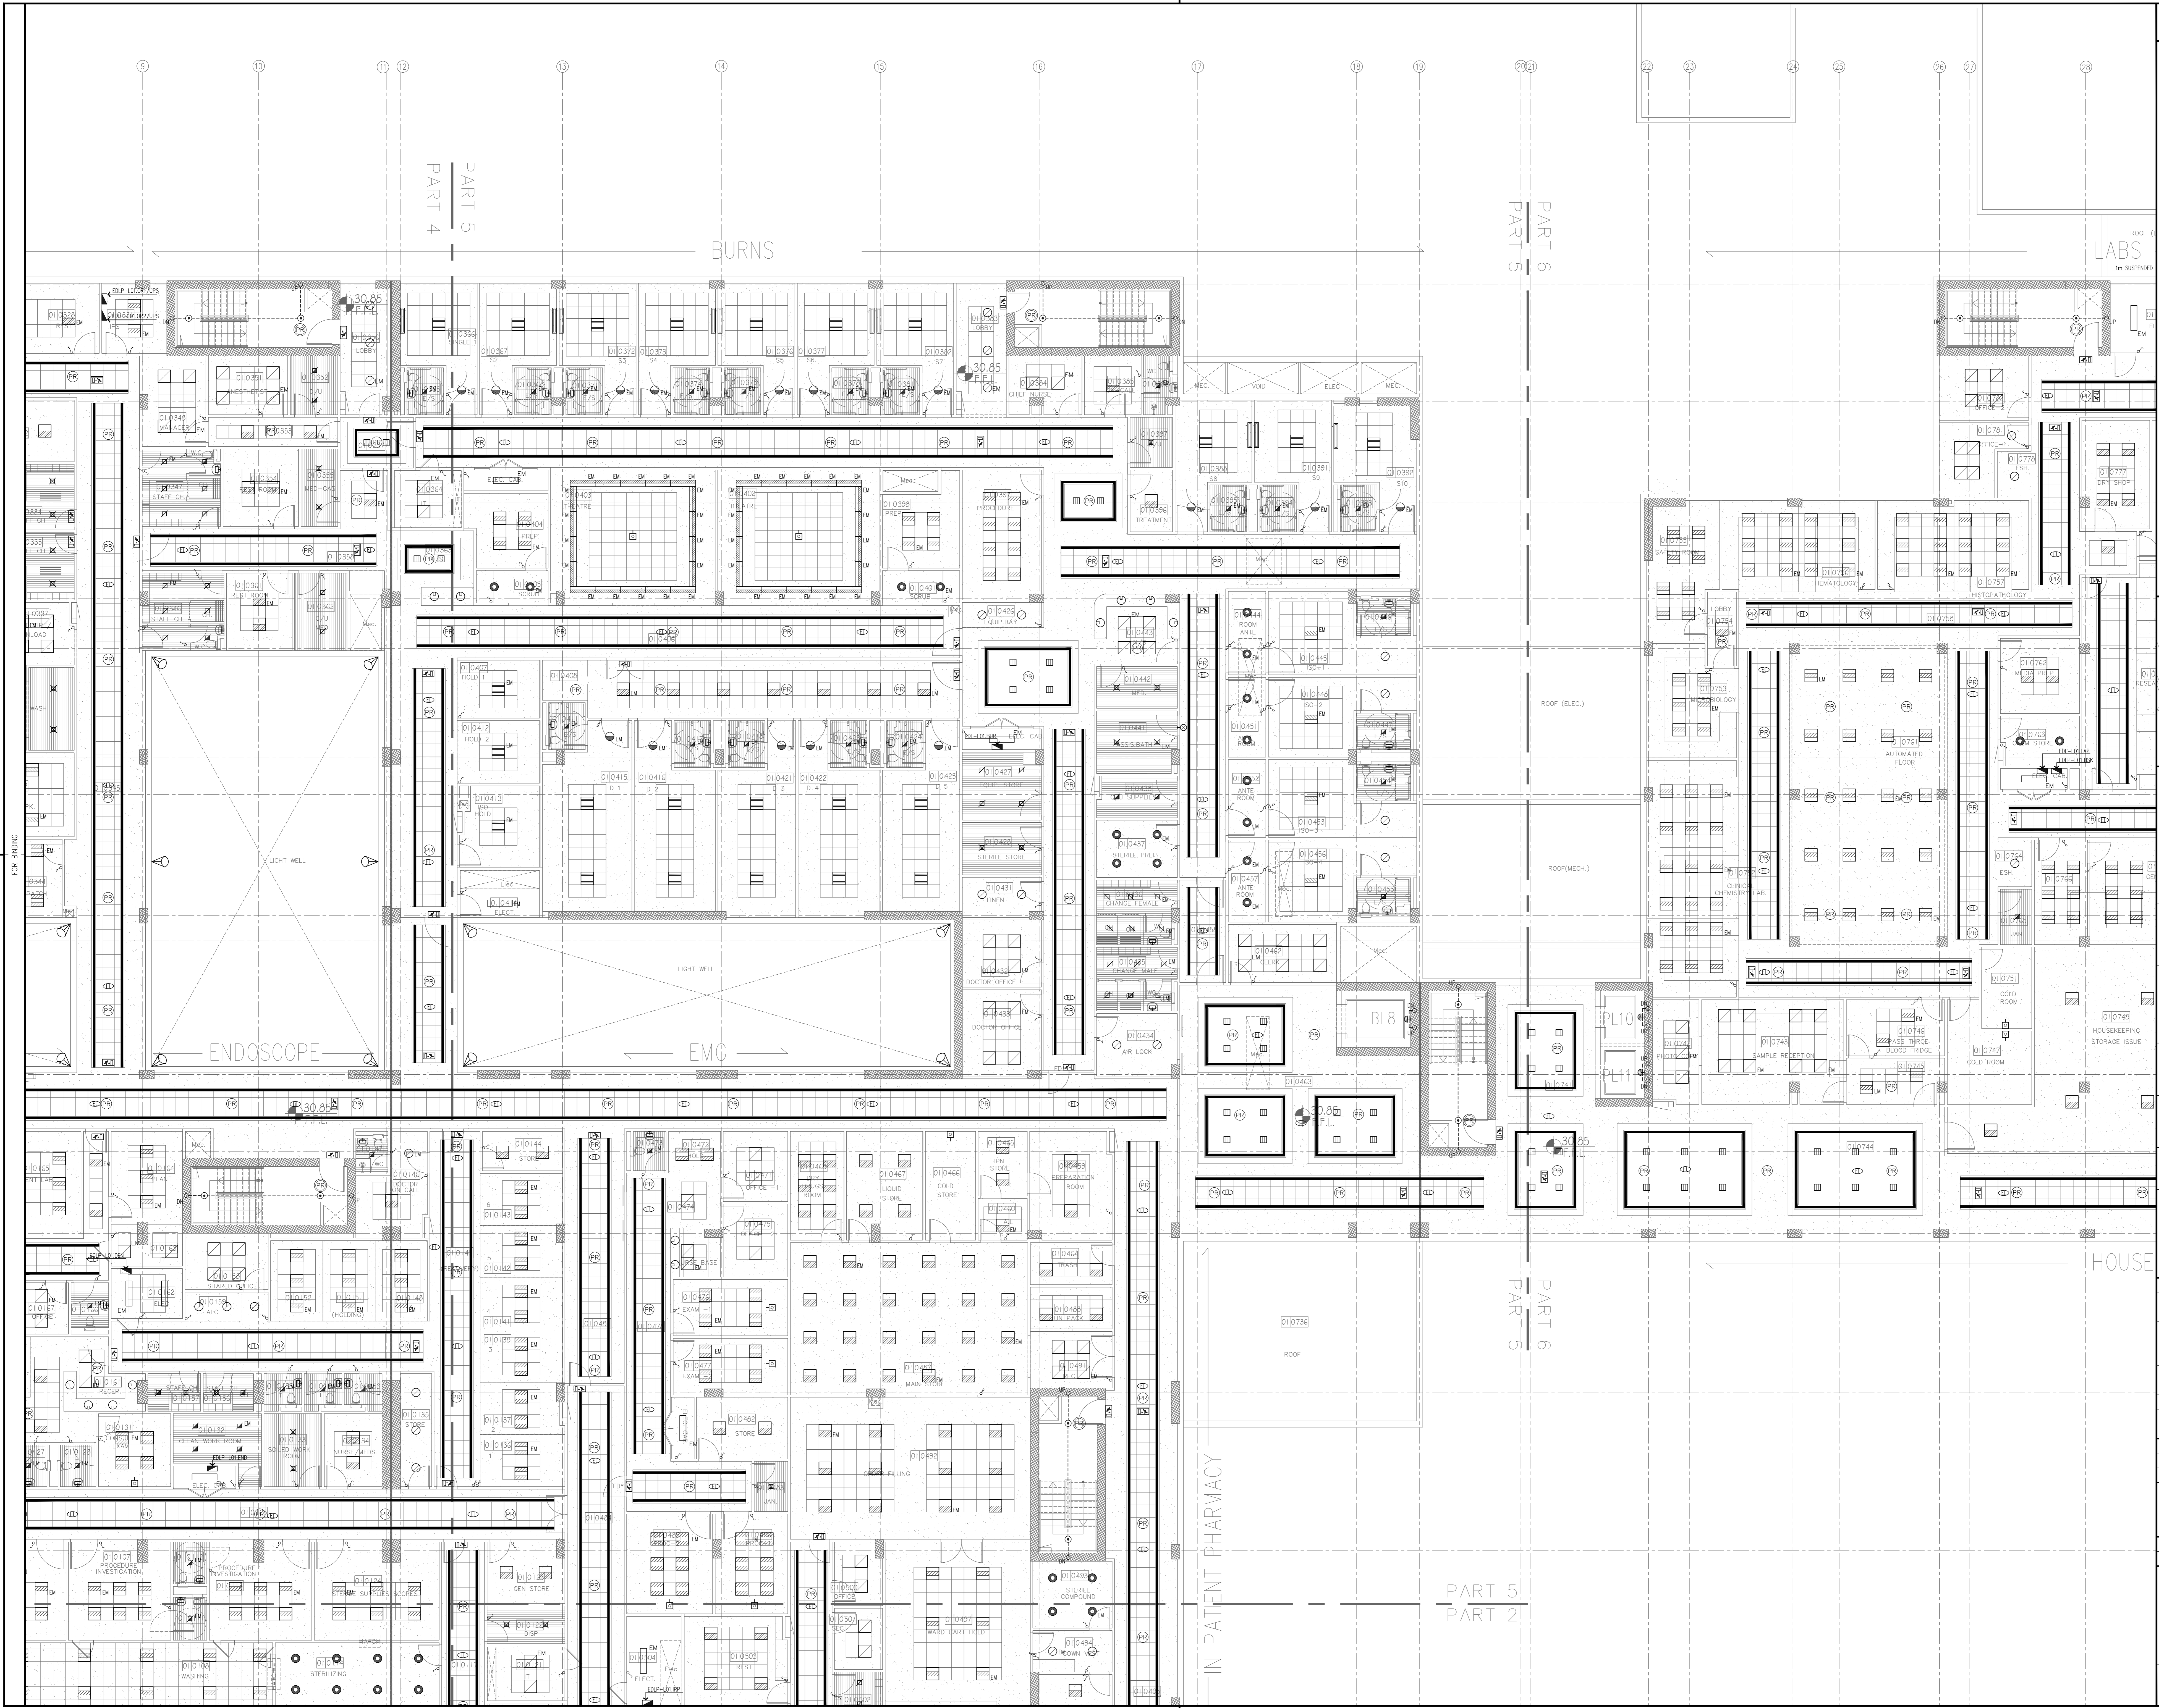

General Notes :

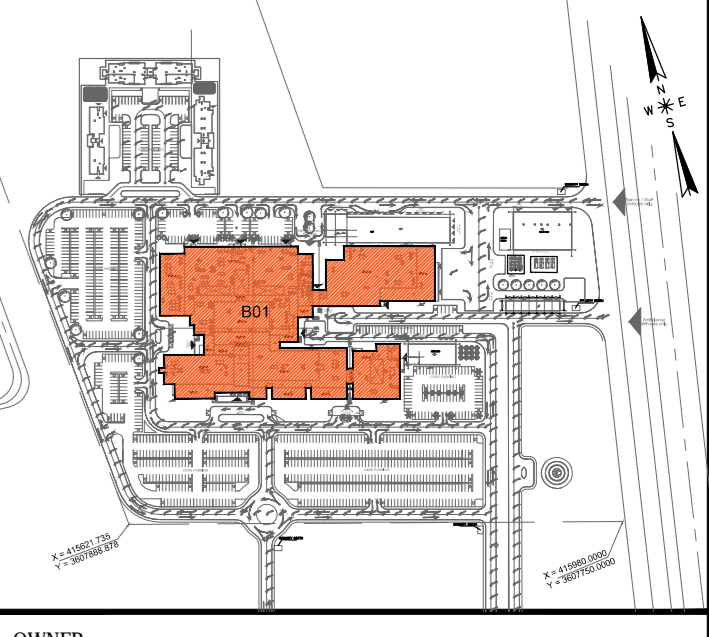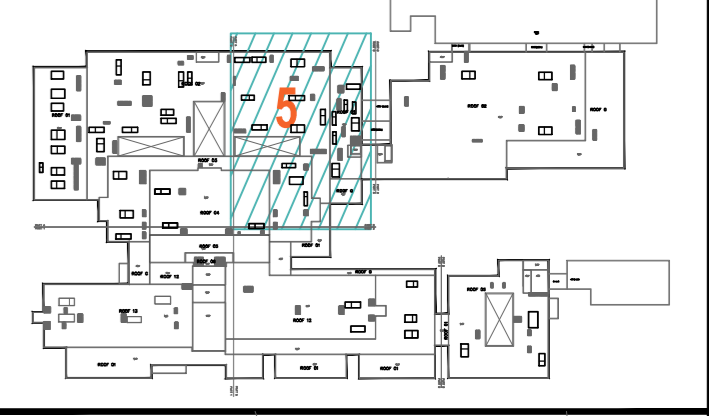

MINISTRY OF HIGHER EDUCATION
AND SCIENTIFIC RESEARCH
University Of Karbala



PRINCIPAL ENGINEERING CONSULTANT:
ARABTECH JARDANEH

CONSULTING HEALTH PLANNERS:
HDP healthcare designers
and project managers

CONSULTING INTERNATIONAL ARCHITECTS:
LEO A DALY

THIS DRAWING IS THE
COPYRIGHT OF ARABTECH
JARDANEH ENGINEERS &
ARCHITECTS AND MUST NOT BE
REPRODUCED, COPIED OR USED
WITHOUT THE CONSULTANTS
AUTHORIZATION

REV.	DESCRIPTION	APPRO. BY	DATE

DRAWN BY: E.D. DESIGNED BY: H.O.M.S.H.
CHECKED BY: M.K.H. APPROVED BY: F.J.
QC REVIEW BY: B.M. DWG ISSUE DATE: 26.10.2014


PROJECT:
**KARBALA 600 BED TEACHING
UNIVERSITY HOSPITAL, IRAQ**

CONCEPT DESIGN STAGE PRELIMINARY DESIGN STAGE
DESIGN DEVELOPMENT STAGE CONSTRUCTION DRAWINGS STAGE

DRAWING TITLE:
**FIRST FLOOR PLAN
LIGHTING LAYOUT
PART 5**

A05 015886 DWG KUH-EL-113 BLOCK B01
1:100 @ (A0) Sht. 05 of 06 REV. R0

The floor plan shows a complex layout of rooms. A large room on the right is shaded with blue diagonal lines and contains a large orange circle with the number '6' inside. Other rooms are labeled with numbers and letters, such as '100', '101', '102', '902', '903

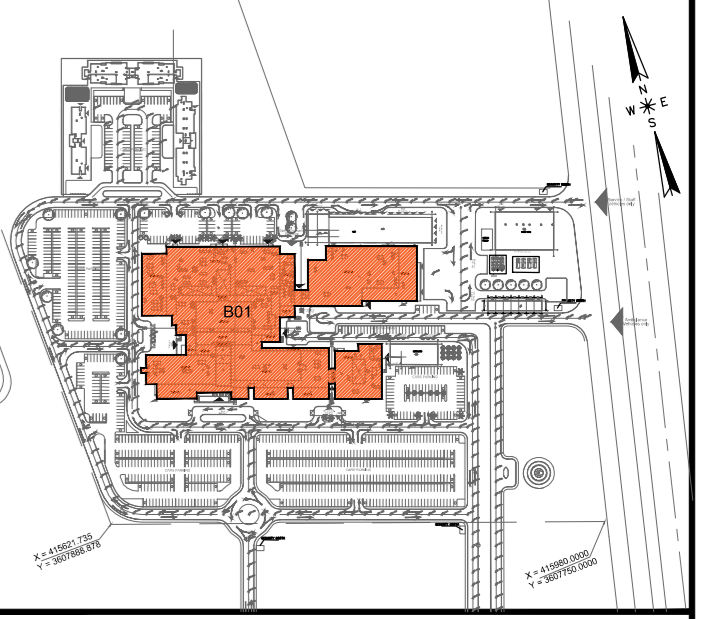

MAIN Contractor :



FOURTH DIMENSION
Contracting Engineering procurement



C/B.C

HDP | healthcare designers
and project managers

CONSULTING INTERNATIONAL ARCHITECTS :
LEO A DALY PLANNING ARCHITECTURE ENGINEERING INTERIORS

THIS DRAWING IS THE
COPYRIGHT OF ARABTECH
JARDANEH ENGINEERS &
ARCHITECTS AND MUST NOT BE
RETAINED, COPIED OR USED
WITHOUT THE CONSULTANTS'
AUTHORIZATION

[illegible]

DRAWN BY:	E.D	DESIGNED BY:	H.O/M.SH
CHECKED BY:	M.KH	APPROVED BY:	F.J
QC REVIEW BY:	B.M	DWG ISSUE DATE: 26.10.2014	


PROJECT:
KARBALA 600 BED TEACHING
UNIVERSITY HOSPITAL, IRAQ

CONCEPT DESIGN STAGE	PRELIMINARY DESIGN STAGE
DESIGN DEVELOPMENT STAGE	CONSTRUCTION DRAWINGS STAGE

DRAWING TITLE:

FIRST FLOOR PLAN
LIGHTING LAYOUT
PART 6

01586	DWG KUH-EL-114	BLOCK * B01
1:100 @ (A0)	Shd. 06 of 06	REV. * R0

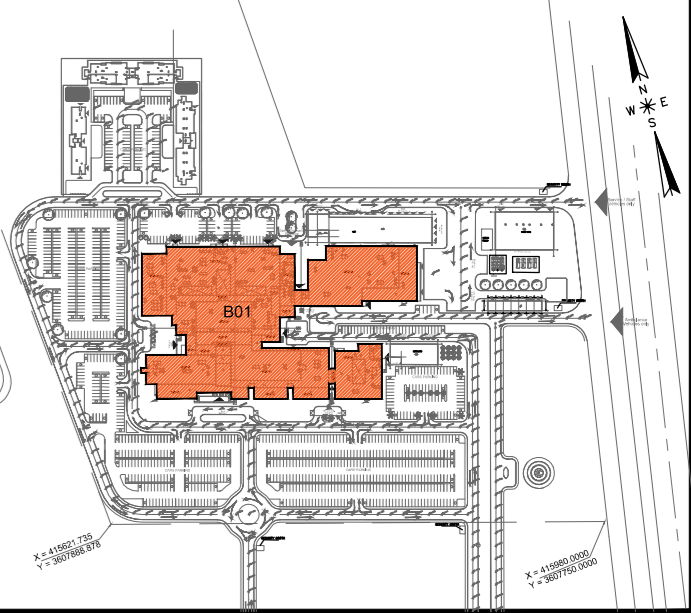

PROJECT MANAGEMENT CONSULTANT :

 **AM
TECH**

MAIN Contractor :



FOURTH DIMENSION
Contracting Engineering procurement



C.B.C

PRINCIPAL ENGINEERING CONSULTANT :
ARABTECH JARDANEH

HDP | healthcare designers
and project managers

CONSULTING INTERNATIONAL ARCHITECTS :
LEO A DALY PLANNING ARCHITECTURE ENGINEERING INTERIORS

THIS DRAWING IS THE
COPYRIGHT OF ARABTECH
JARDANEH ENGINEERS &
CHITECTS AND MUST NOT BE
RETAINED, COPIED OR USED
WITHOUT THE CONSULTANTS'
AUTHORIZATION

[illegible]


DRAWN BY:	E.D	DESIGNED BY:	H.O/M.SH
CHECKED BY:	M.KH	APPROVED BY:	F.J
QC REVIEW BY:	B.M	DWG ISSUE DATE: 26.10.2014	

PROJECT:
KARBALA 600 BED TEACHING
UNIVERSITY HOSPITAL, IRAQ


DESIGN DEVELOPMENT STAGE	CONSTRUCTION DRAWINGS STAGE
DRAWING TITLE:	

SECOND FLOOR PLAN
LIGHTING LAYOUT
OVERALL

01586	DWG KUH-EL-115	BLOCK * B01
1:250 @ (A0)	Sheet 01 of 01	REV. * R0

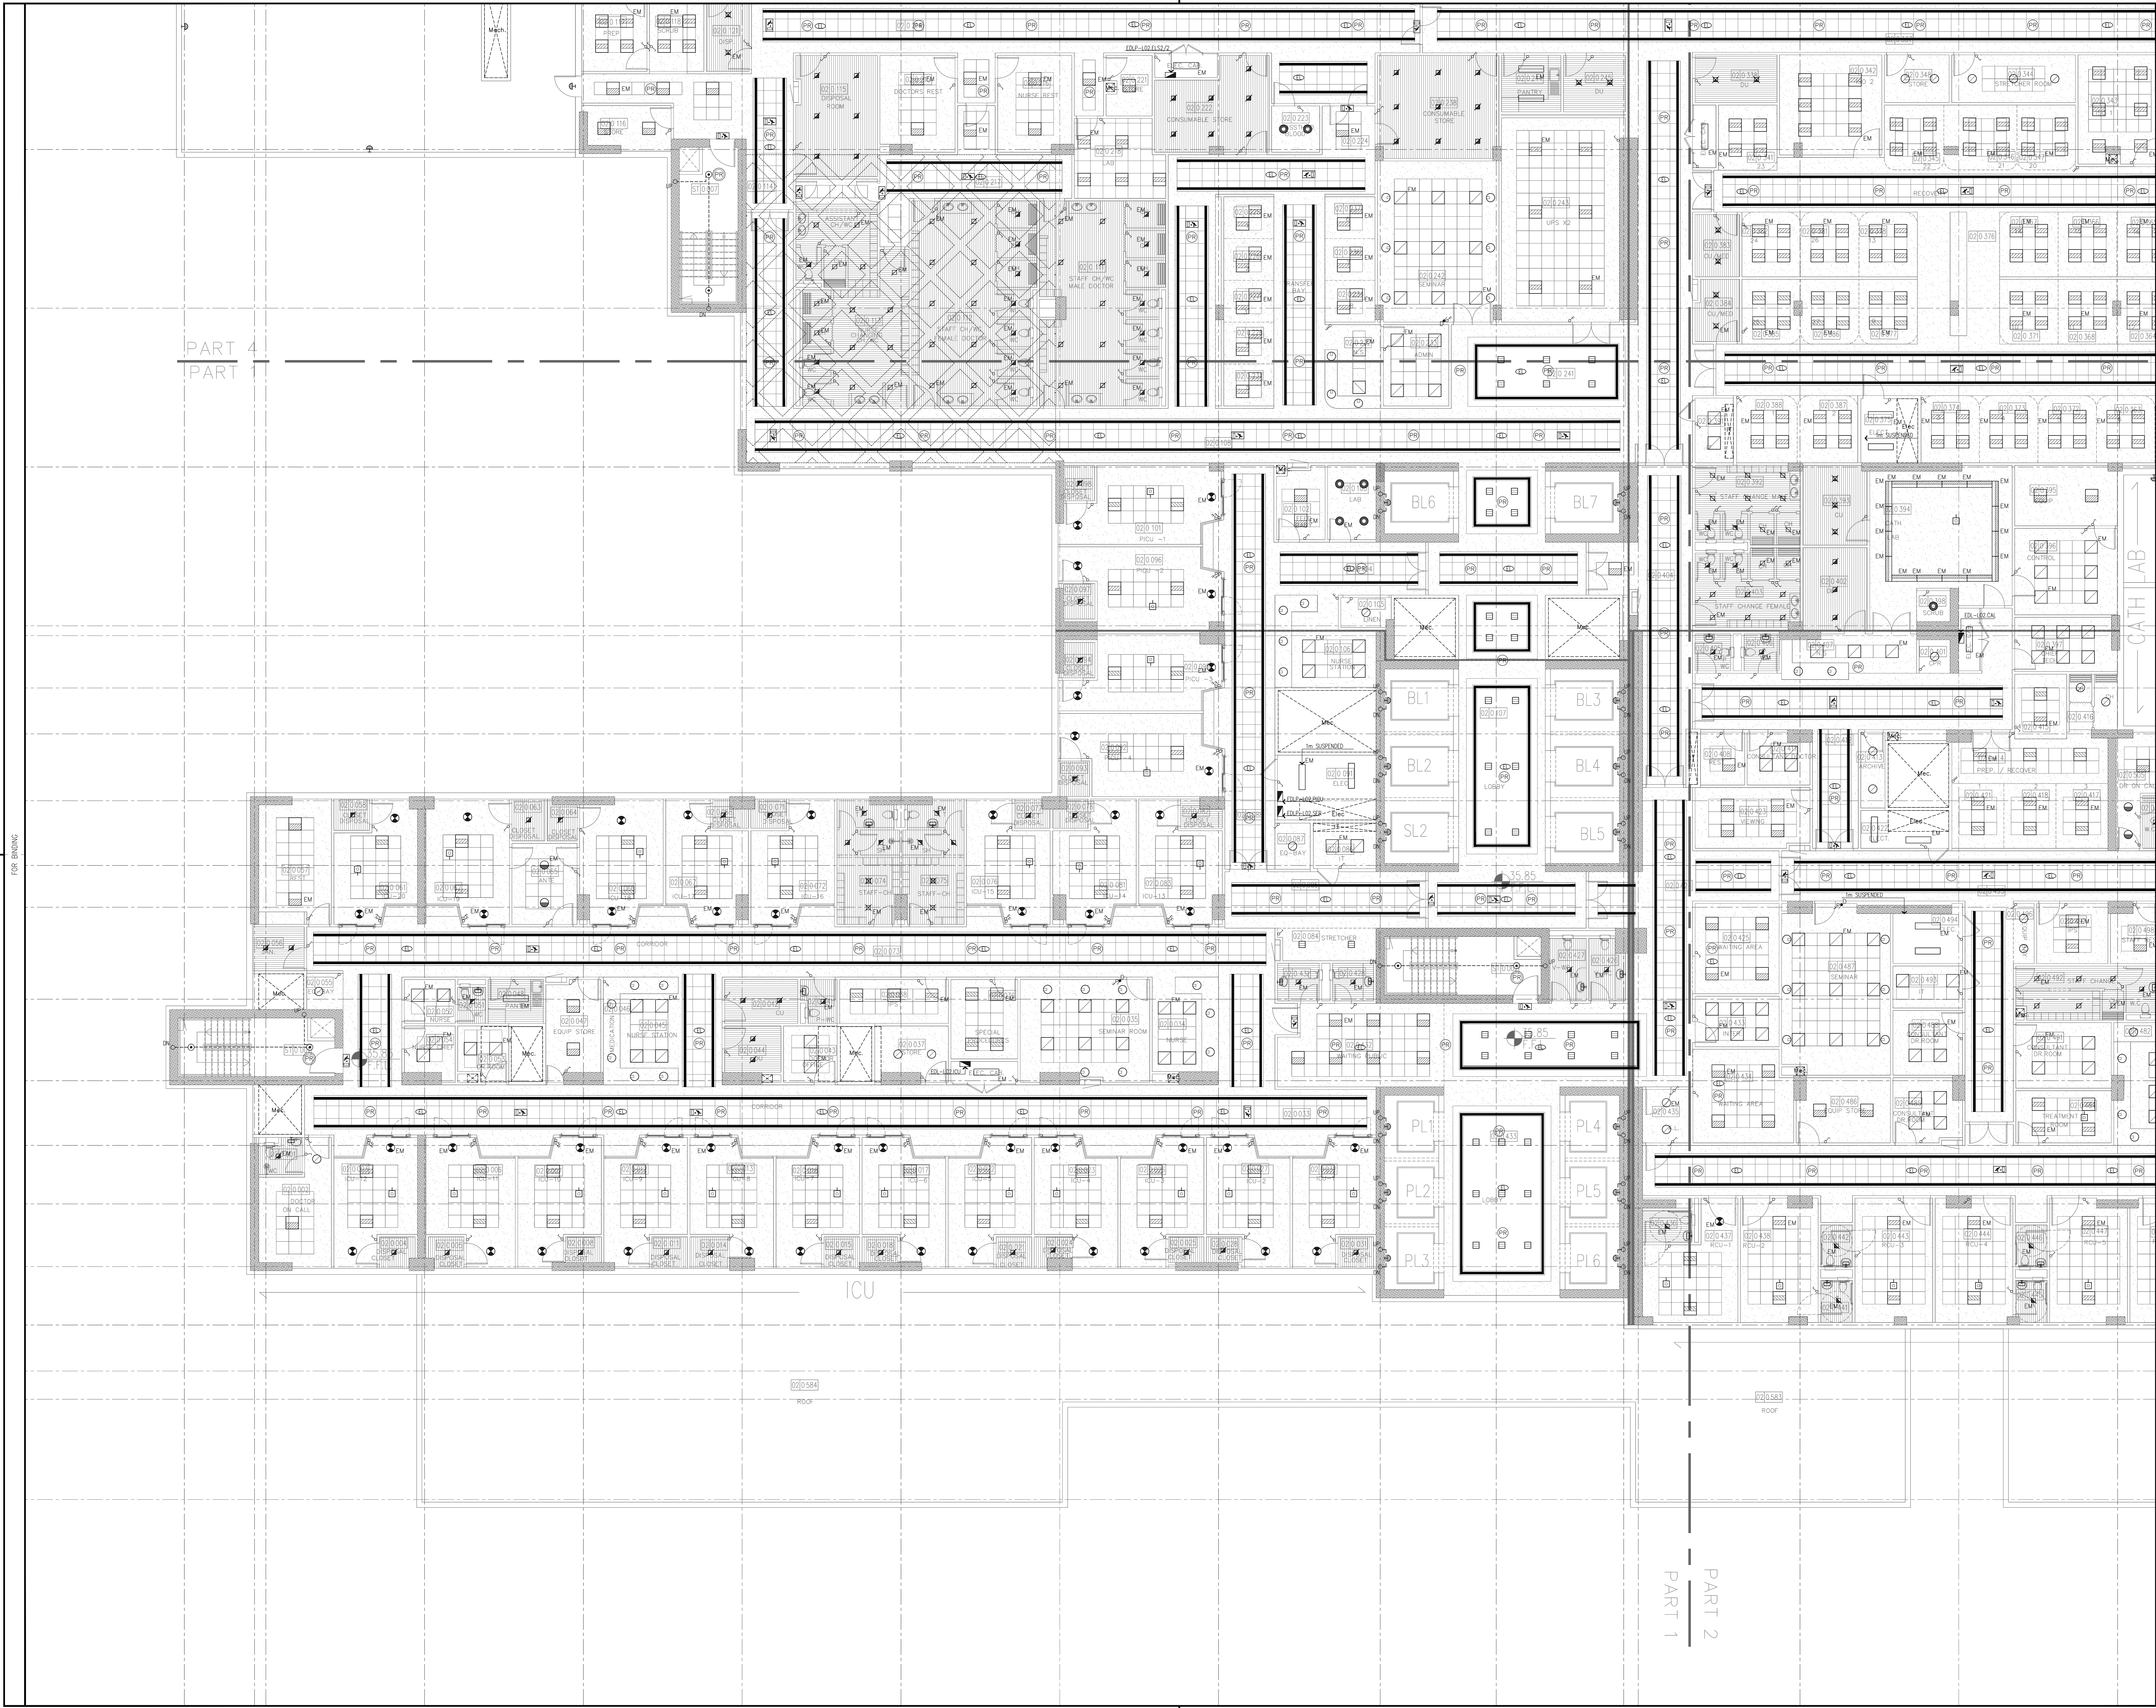

General Notes :

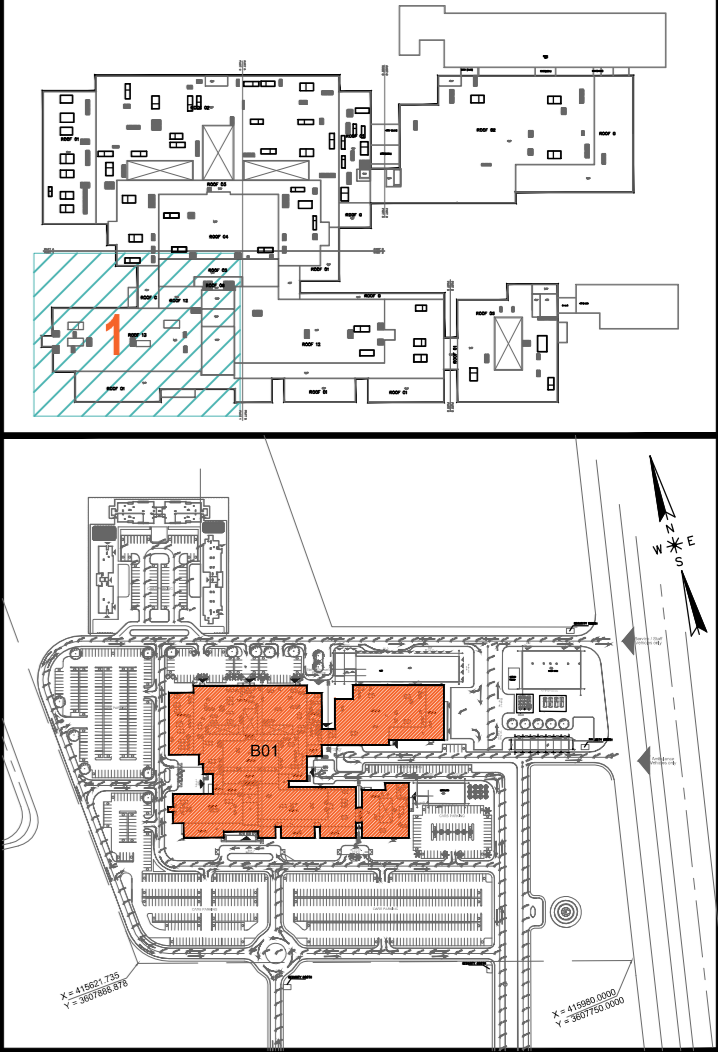

OWNER:
MINISTRY OF HIGHER EDUCATION
AND SCIENTIFIC RESEARCH
University Of Karbala



PROJECT MANAGEMENT CONSULTANT:
AM TECH

MAIN CONTRACTOR:
FOURTH DIMENSION
Consulting Engineering & Construction

PRINCIPAL ENGINEERING CONSULTANT:
ARABTECH JARDANEH

CONSULTING HEALTH PLANNERS:
HDP healthcare designers
and project managers

CONSULTING INTERNATIONAL ARCHITECTS:
LEO A DALY
PLANNING ARCHITECTURE ENGINEERING INTERIORS

THIS DRAWING IS THE
COPYRIGHT OF ARABTECH
JARDANEH ENGINEERS &
ARCHITECTS AND MUST NOT BE
REPRODUCED, COPIED OR USED
WITHOUT THE CONSULTANTS
AUTHORIZATION

REV.	DESCRIPTION	APPRO. BY	DATE

DRAWN BY: E.D. DESIGNED BY: H.O.M/SH
CHECKED BY: M.K.H. APPROVED BY: F.J
QC REVIEW BY: B.M. DWG ISSUE DATE: 26.10.2014


PROJECT:
**KARBALA 600 BED TEACHING
UNIVERSITY HOSPITAL, IRAQ**

CONCEPT DESIGN STAGE	PRELIMINARY DESIGN STAGE
DESIGN DEVELOPMENT STAGE	CONSTRUCTION DRAWINGS STAGE



DRAWING TITLE:

**SECOND FLOOR PLAN
LIGHTING LAYOUT
PART 1**

A01 01586 DWG KUH-EL-116 BLOCK B01
1:100 1/4 (A0) Sh. 01 of 06 REV. RO

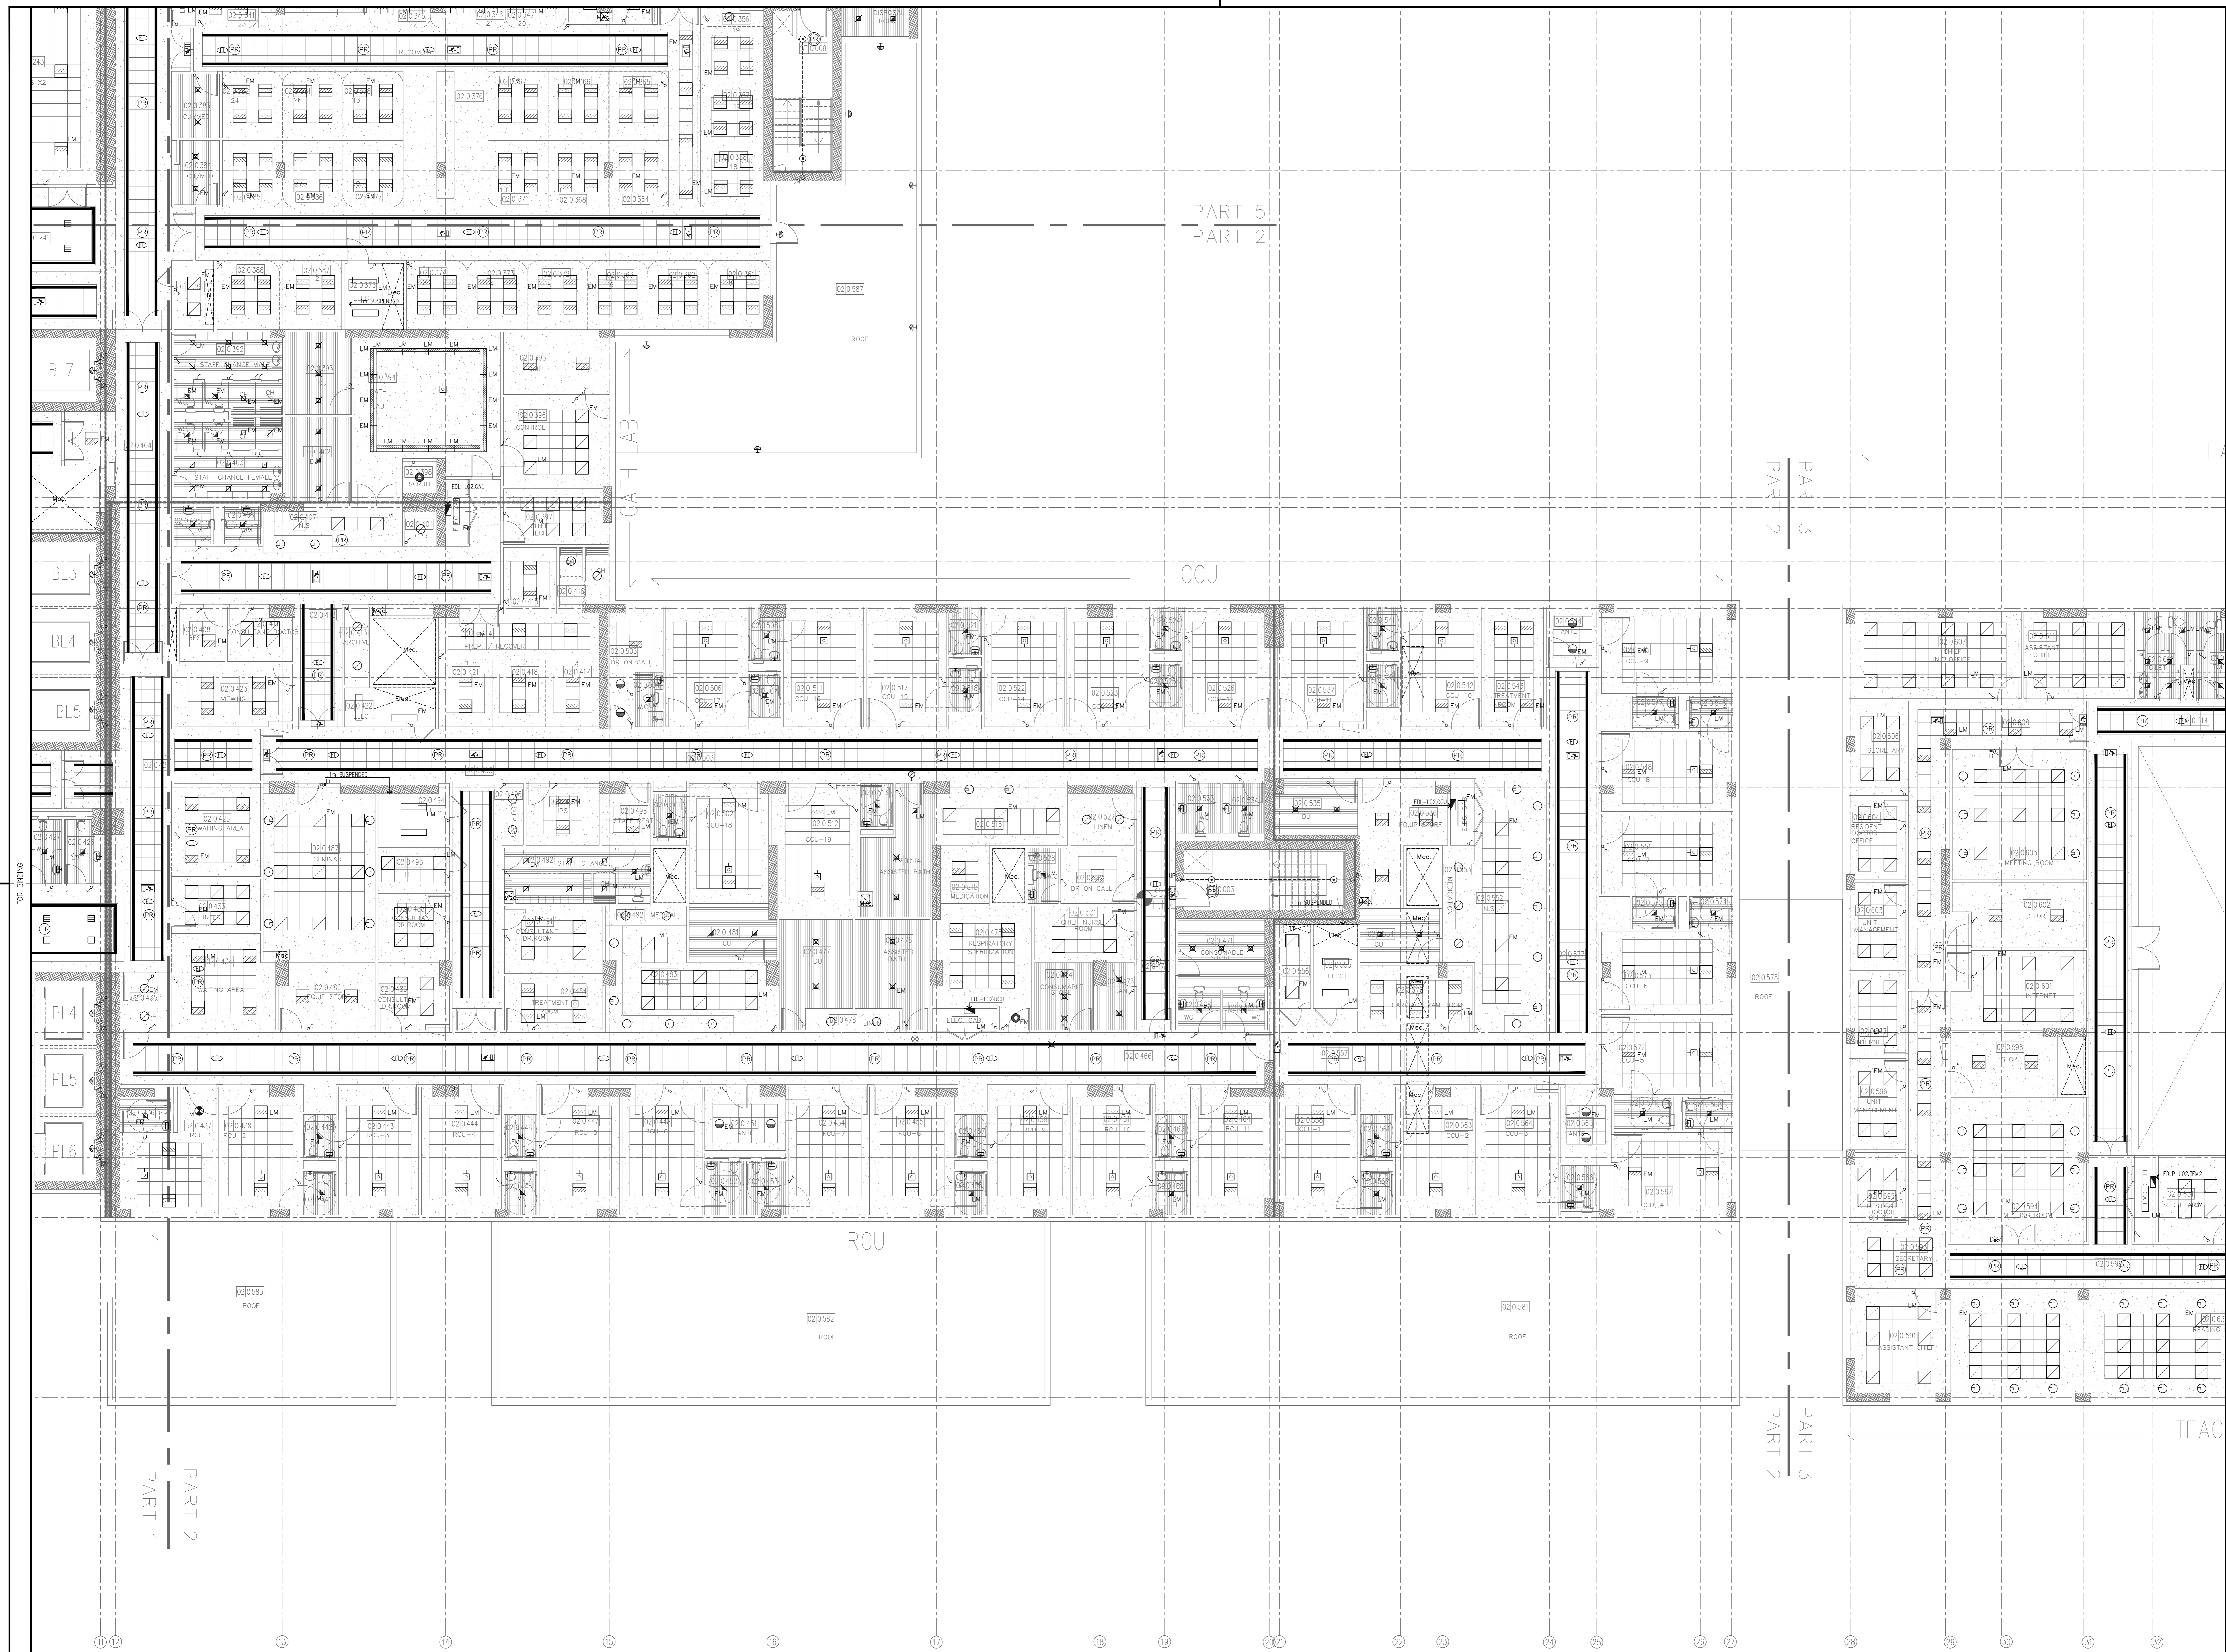

General Notes :

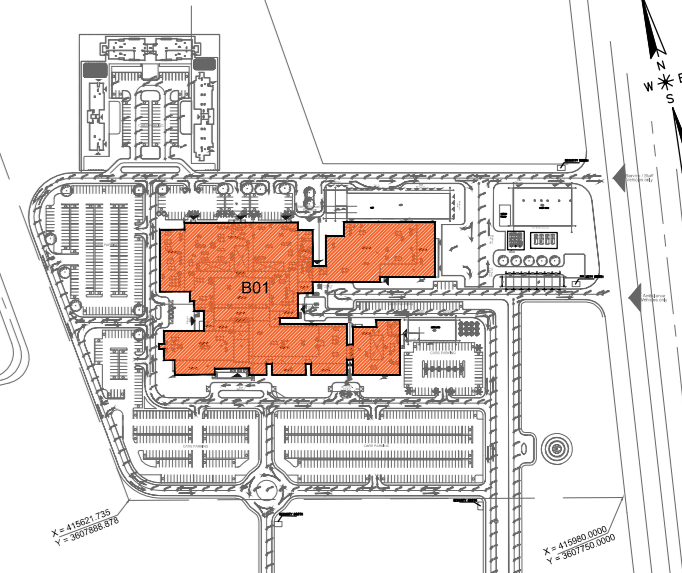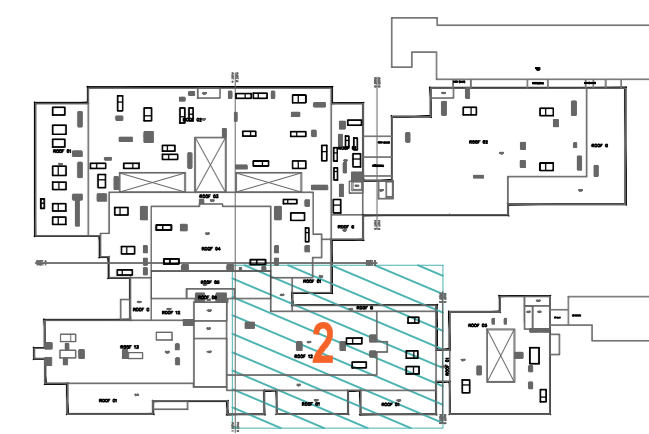

OWNER :
MINISTRY OF HIGHER EDUCATION
AND SCIENTIFIC RESEARCH
University OF Karbala



PROJECT MANAGEMENT CONSULTANT



MAIN Contractor



PRINCIPAL ENGINEERING CONSULTANT

ARABTECH JARDANEH

HDP | healthcare designers
and project managers

CONSULTING INTERNATIONAL ARCHITECTS :
LEO A DALY PLANNING ARCHITECTURE ENGINEERING INTERIOR

THIS DRAWING IS THE
COPYRIGHT OF ARABTECH
JARDANEH ENGINEERS &
ARCHITECTS AND MUST NOT BE
RETAINED, COPIED OR USED
WITHOUT THE CONSULTANTS'
AUTHORIZATION

[illegible]

DRAWN BY:	E.D	DESIGNED BY:	H.O/M.S.
CHECKED BY:	M.KH	APPROVED BY:	F.J
QC REVIEW BY:	B.M	DWG ISSUE DATE: 26.10.2	


PROJECT:
KARBALA 600 BED TEACHING
UNIVERSITY HOSPITAL, IRAQ

CONCEPT DESIGN STAGE	PRELIMINARY DESIGN STAGE
DESIGN DEVELOPMENT STAGE	CONSTRUCTION DRAWINGS STAGE

DRAWING TITLE:

SECOND FLOOR PLAN
LIGHTING LAYOUT
PART 2

JOB #	01586	DWG KUHL-EL-117	BLOCK #	BO
1:100	⊗ (AO)	Sht. 02 of 06	REV. #	RC

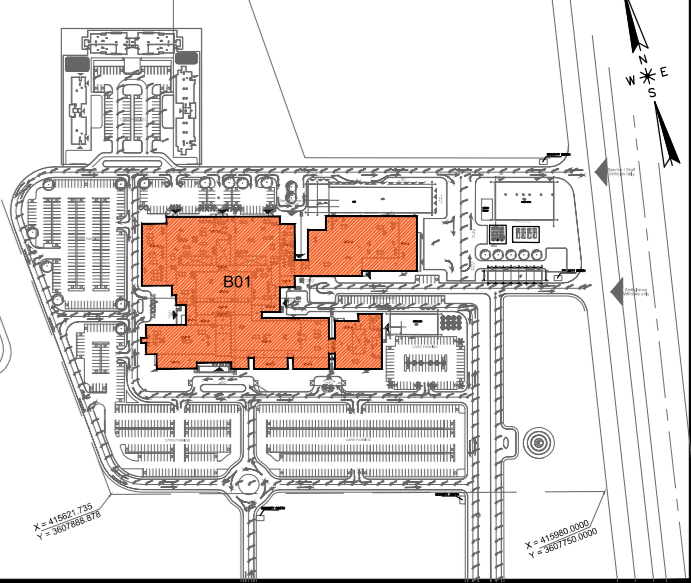

MAIN Contractor :  

HDP | healthcare designers
and project managers

CONSULTING INTERNATIONAL ARCHITECTS :
LEO A DALY PLANNING ARCHITECTURE ENGINEERING INTERIORS

THIS DRAWING IS THE
COPYRIGHT OF ARABTECH
JARDANEH ENGINEERS &
ARCHITECTS AND MUST NOT BE
RETAINED, COPIED OR USED
WITHOUT THE CONSULTANTS'
AUTHORIZATION

[illegible]

DRAWN BY:	E.D	DESIGNED BY:	H.O/M.SH
CHECKED BY:	M.KH	APPROVED BY:	F.J
QC REVIEW BY:	B.M	DWG ISSUE DATE: 26.10.2014	


PROJECT:
**KARBALA 600 BED TEACHING
UNIVERSITY HOSPITAL, IRAQ**

CONCEPT DESIGN STAGE	PRELIMINARY DESIGN STAGE
DESIGN DEVELOPMENT STAGE	CONSTRUCTION DRAWINGS STAGE



DRAWING TITLE:

SECOND FLOOR PLAN LIGHTING LAYOUT PART 3

01586	DWG KUH-EL-118	BLOCK * B01
1:100 @ (A0)	Sheet 03 of 06	REV. * R0

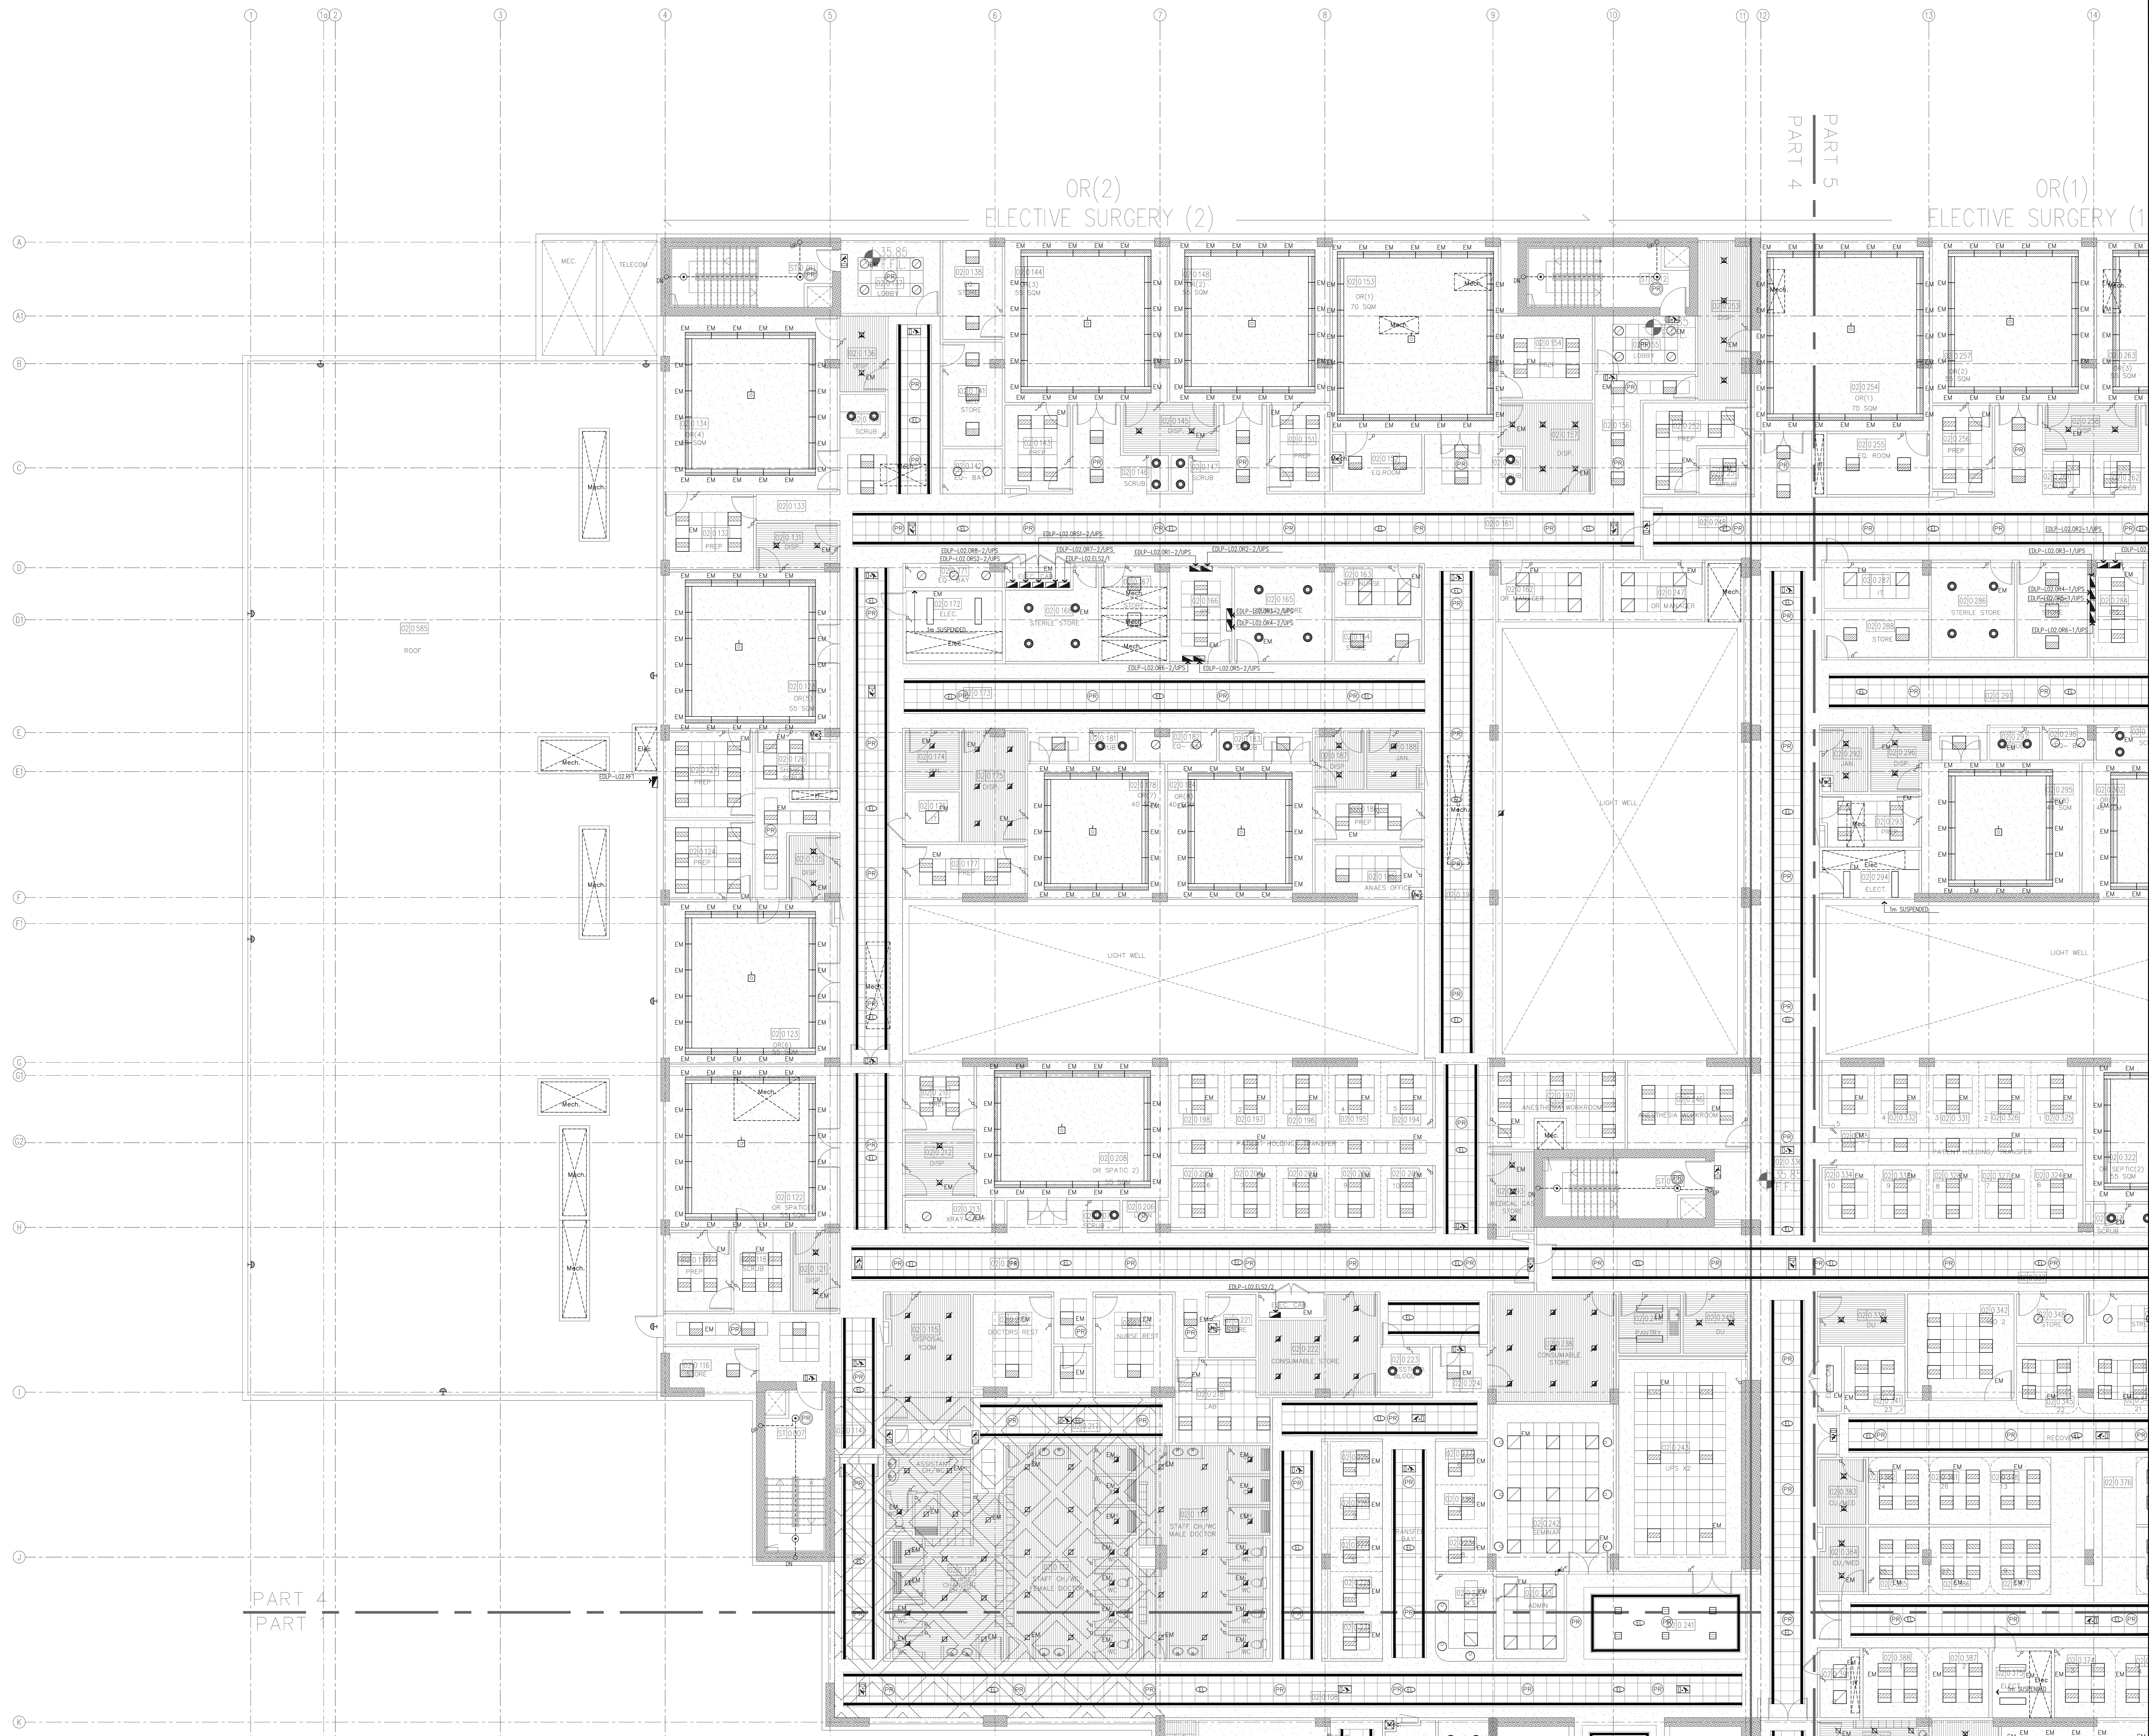

General Notes :

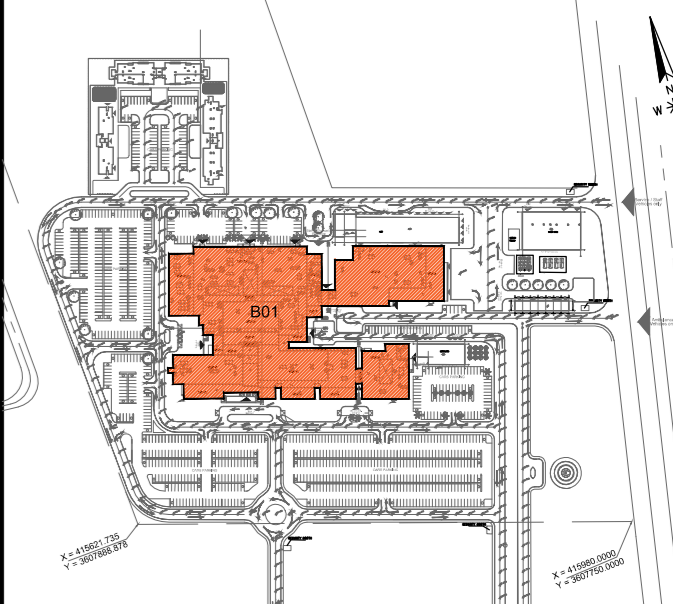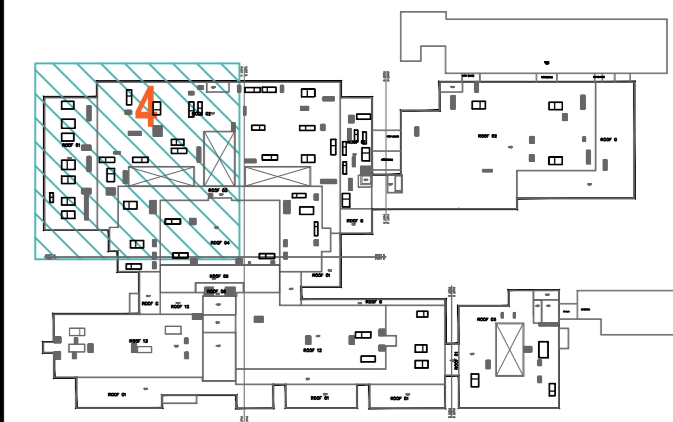

MINISTRY OF HIGHER EDUCATION
AND SCIENTIFIC RESEARCH
University Of Karbala



PROJECT MANAGEMENT CONSULTANT
AM TECH

MAIN CONTRACTOR
FOURTH DIMENSION
Consulting Engineering & Construction

PRINCIPAL ENGINEERING CONSULTANT
ARABTECH JARDANEH

CONSULTING HEALTH PLANNERS
HDP healthcare designers
and project managers

CONSULTING INTERNATIONAL ARCHITECTS
LEO A DALY
PLANNING ARCHITECTURE ENGINEERING INTERIORS

THIS DRAWING IS THE
COPYRIGHT OF ARABTECH
JARDANEH ENGINEERS &
ARCHITECTS AND MUST NOT BE
REPRODUCED, COPIED OR USED
WITHOUT THE CONSULTANTS
AUTHORIZATION

REV.	DESCRIPTION	APPRO. BY	DATE
1			
2			
3			
100			

DRAWN BY: E.D. DESIGNED BY: H.O.M.S.H.
CHECKED BY: M.M.H. APPROVED BY: F.J.
QC REVIEW BY: B.M. DWG ISSUE DATE: 26.10.2014


PROJECT:
**KARBALA 600 BED TEACHING
UNIVERSITY HOSPITAL, IRAQ**

CONCEPT DESIGN STAGE
PRELIMINARY DESIGN STAGE
DESIGN DEVELOPMENT STAGE
CONSTRUCTION DRAWINGS STAGE

DRAWING TITLE:

**SECOND FLOOR PLAN
LIGHTING LAYOUT
PART 4**

JOB # 01586 DWG KUH-EL-119 BLOCK B01
1:100 @ A0 Shr. 04 of 06 REV. R0

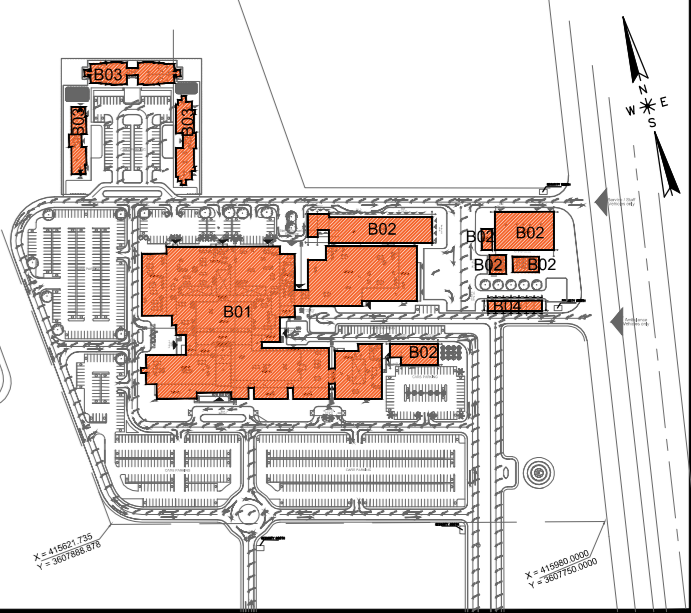

CONSULTING HEALTH PLANNERS :

HDP | healthcare designers
and project managers

CONSULTING INTERNATIONAL ARCHITECTS :
LEO A DALY PLANNING ARCHITECTURE ENGINEERING INTERIORS

[illegible]


PROJECT:
KARBALA 600 BED TEACHING
UNIVERSITY HOSPITAL, IRAQ

CONCEPT DESIGN STAGE	PRELIMINARY DESIGN STAGE
DESIGN DEVELOPMENT STAGE	CONSTRUCTION DRAWINGS STAGE

DRAWING TITLE:


THIRD FLOOR PLAN
LIGHTING LAYOUT
OVERALL

01586	DWG KUH-EL-122	BLOCK * B01
1:250 @ (A0)	Sheet 01 of 01	REV. * R0

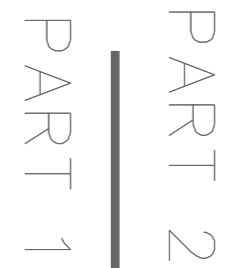


01586	DWG KUH-EL-123	BLOCK * B01
1:100 @ (A0)	Sheet 01 of 06	REV. * R0

01586	DWG KUH-EL-123	BLOCK * B01
1:100 @ (A0)	Sheet 01 of 06	REV. * R0

 

CAD FILE NAME: 01586-EL-124-B01-R0.DWG

CAD FILE NAME: 01586-EL-124-B01-R0.DWG

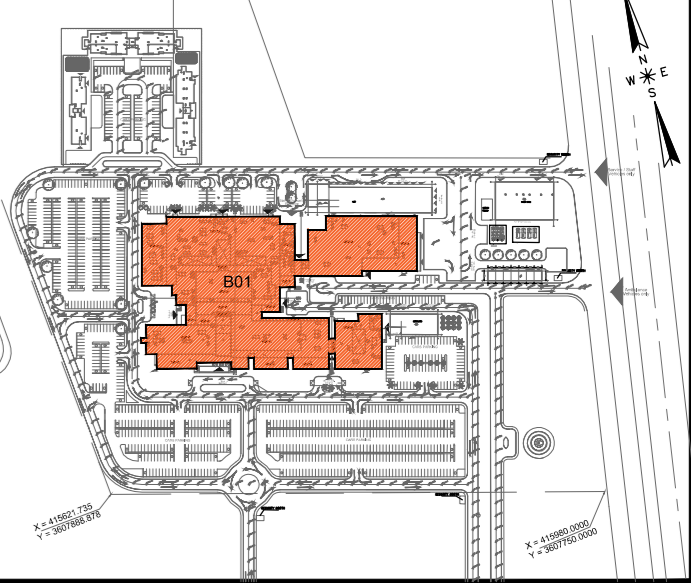

ARABTECH JARDANEH

HDP | healthcare designers
and project managers


LEO A DALY PLANNING ARCHITECTURE ENGINEERING INTERIORS

[illegible]



PROJECT:
KARBALA 600 BED TEACHING
UNIVERSITY HOSPITAL, IRAQ

DRAWING TITLE:

DB	01586	DWG	KUH-EL-125	BLOCK	B01
				REV.	R0
	1:100	⊗ (AO)	Sht. 03 of 06		

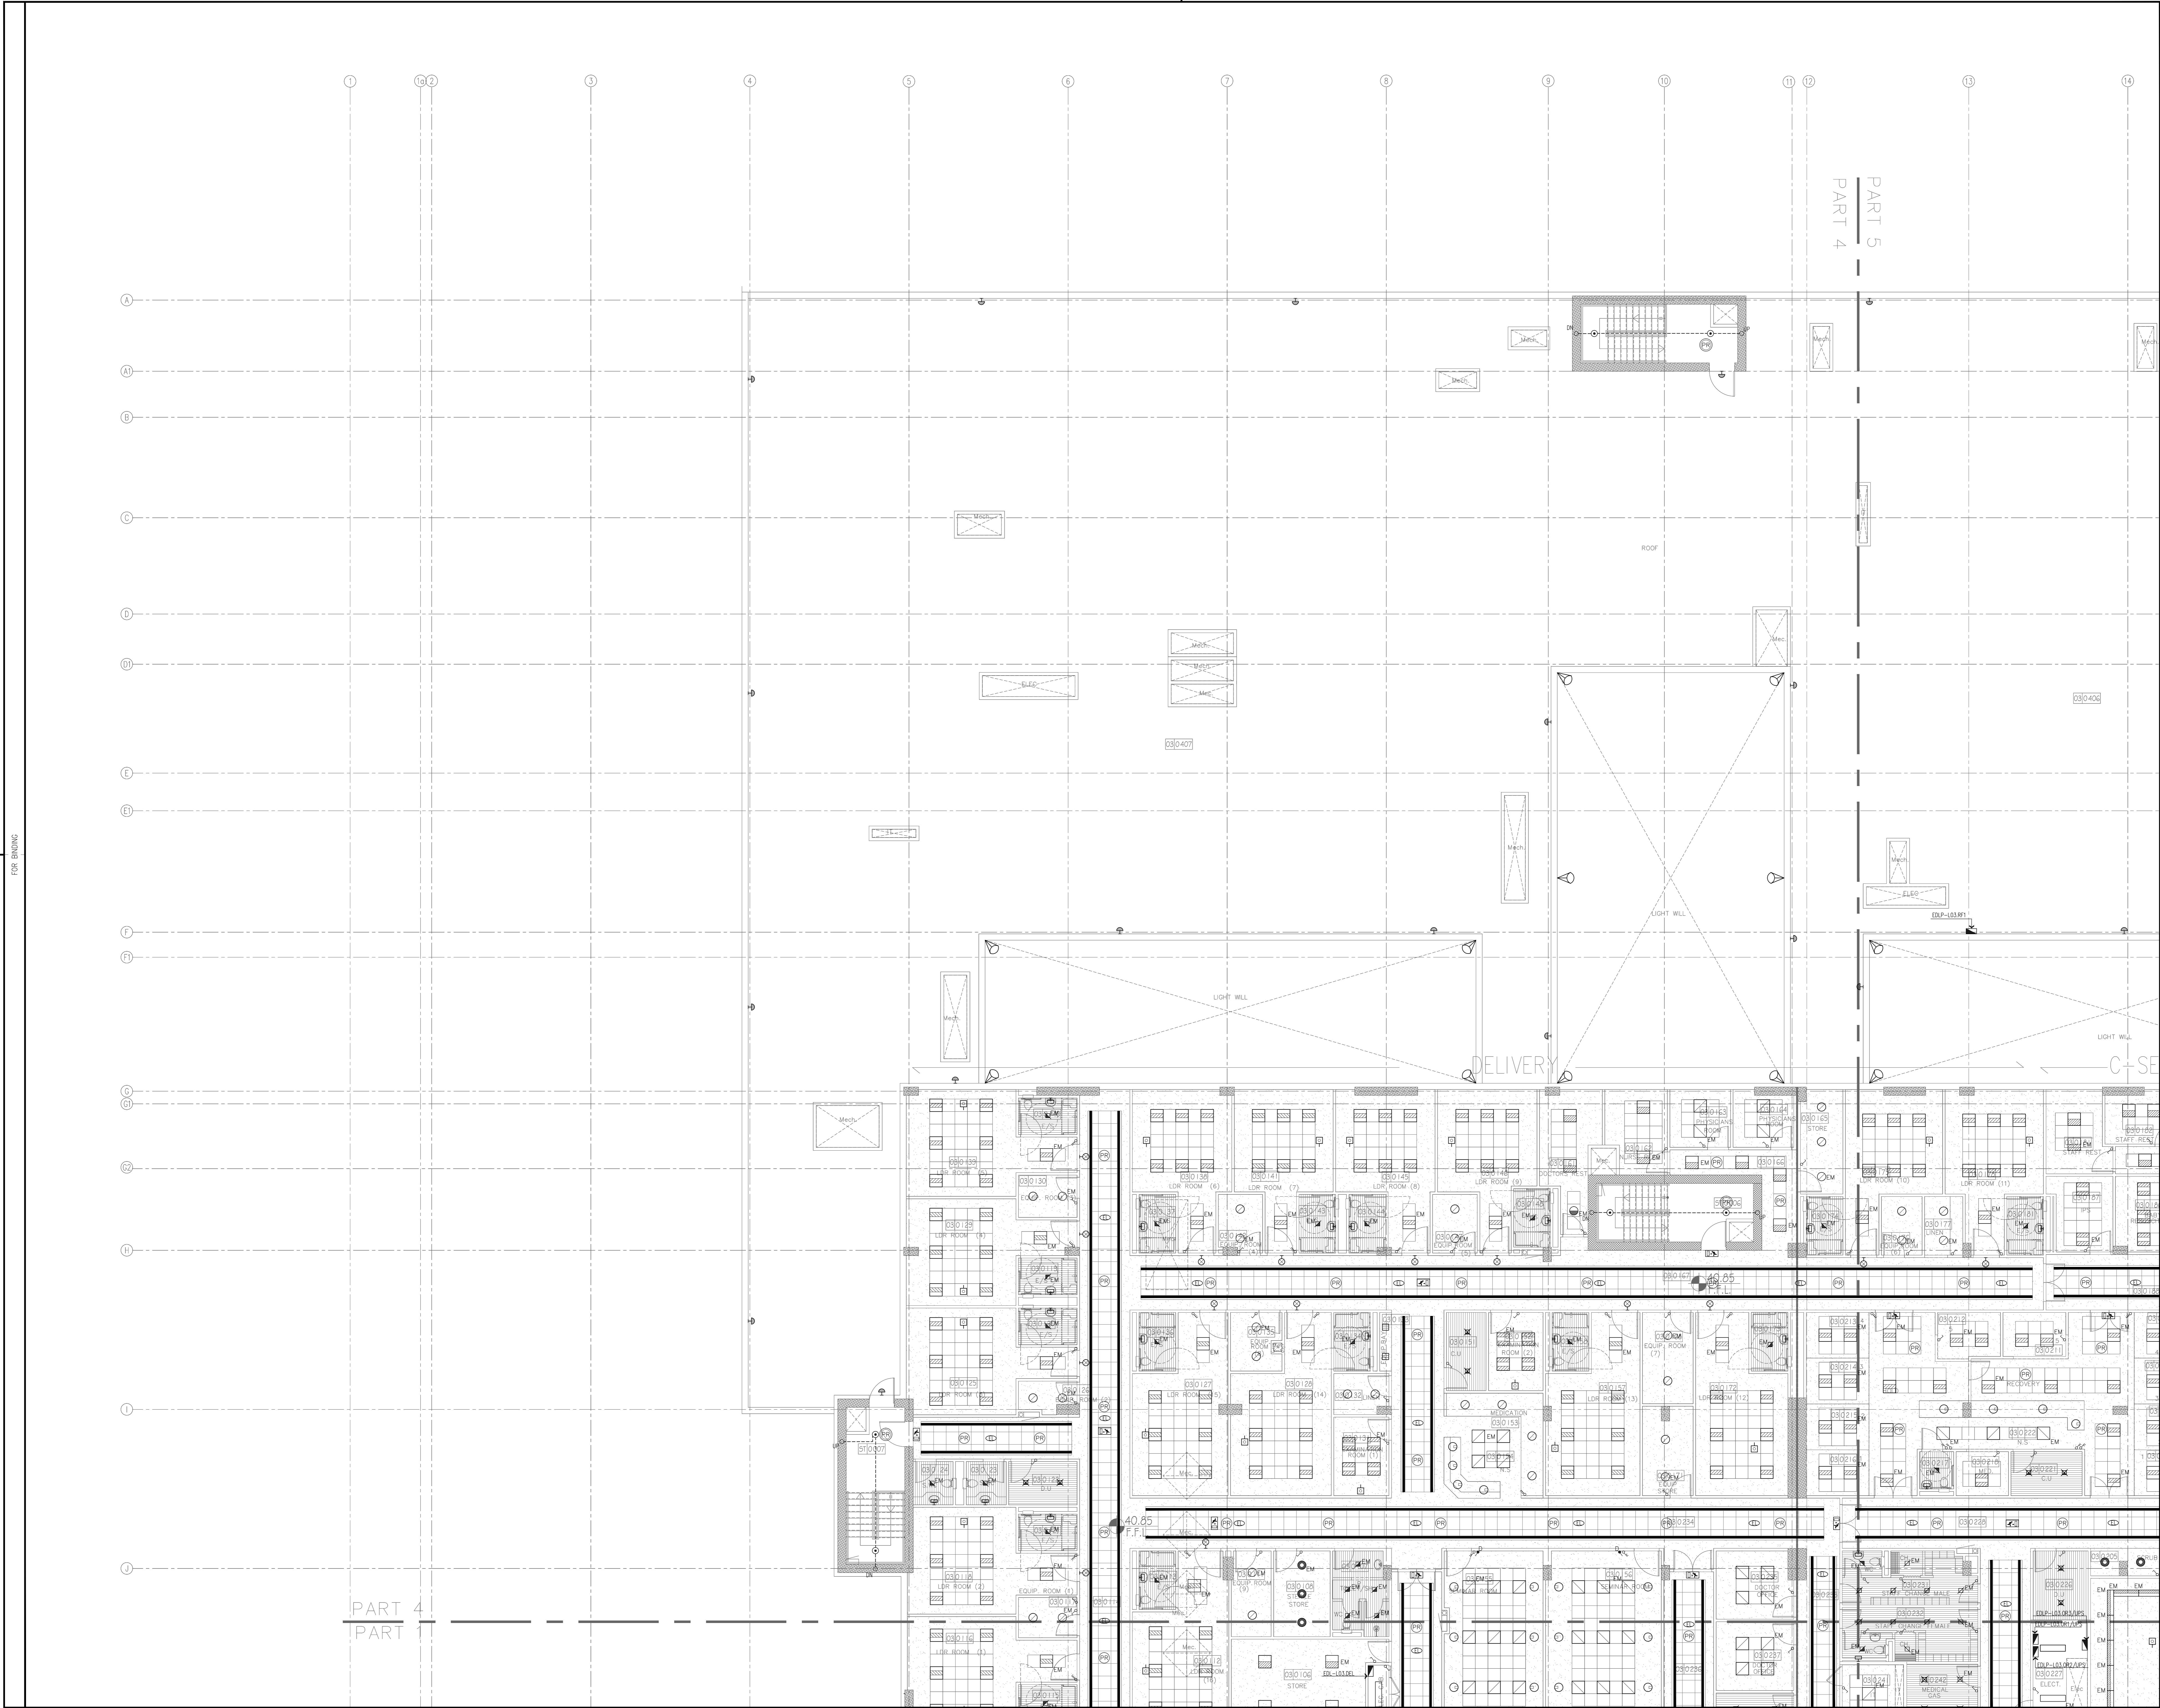

General Notes :

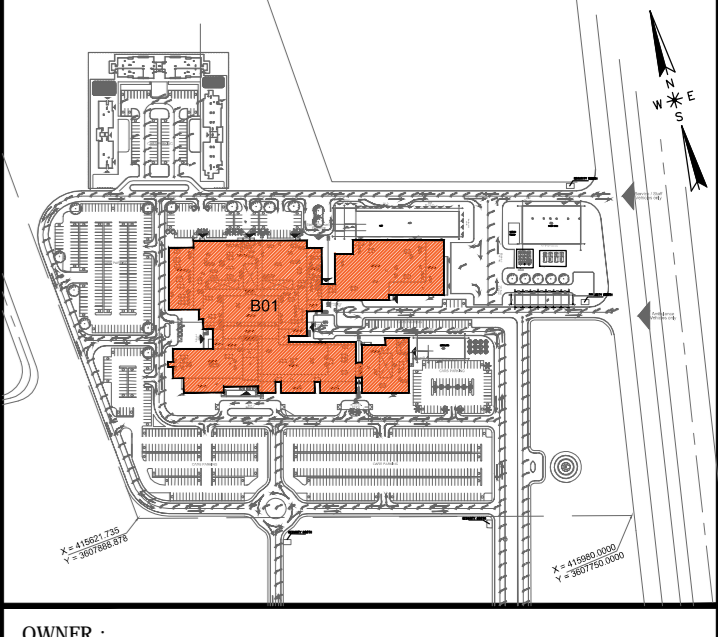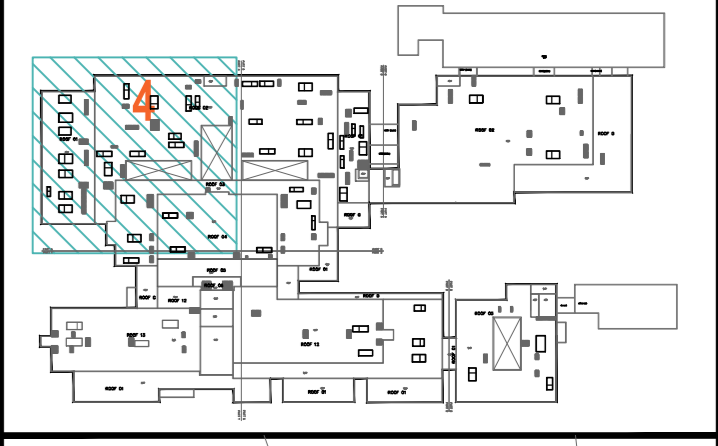

PRINER:
MINISTRY OF HIGHER EDUCATION
AND SCIENTIFIC RESEARCH
University Of Karbala



PROJECT MANAGEMENT CONSULTANT:
AM TECH

MAIN Contractor :
FOURTH DIMENSION
Consulting Engineering & Construction

PRINCIPAL ENGINEERING CONSULTANT:
ARABTECH JARDANEH

CONSULTING HEALTH PLANNERS:
HDP healthcare designers
and project managers

CONSULTING INTERNATIONAL ARCHITECTS:
LEO A DALY
PLANNING ARCHITECTURE ENGINEERING INTERIORS

THIS DRAWING IS THE
COPYRIGHT OF ARABTECH
JARDANEH ENGINEERS &
ARCHITECTS AND MUST NOT BE
REPRODUCED, COPIED OR USED
WITHOUT THE CONSULTANTS'
AUTHORIZATION

REV.	DESCRIPTION	APPRO. BY	DATE
1			
2			
3			
100			

DRAWN BY: E.D. DESIGNED BY: H.O.M.S.H.
CHECKED BY: M.K.H. APPROVED BY: F.J.
QC REVIEW BY: B.M. DWG ISSUE DATE: 26.10.2014

PROJECT:
**KARBALA 600 BED TEACHING
UNIVERSITY HOSPITAL, IRAQ**

CONCEPT DESIGN STAGE
DESIGN DEVELOPMENT STAGE
PRELIMINARY DESIGN STAGE
CONSTRUCTION DRAWINGS STAGE

DRAWING TITLE:
**THIRD FLOOR PLAN
LIGHTING LAYOUT
PART 4**

A01 01586 DWG KUH-EL-126 BLOCK B01
1:100 04 of 06 REV R0

FOR BUILDING



MAIN Contractor :



FOURTH DIMENSION
Contracting Engineering procurement



C.B.C

CONSULTING HEALTH PLANNERS :

HDP | healthcare designers
and project managers


THIS DRAWING IS THE
COPYRIGHT OF ARABTECH
JARDANEH ENGINEERS &
ARCHITECTS AND MUST NOT BE
RETAINED, COPIED OR USED
WITHOUT THE CONSULTANTS'
AUTHORIZATION

[illegible]



PROJECT:
**KARBALA 600 BED TEACHING
UNIVERSITY HOSPITAL, IRAQ**

DRAWING TITLE:

01586	DWG KUH-EL-127	BLOCK * B01
1:100 @ (A0)	Sheet 05 of 06	REV. * R0

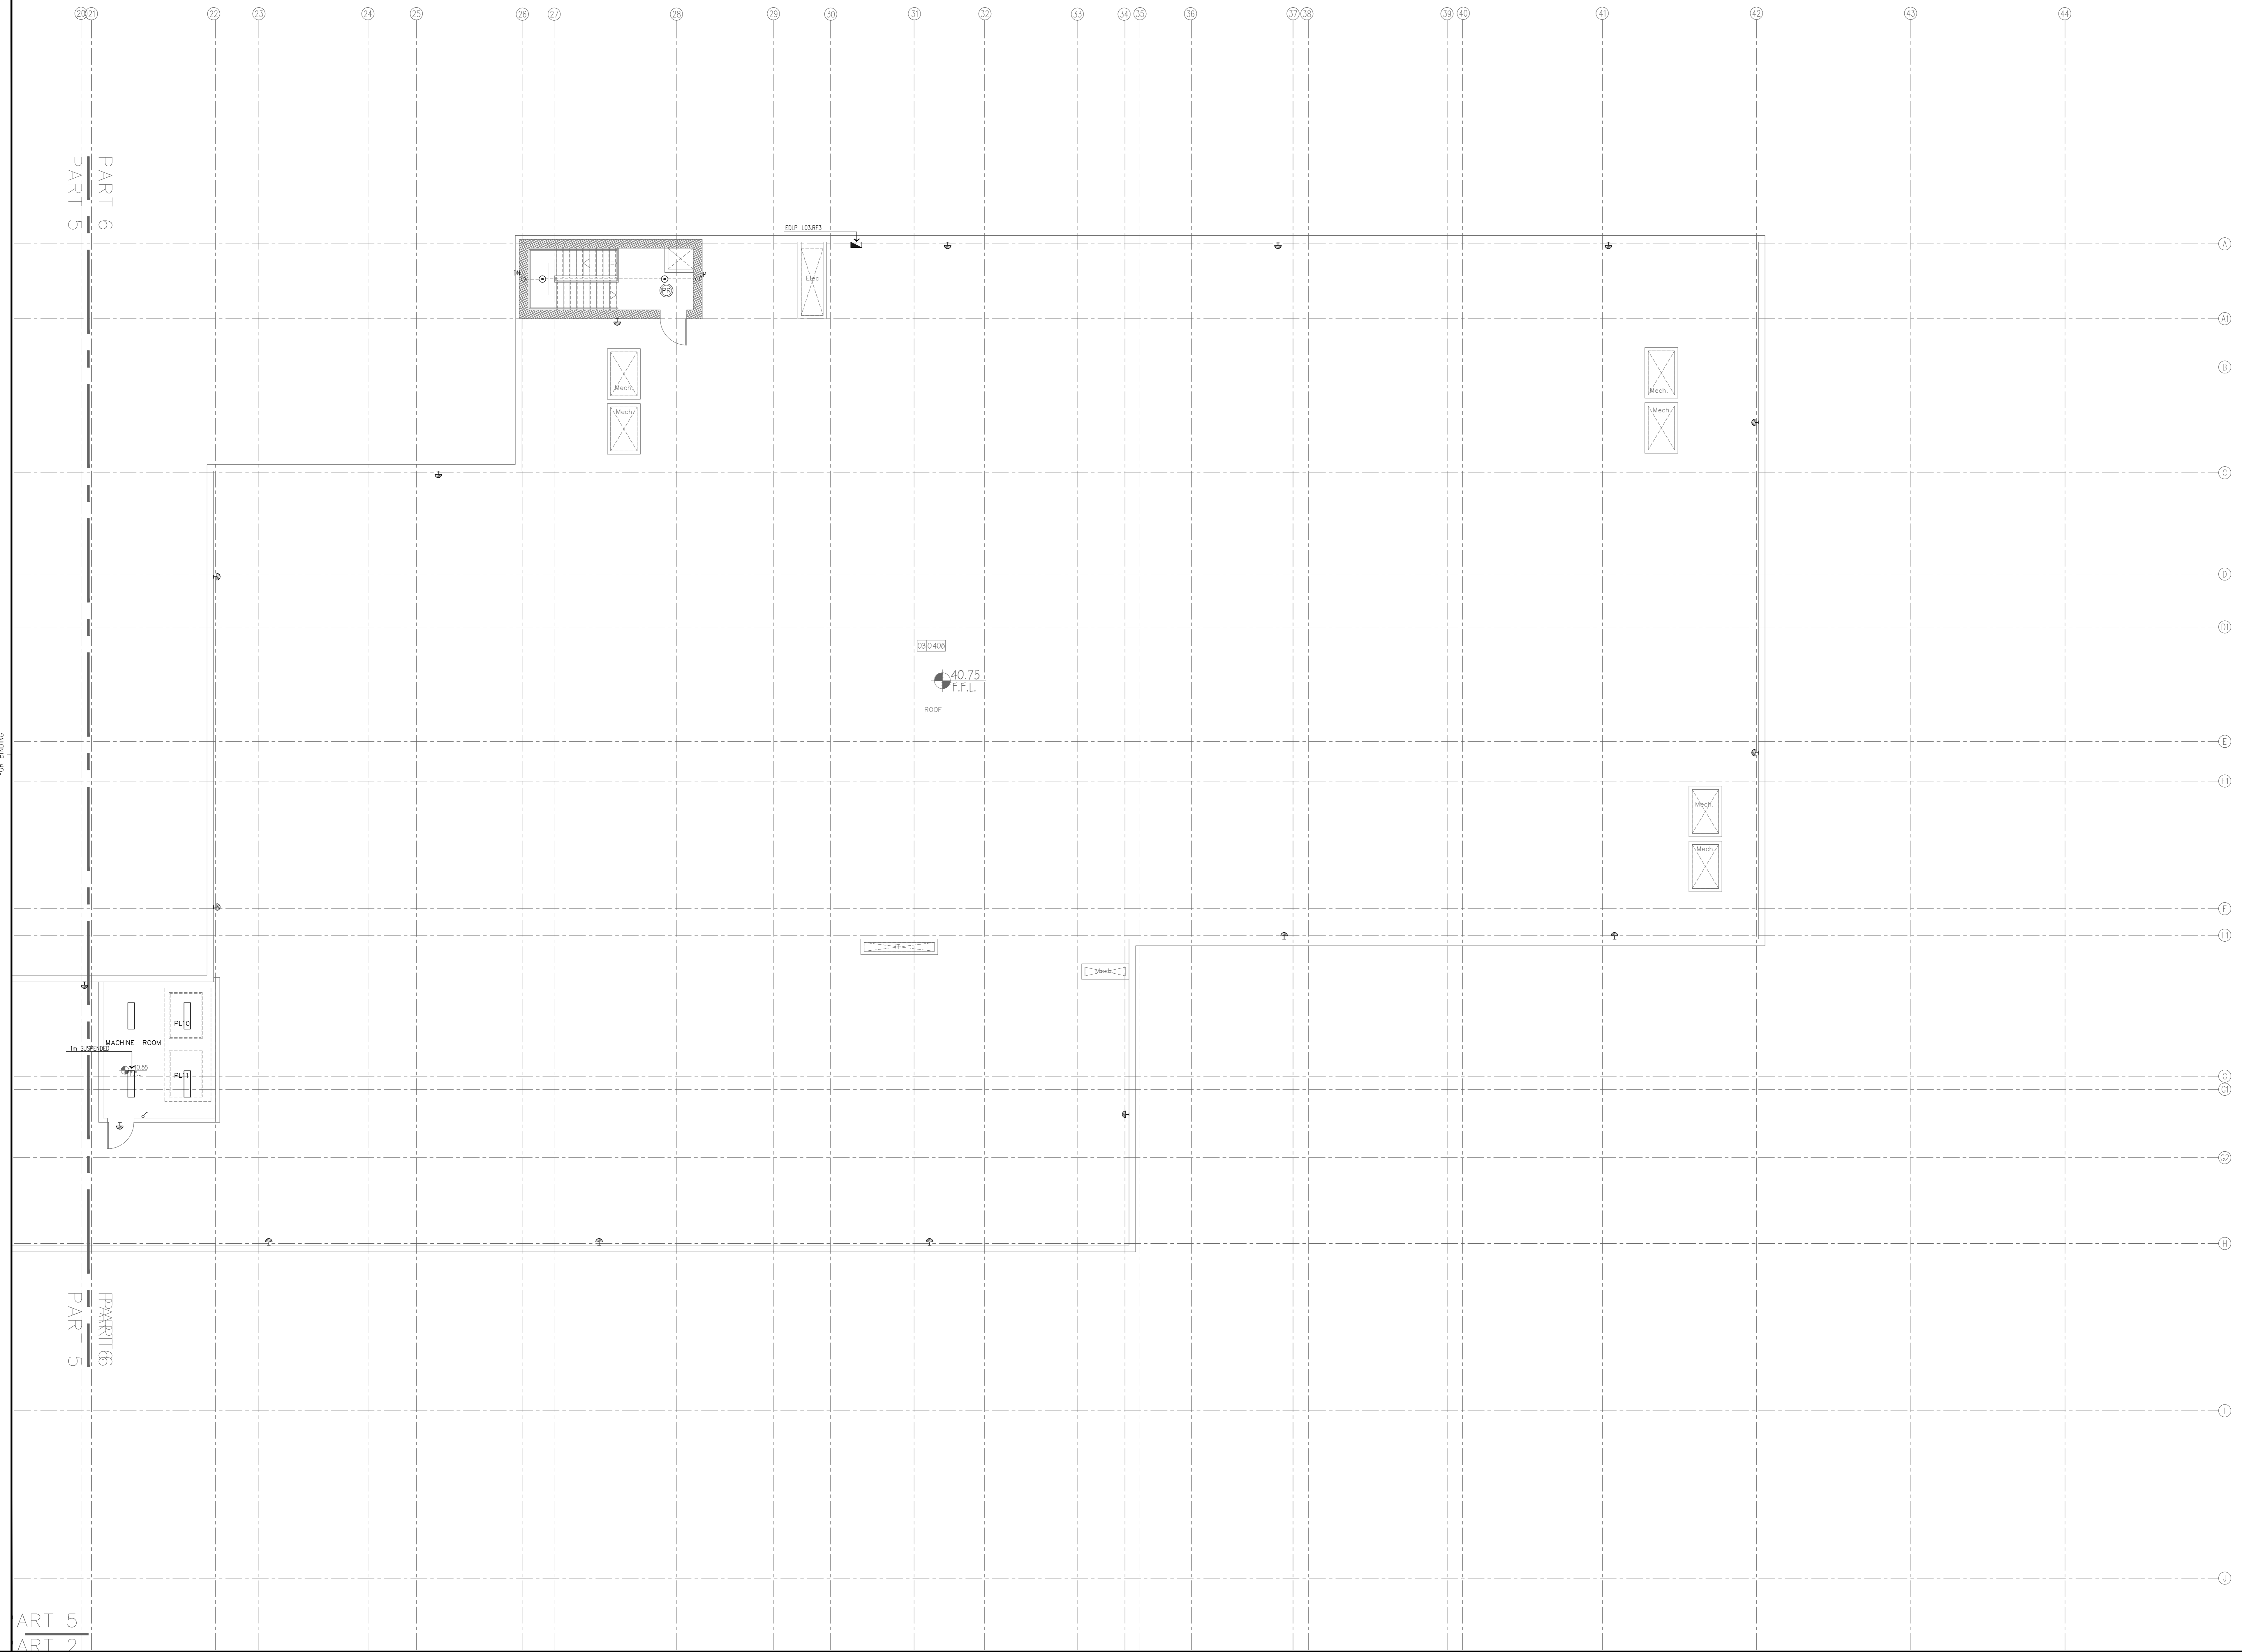

General Notes :

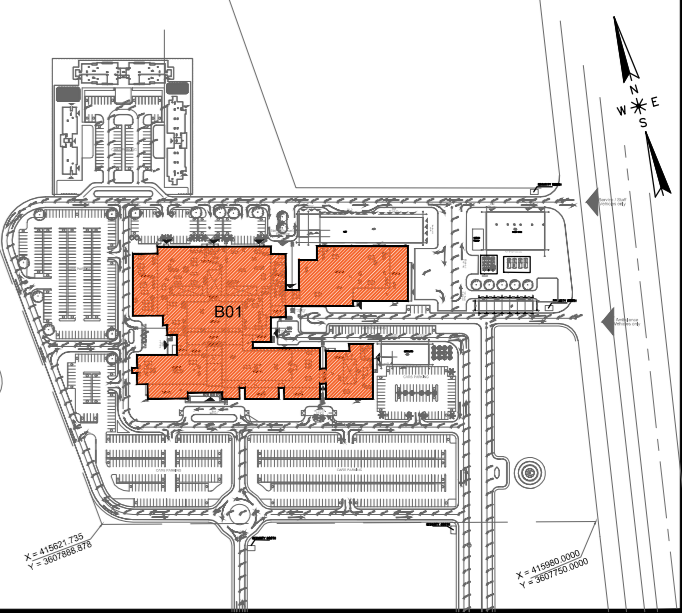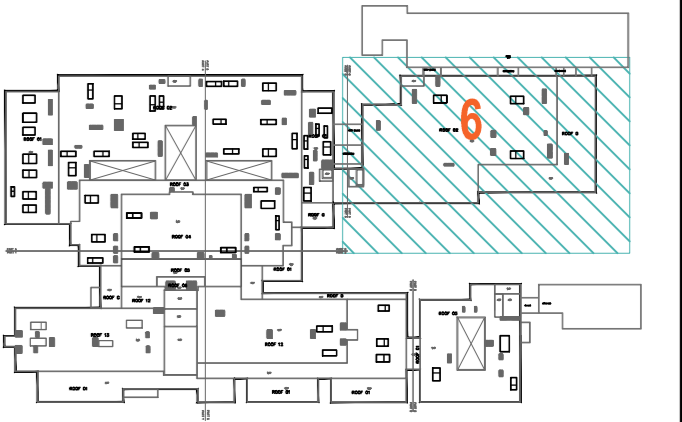

MINISTRY OF HIGHER EDUCATION
AND SCIENTIFIC RESEARCH
University OF Karbala



PROJECT MANAGEMENT CONSULTANT :



MAIN Contractor : _____



PRINCIPAL ENGINEERING CONSULTANT :

ARABTECH JARDANEH

CONSULTING HEALTH PLANNERS :

HDP | healthcare designers
and project managers

CONSULTING INTERNATIONAL ARCHITECTS :



THIS DRAWING IS THE
COPYRIGHT OF ARABTECH
JARDANEH ENGINEERS &
ARCHITECTS AND MUST NOT BE
RETAINED, COPIED OR USED
WITHOUT THE CONSULTANTS'
AUTHORIZATION

[illegible]

DRAWN BY:	E.D	DESIGNED BY:	H.O/M.SH
CHECKED BY:	M.KH	APPROVED BY:	F.J
QC REVIEW BY:	B.M	DWG ISSUE DATE: 26.10.2014	


PROJECT:
KARBALA 600 BED TEACHING
UNIVERSITY HOSPITAL, IRAQ

CONCEPT DESIGN STAGE	PRELIMINARY DESIGN STAGE
DESIGN DEVELOPMENT STAGE	CONSTRUCTION DRAWINGS STAGE

DRAWING TITLE:

THIRD FLOOR PLAN LIGHTING LAYOUT PART 6

01586	DWG KUH-EL-128	BLOCK *	B01
1:100 @ (A0)	Sheet 06 of 06	REV. *	R0

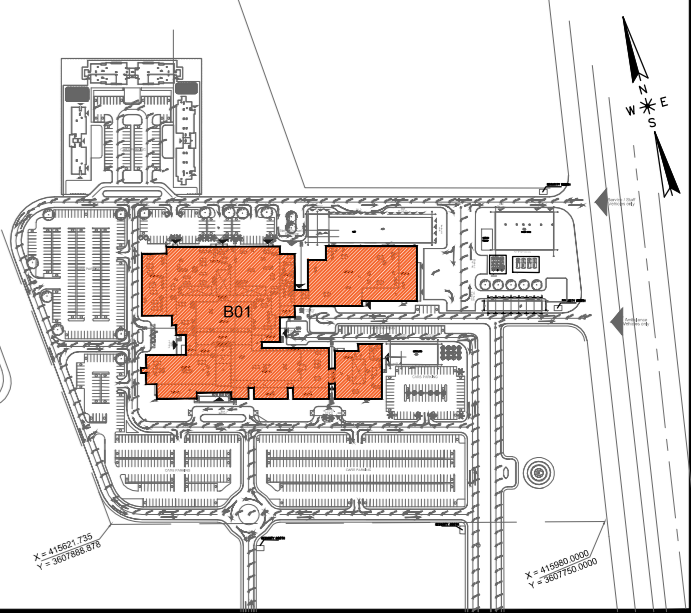

CONSULTING HEALTH PLANNERS :
HDP | healthcare designers
and project managers


THIS DRAWING IS THE
COPYRIGHT OF ARABTECH
JARDANEH ENGINEERS &
ARCHITECTS AND MUST NOT BE
RETAINED, COPIED OR USED
WITHOUT THE CONSULTANTS'
AUTHORIZATION

[illegible]



CONCEPT DESIGN STAGE	PRELIMINARY DESIGN STAGE
DESIGN DEVELOPMENT STAGE	CONSTRUCTION DRAWINGS STAGE

FOURTH FLOOR PLAN
LIGHTING LAYOUT
OVERALL

DB	01586	DWG	KUH-EL-129	BLOCK	B01
	1:250	Sh.	01 of 01	REV.	R0

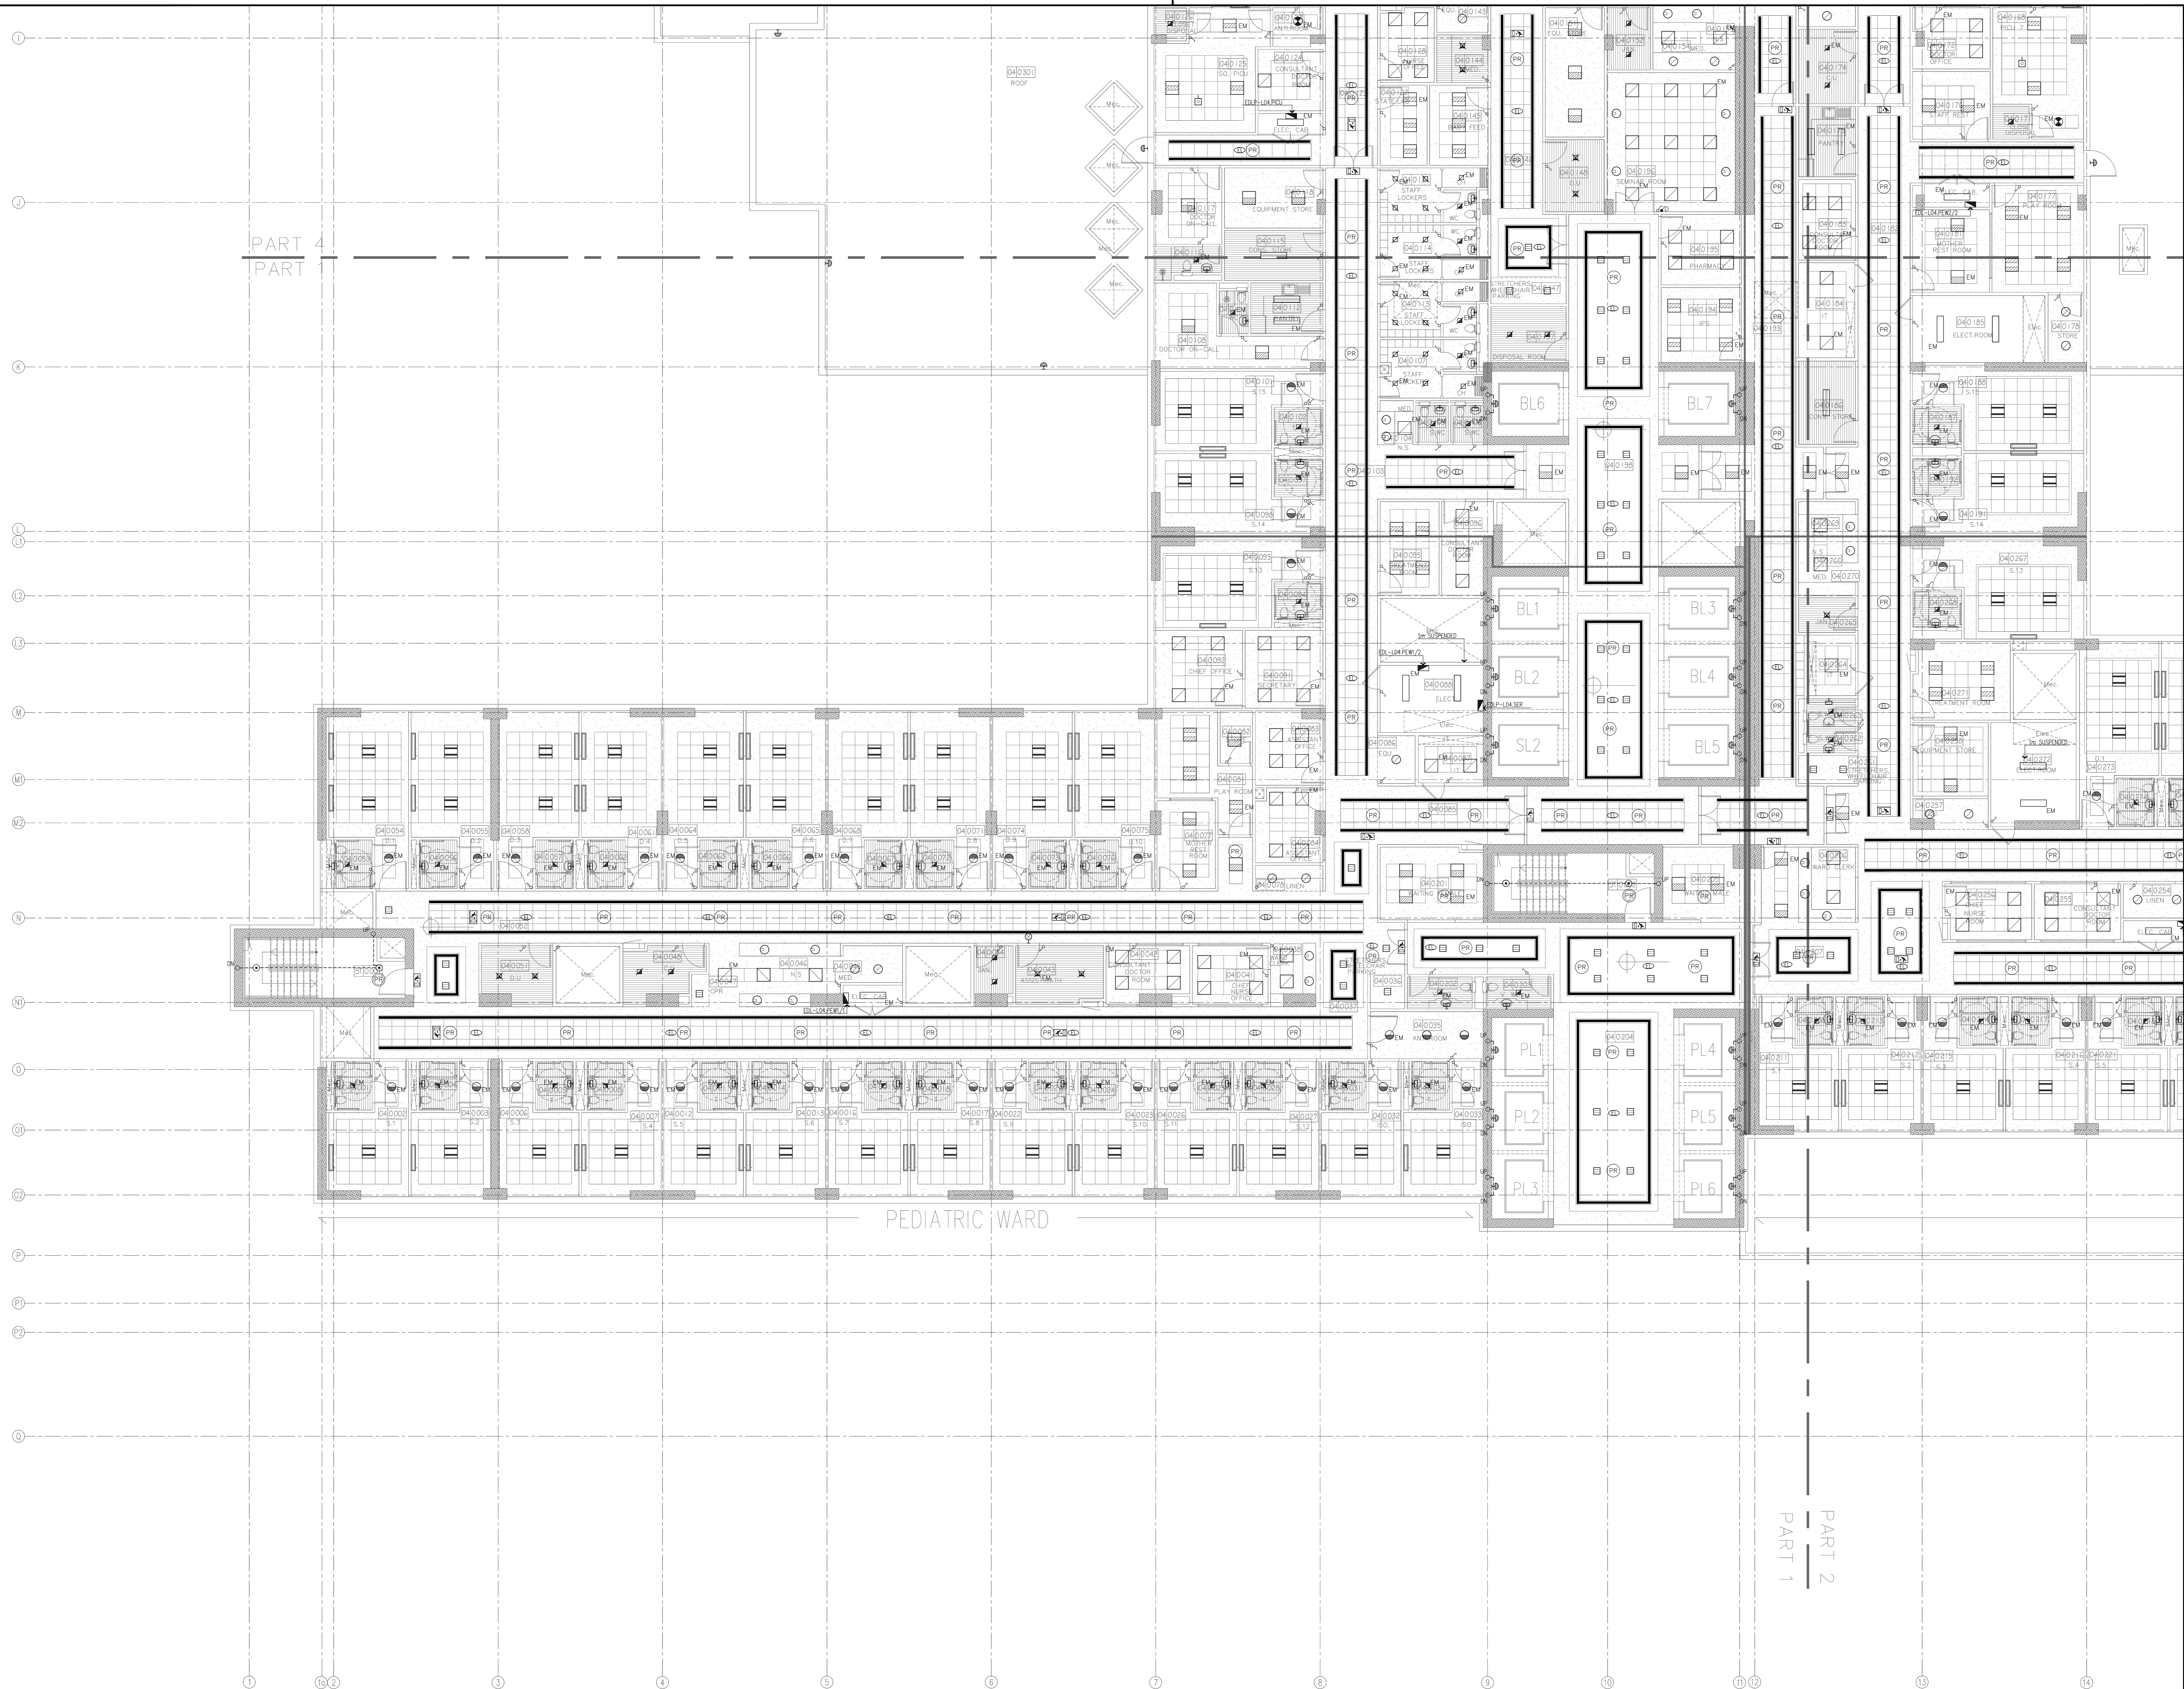

General Notes :

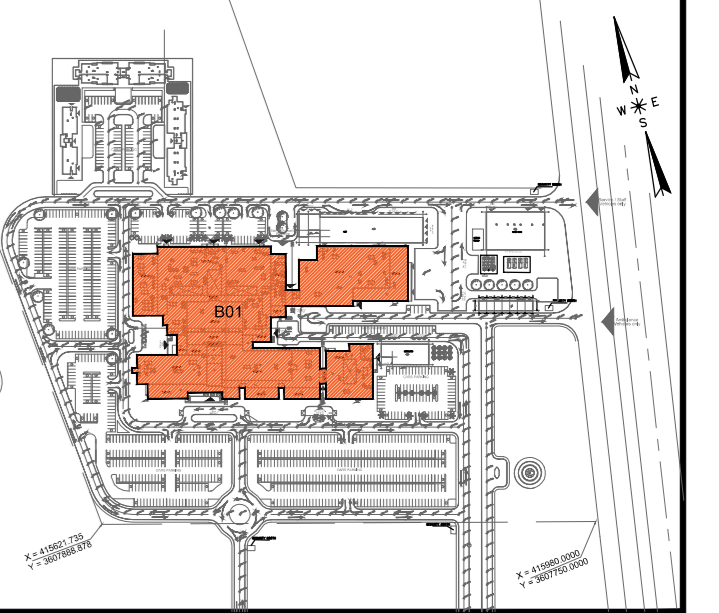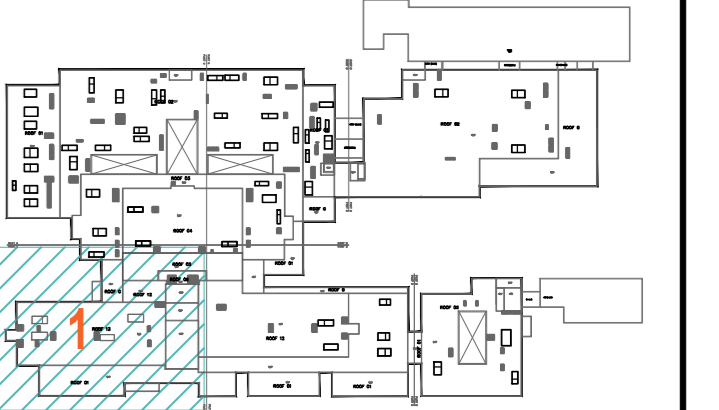

MINISTRY OF HIGHER EDUCATION
AND SCIENTIFIC RESEARCH
University OF Karbala



PROJECT MANAGEMENT CONSULTANT :



MAIN Contractor :



PRINCIPAL ENGINEERING CONSULTANT :

ARABTECH JARDANEH

CONSULTING HEALTH PLANNERS :

HDP | healthcare designers
and project managers

CONSULTING INTERNATIONAL ARCHITECTS :

LEO A DALY PLANNING ARCHITECTURE ENGINEERING INTERIORS

THIS DRAWING IS THE
COPYRIGHT OF ARABTECH
JARDANEH ENGINEERS &
ARCHITECTS AND MUST NOT BE
RETAINED, COPIED OR USED
WITHOUT THE CONSULTANTS'
AUTHORIZATION

[illegible]

DRAWN BY: E.D		DESIGNED BY: H.O/M.SH	
---------------	--	-----------------------	--

DRAWN BY: E.D		DESIGNED BY: H.O/M.SH	
---------------	--	-----------------------	--

HECKED BY: M.KH	APPROVED BY: F.J
-----------------	------------------

QC REVIEW BY: B.M	DWG ISSUE DATE: 26.10.2014	# ARC

PROJECT: KARRALA 600 BED TEACHING

KARBALA 600 BED TEACHING
UNIVERSITY HOSPITAL, IRAQ

UNIVERSITY HOSPITAL, IRAQ

CONCEPT DESIGN STAGE	PRELIMINARY DESIGN STAGE

DESIGN DEVELOPMENT STAGE	CONSTRUCTION DRAWINGS STAGE	TECH
DRAWING TITLE:		

ARABE

Downloaded from <http://ajphaphapublications.sagepub.com/>

FOURTH FLOOR PLAN

LIGHTING LAYOUT

PART 1

PART 1

01586	DWG KUH-EL-130	BLOCK * B01
-------	-------------------	----------------


REV. R0

AD FILE NAME: 01585-01-130-001-00 DANG

SAVED BY: Afif.glbboed ON: 25.10.2014 @ 08:59

AD FILE NAME: 01586-EL-130-001-R0.DWG

MUST NOT BE RETAINED, COMED OR USED WITHOUT THE CONSULTANT'S AUTHORIZATION

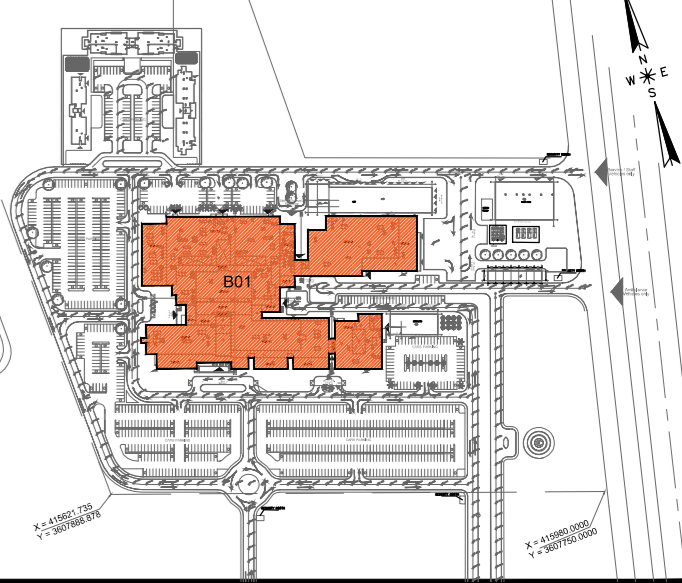

MAIN Contractor :



FOURTH DIMENSION
Contracting Engineering procurement



C/B.C

CONSULTING HEALTH PLANNERS :
HDP | healthcare designers
and project managers

CONSULTING INTERNATIONAL ARCHITECTS :
LEO A DALY PLANNING ARCHITECTURE ENGINEERING INTERIORS

THIS DRAWING IS THE
COPYRIGHT OF ARABTECH
JARDANEH ENGINEERS &
ARCHITECTS AND MUST NOT BE
RETAINED, COPIED OR USED
WITHOUT THE CONSULTANTS'
AUTHORIZATION

[illegible]

DRAWN BY:	E.D	DESIGNED BY:	H.O/M.SH
CHECKED BY:	M.KH	APPROVED BY:	F.J
QC REVIEW BY:	B.M	DWG ISSUE DATE: 26.10.2014	


PROJECT:
KARBALA 600 BED TEACHING
UNIVERSITY HOSPITAL, IRAQ

CONCEPT DESIGN STAGE	PRELIMINARY DESIGN STAGE
DESIGN DEVELOPMENT STAGE	CONSTRUCTION DRAWINGS STAGE

DRAWING TITLE:

FOURTH FLOOR PLAN
LIGHTING LAYOUT
PART 3

DB #	01586	DWG #	KUH-EL-132	BLOCK #	B01
1:100	④ (A0)	Shd.	03 of 05	REV. #	R0

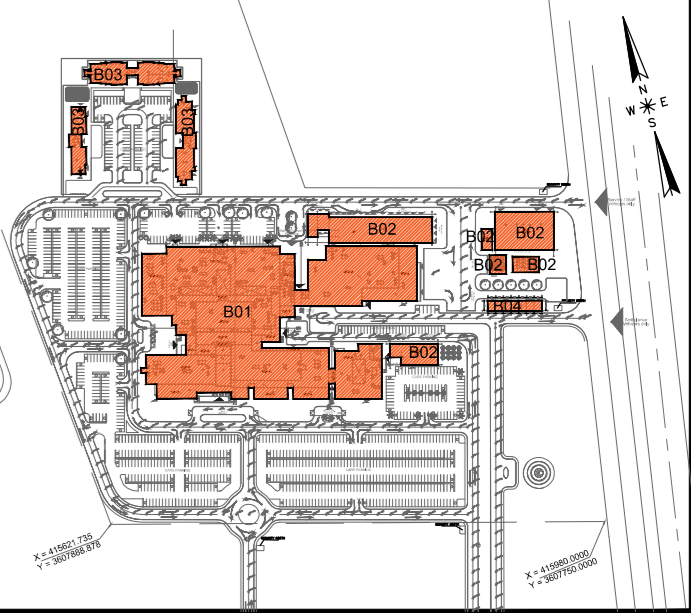

MAIN Contractor :  

CONSULTING HEALTH PLANNERS :

HDP | healthcare designers
and project managers

CONSULTING INTERNATIONAL ARCHITECTS :
LEO A DALY PLANNING ARCHITECTURE ENGINEERING INTERIORS



[illegible]


PROJECT:

CONCEPT DESIGN STAGE	PRELIMINARY DESIGN STAGE
DESIGN DEVELOPMENT STAGE	CONSTRUCTION DRAWINGS STAGE

DRAWING TITLE:

01586	DWG KUH-EL-133	BLOCK * B01
1:100 @ (A0)	Sheet 04 of 05	REV. * R0

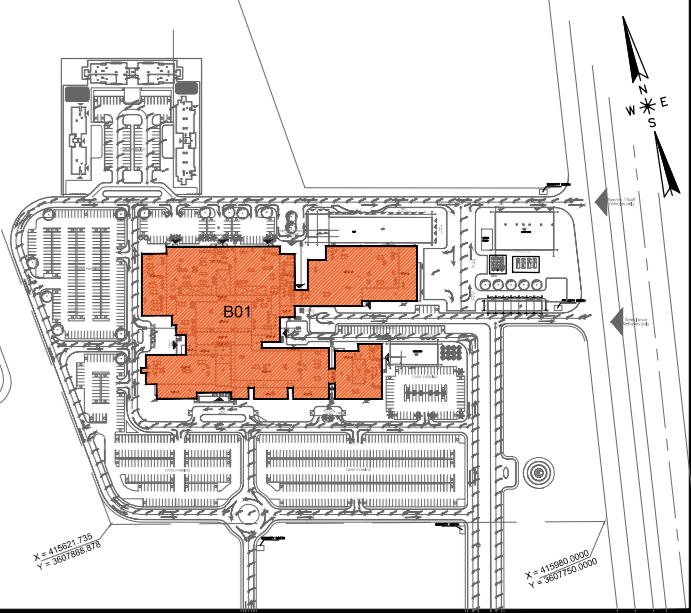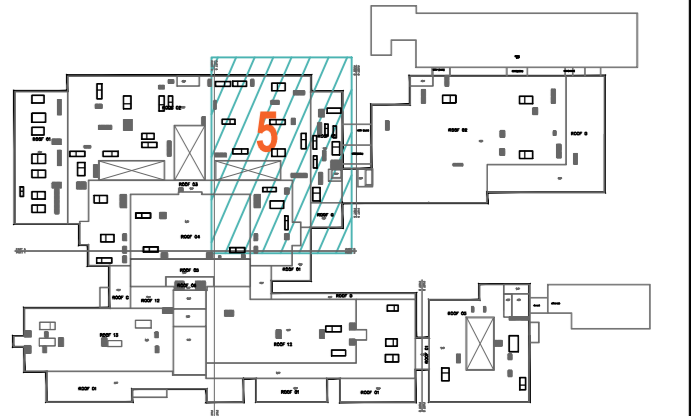

 
MAIN Contractor :  

HDP | healthcare designers
and project managers


CONSULTING INTERNATIONAL ARCHITECTS :
LEO A DALY PLANNING ARCHITECTURE ENGINEERING INTERIORS

[illegible]

PROJECT:	
KARBALA 600 BED TEACHING UNIVERSITY HOSPITAL, IRAQ	
CONCEPT DESIGN STAGE	PRELIMINARY DESIGN STAGE
DESIGN DEVELOPMENT STAGE	CONSTRUCTION DRAWINGS STAGE

DRAWING TITLE:

01586	DWG KUH-EL-134	BLOCK * B01
1:100 (A0)	Sheet 05 of 05	REV. * R0

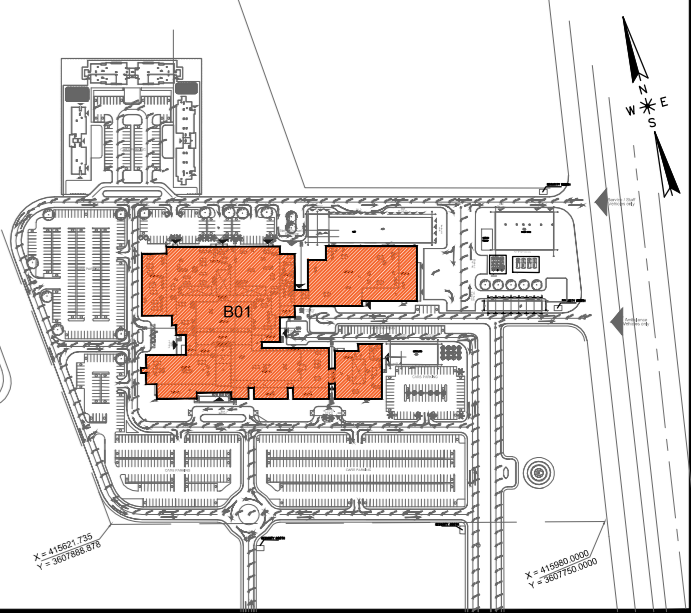

ARABTECH JARDANEH

CONSULTING INTERNATIONAL ARCHITECTS :
LEO A DALY PLANNING ARCHITECTURE ENGINEERING INTERIORS

THIS DRAWING IS THE
COPYRIGHT OF ARABTECH
JARDANEH ENGINEERS &
ARCHITECTS AND MUST NOT BE
RETAINED, COPIED OR USED
WITHOUT THE CONSULTANTS'
AUTHORIZATION

[illegible]

DRAWN BY:	E.D	DESIGNED BY:	H.O/M.SH
CHECKED BY:	M.KH	APPROVED BY:	F.J
QC REVIEW BY:	B.M	DWG ISSUE DATE: 26.10.2014	


PROJECT:
KARBALA 600 BED TEACHING
UNIVERSITY HOSPITAL, IRAQ

CONCEPT DESIGN STAGE	PRELIMINARY DESIGN STAGE
DESIGN DEVELOPMENT STAGE	CONSTRUCTION DRAWINGS STAGE


DRAWING TITLE:

FIFTH FLOOR PLAN
LIGHTING LAYOUT
OVERALL


DB	01586	DWG	KUH-EL-135	BLOCK	B01
	1:250	Sh.	01 of 01	REV.	R0

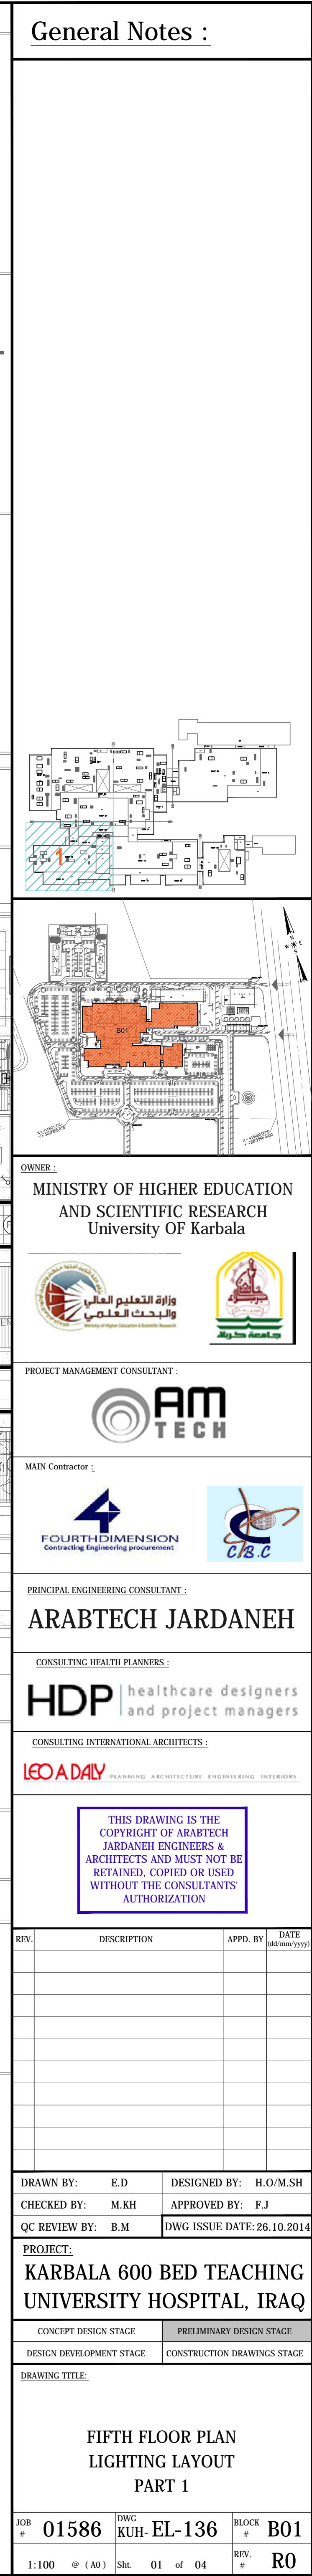

A floor plan of a building with various rooms and corridors. A red number '2' is placed in a central corridor area, and a blue hatched rectangular area is drawn around it, indicating a specific location of interest.

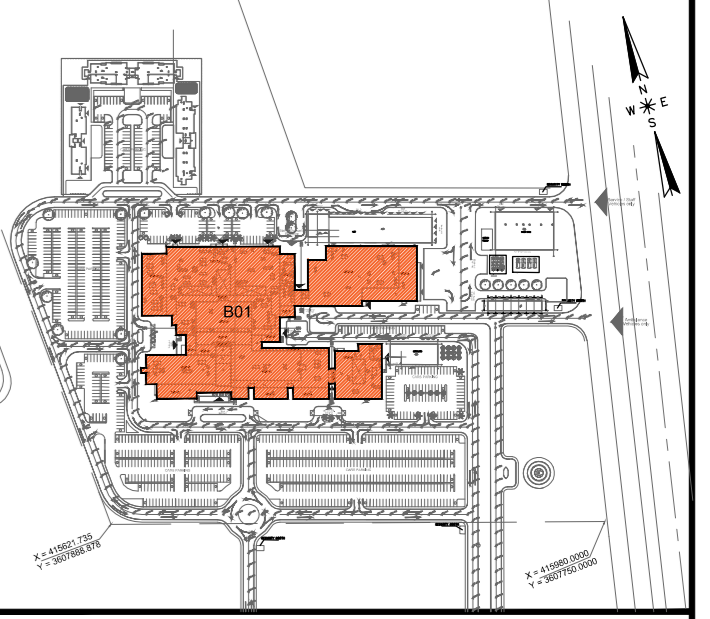




MAIN Contractor :  

CONSULTING HEALTH PLANNERS :

HDP | healthcare designers
and project managers

CONSULTING INTERNATIONAL ARCHITECTS :

LEO A DALY PLANNING ARCHITECTURE ENGINEERING INTERIORS

THIS DRAWING IS THE
COPYRIGHT OF ARABTECH
JARDANEH ENGINEERS &
CHITECTS AND MUST NOT BE
RETAINED, COPIED OR USED
WITHOUT THE CONSULTANTS'
AUTHORIZATION

[illegible]

DRAWN BY:	E.D	DESIGNED BY:	H.O/M.SH
CHECKED BY:	M.KH	APPROVED BY:	F.J
QC REVIEW BY:	B.M	DWG ISSUE DATE: 26.10.2014	


PROJECT:
KARBALA 600 BED TEACHING
UNIVERSITY HOSPITAL, IRAQ

CONCEPT DESIGN STAGE	PRELIMINARY DESIGN STAGE
DESIGN DEVELOPMENT STAGE	CONSTRUCTION DRAWINGS STAGE



DRAWING TITLE:

FIFTH FLOOR PLAN
LIGHTING LAYOUT
PART 2

01586	DWG KUH-EL-137	BLOCK * B01
1:100 @ (A0)	Sht. 02 of 04	REV. * R0

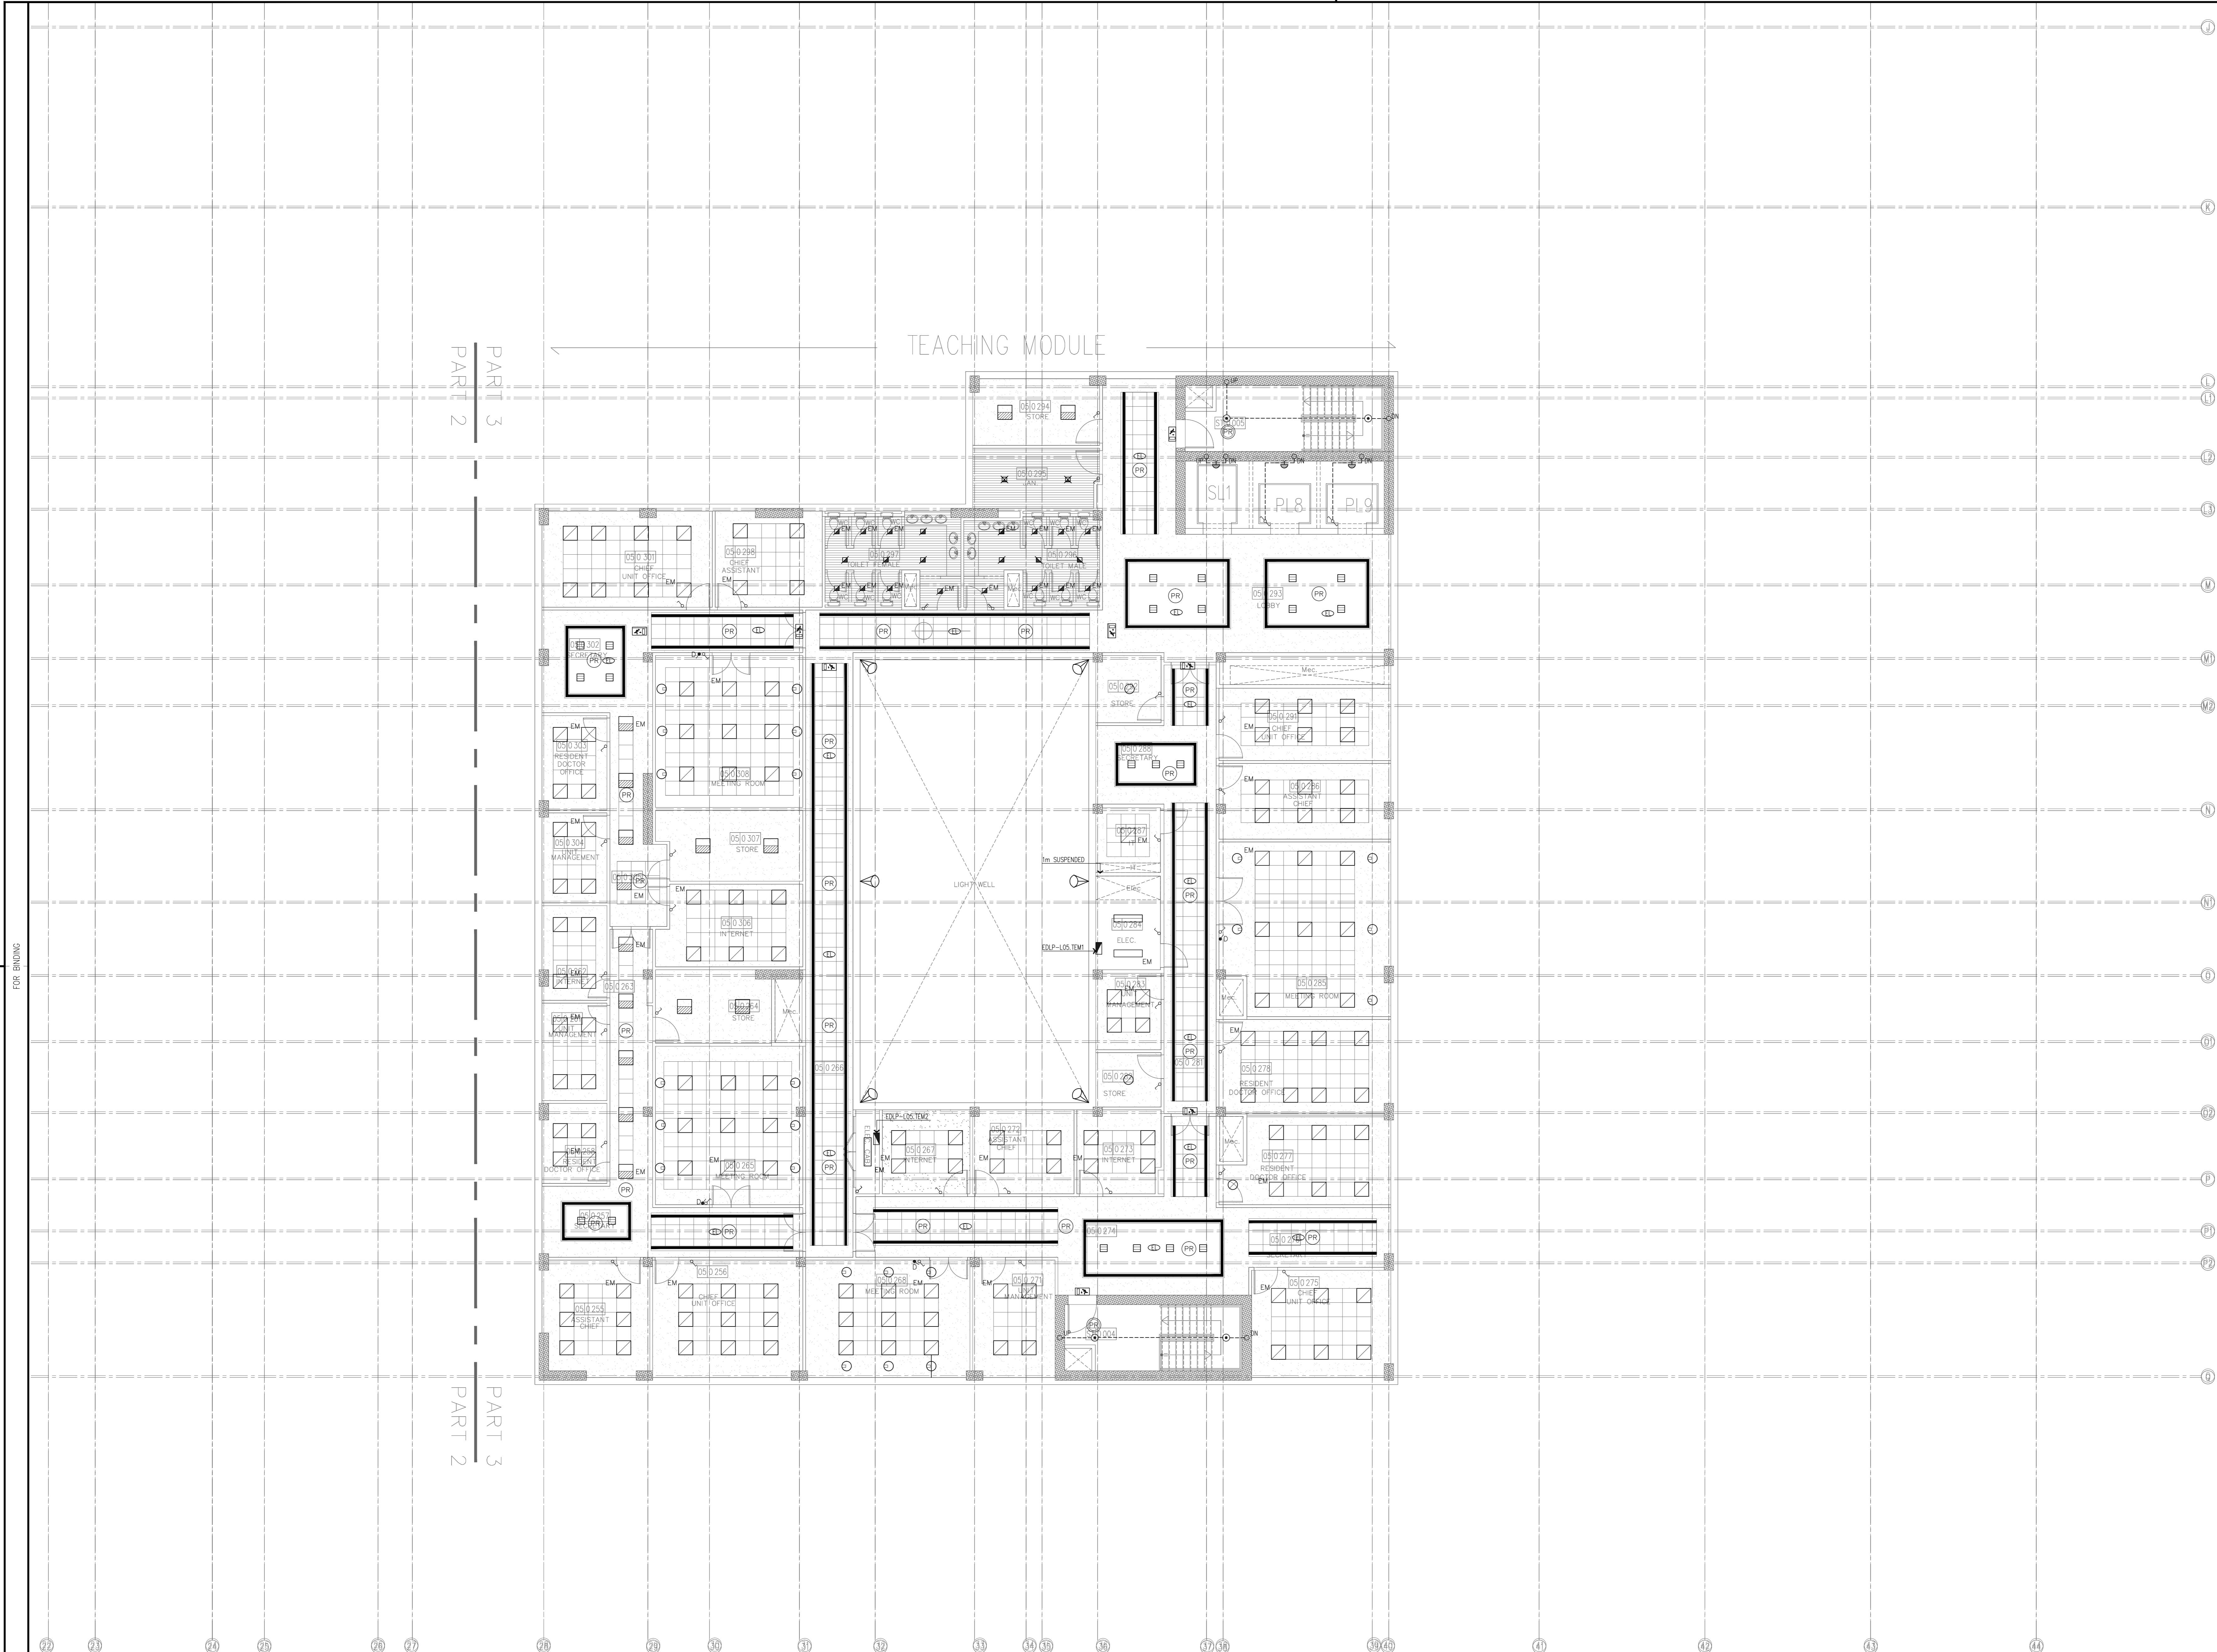

General Notes :

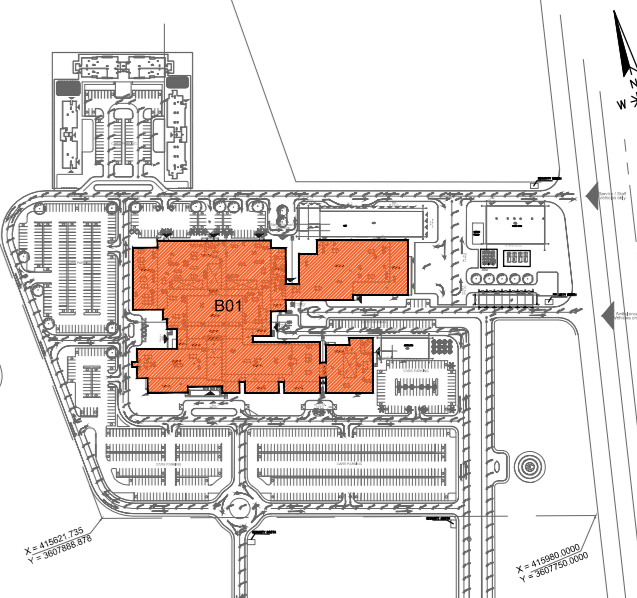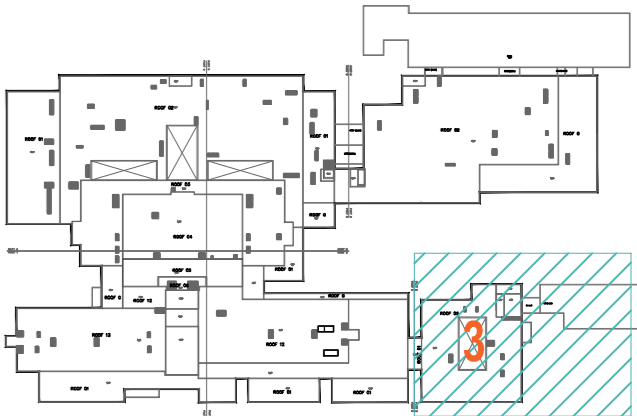

MINISTRY OF HIGHER EDUCATION
AND SCIENTIFIC RESEARCH
University Of Karbala



PROJECT MANAGEMENT CONSULTANT
AM TECH

MAIN CONTRACTOR
FOURTH DIMENSION
Consulting Engineering & Construction
CIS C

PRINCIPAL ENGINEERING CONSULTANT
ARABTECH JARDANEH

CONSULTING HEALTH PLANNERS
HDP healthcare designers
and project managers

CONSULTING INTERNATIONAL ARCHITECTS
LEO A DALY
PLANNING ARCHITECTURE ENGINEERING INTERIORS

THIS DRAWING IS THE
COPYRIGHT OF ARABTECH
JARDANEH ENGINEERS &
ARCHITECTS AND MUST NOT BE
REPRODUCED, COPIED OR USED
WITHOUT THE CONSULTANTS
AUTHORIZATION

REV.	DESCRIPTION	APPRO. BY	DATE

DRAWN BY: E.D. DESIGNED BY: H.O.M.S.H.
CHECKED BY: M.K.H. APPROVED BY: F.J.
QC REVIEW BY: B.M. DWG ISSUE DATE: 26.10.2014


PROJECT:
**KARBALA 600 BED TEACHING
UNIVERSITY HOSPITAL, IRAQ**

CONCEPT DESIGN STAGE PRELIMINARY DESIGN STAGE
DESIGN DEVELOPMENT STAGE CONSTRUCTION DRAWINGS STAGE

DRAWING TITLE:

**FIFTH FLOOR PLAN
LIGHTING LAYOUT
PART 3**

A0B 01586 DWG: KUH-EL-138 BLOCK B01
1:100 Sht. 03 of 04 REV. RO

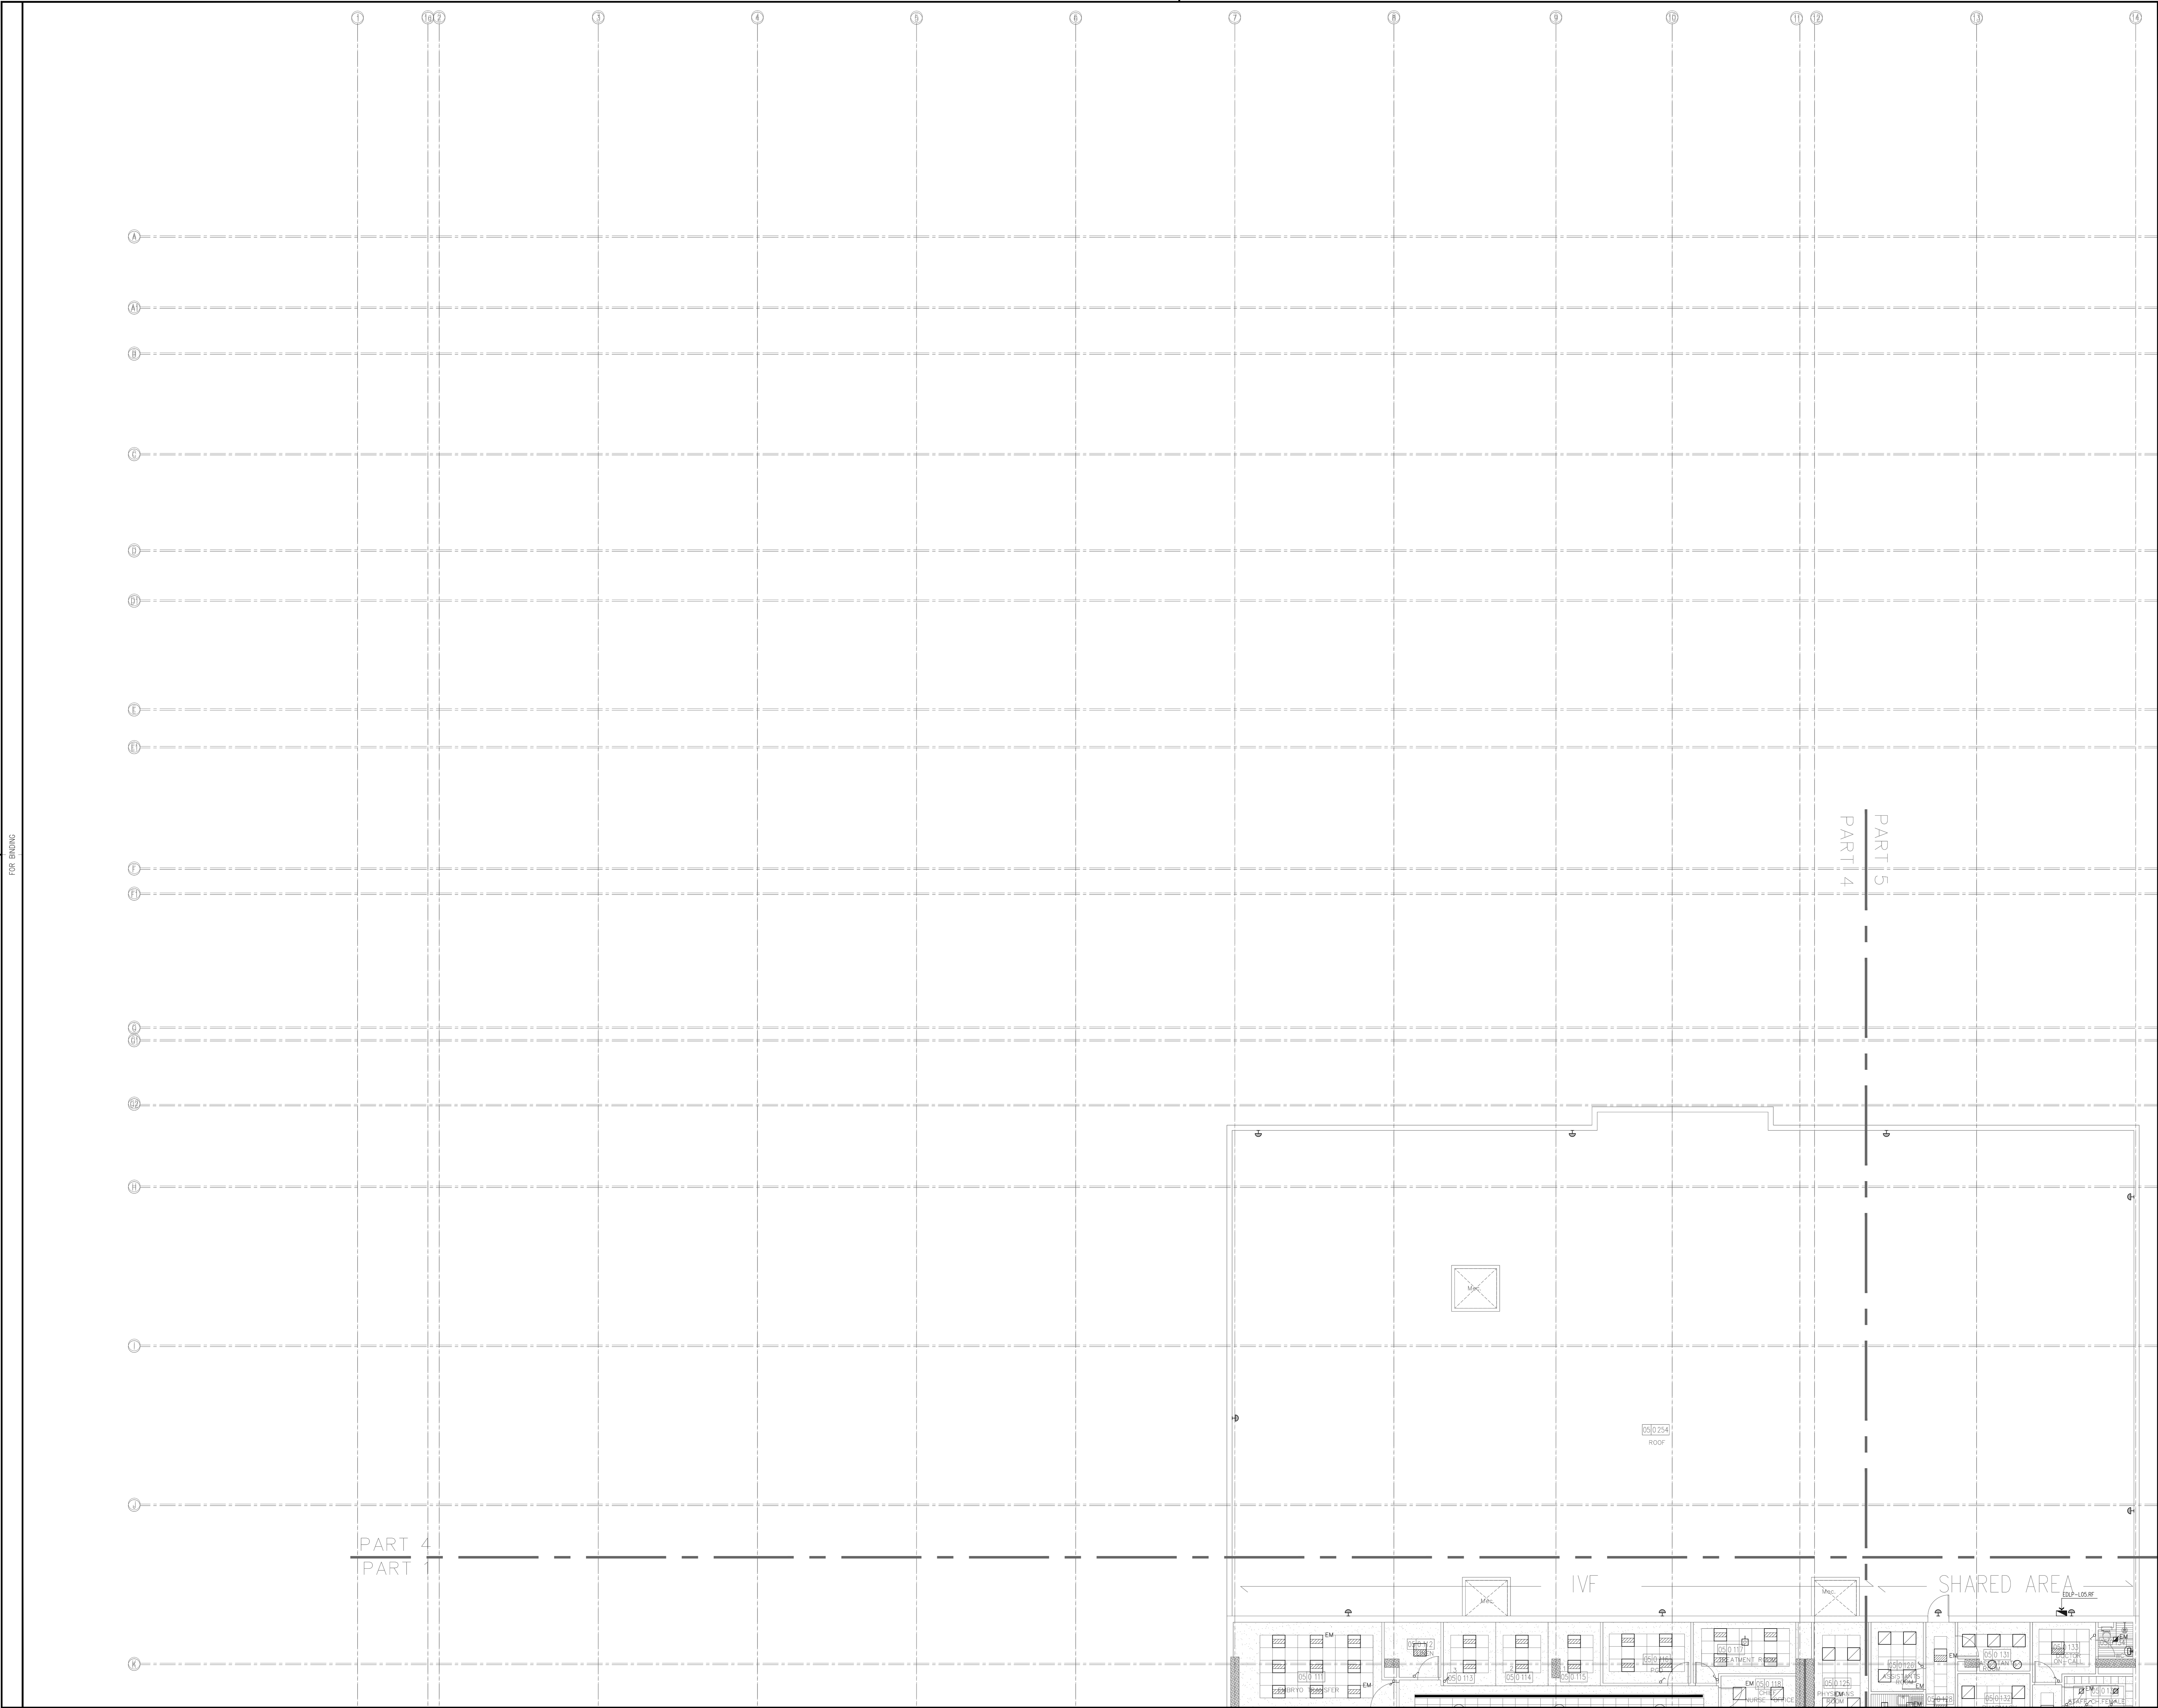

General Notes :



OWNER :

MINISTRY OF HIGHER EDUCATION
AND SCIENTIFIC RESEARCH
University Of Karbala



PROJECT MANAGEMENT CONSULTANT :



MAIN Contractor :



PRINCIPAL ENGINEERING CONSULTANT :

ARABTECH JARDANEH

CONSULTING HEALTH PLANNERS :

HDP healthcare designers
and project managers

CONSULTING INTERNATIONAL ARCHITECTS :

LEO A DALY PLANNING ARCHITECTURE ENGINEERING INTERIORS

THIS DRAWING IS THE
COPYRIGHT OF ARABTECH
JARDANEH ENGINEERS &
ARCHITECTS AND MUST NOT BE
REPRODUCED, COPIED OR USED
WITHOUT THE CONSULTANTS'
AUTHORIZATION

REV.	DESCRIPTION	APPRO. BY	DATE

DRAWN BY: E.D

DESIGNED BY: H.O/M/SH

CHECKED BY: M.KH

APPROVED BY: F.J

QC REVIEW BY: B.M

DWG ISSUE DATE: 26.10.2014

PROJECT:

KARBALA 600 BED TEACHING
UNIVERSITY HOSPITAL, IRAQ

CONCEPT DESIGN STAGE

PRELIMINARY DESIGN STAGE

DESIGN DEVELOPMENT STAGE

CONSTRUCTION DRAWINGS STAGE

DRAWING TITLE:

FIFTH FLOOR PLAN
LIGHTING LAYOUT
PART 4

A01

01586

EL-139

B01


1:100

04



04

R0

FOR BUILDING

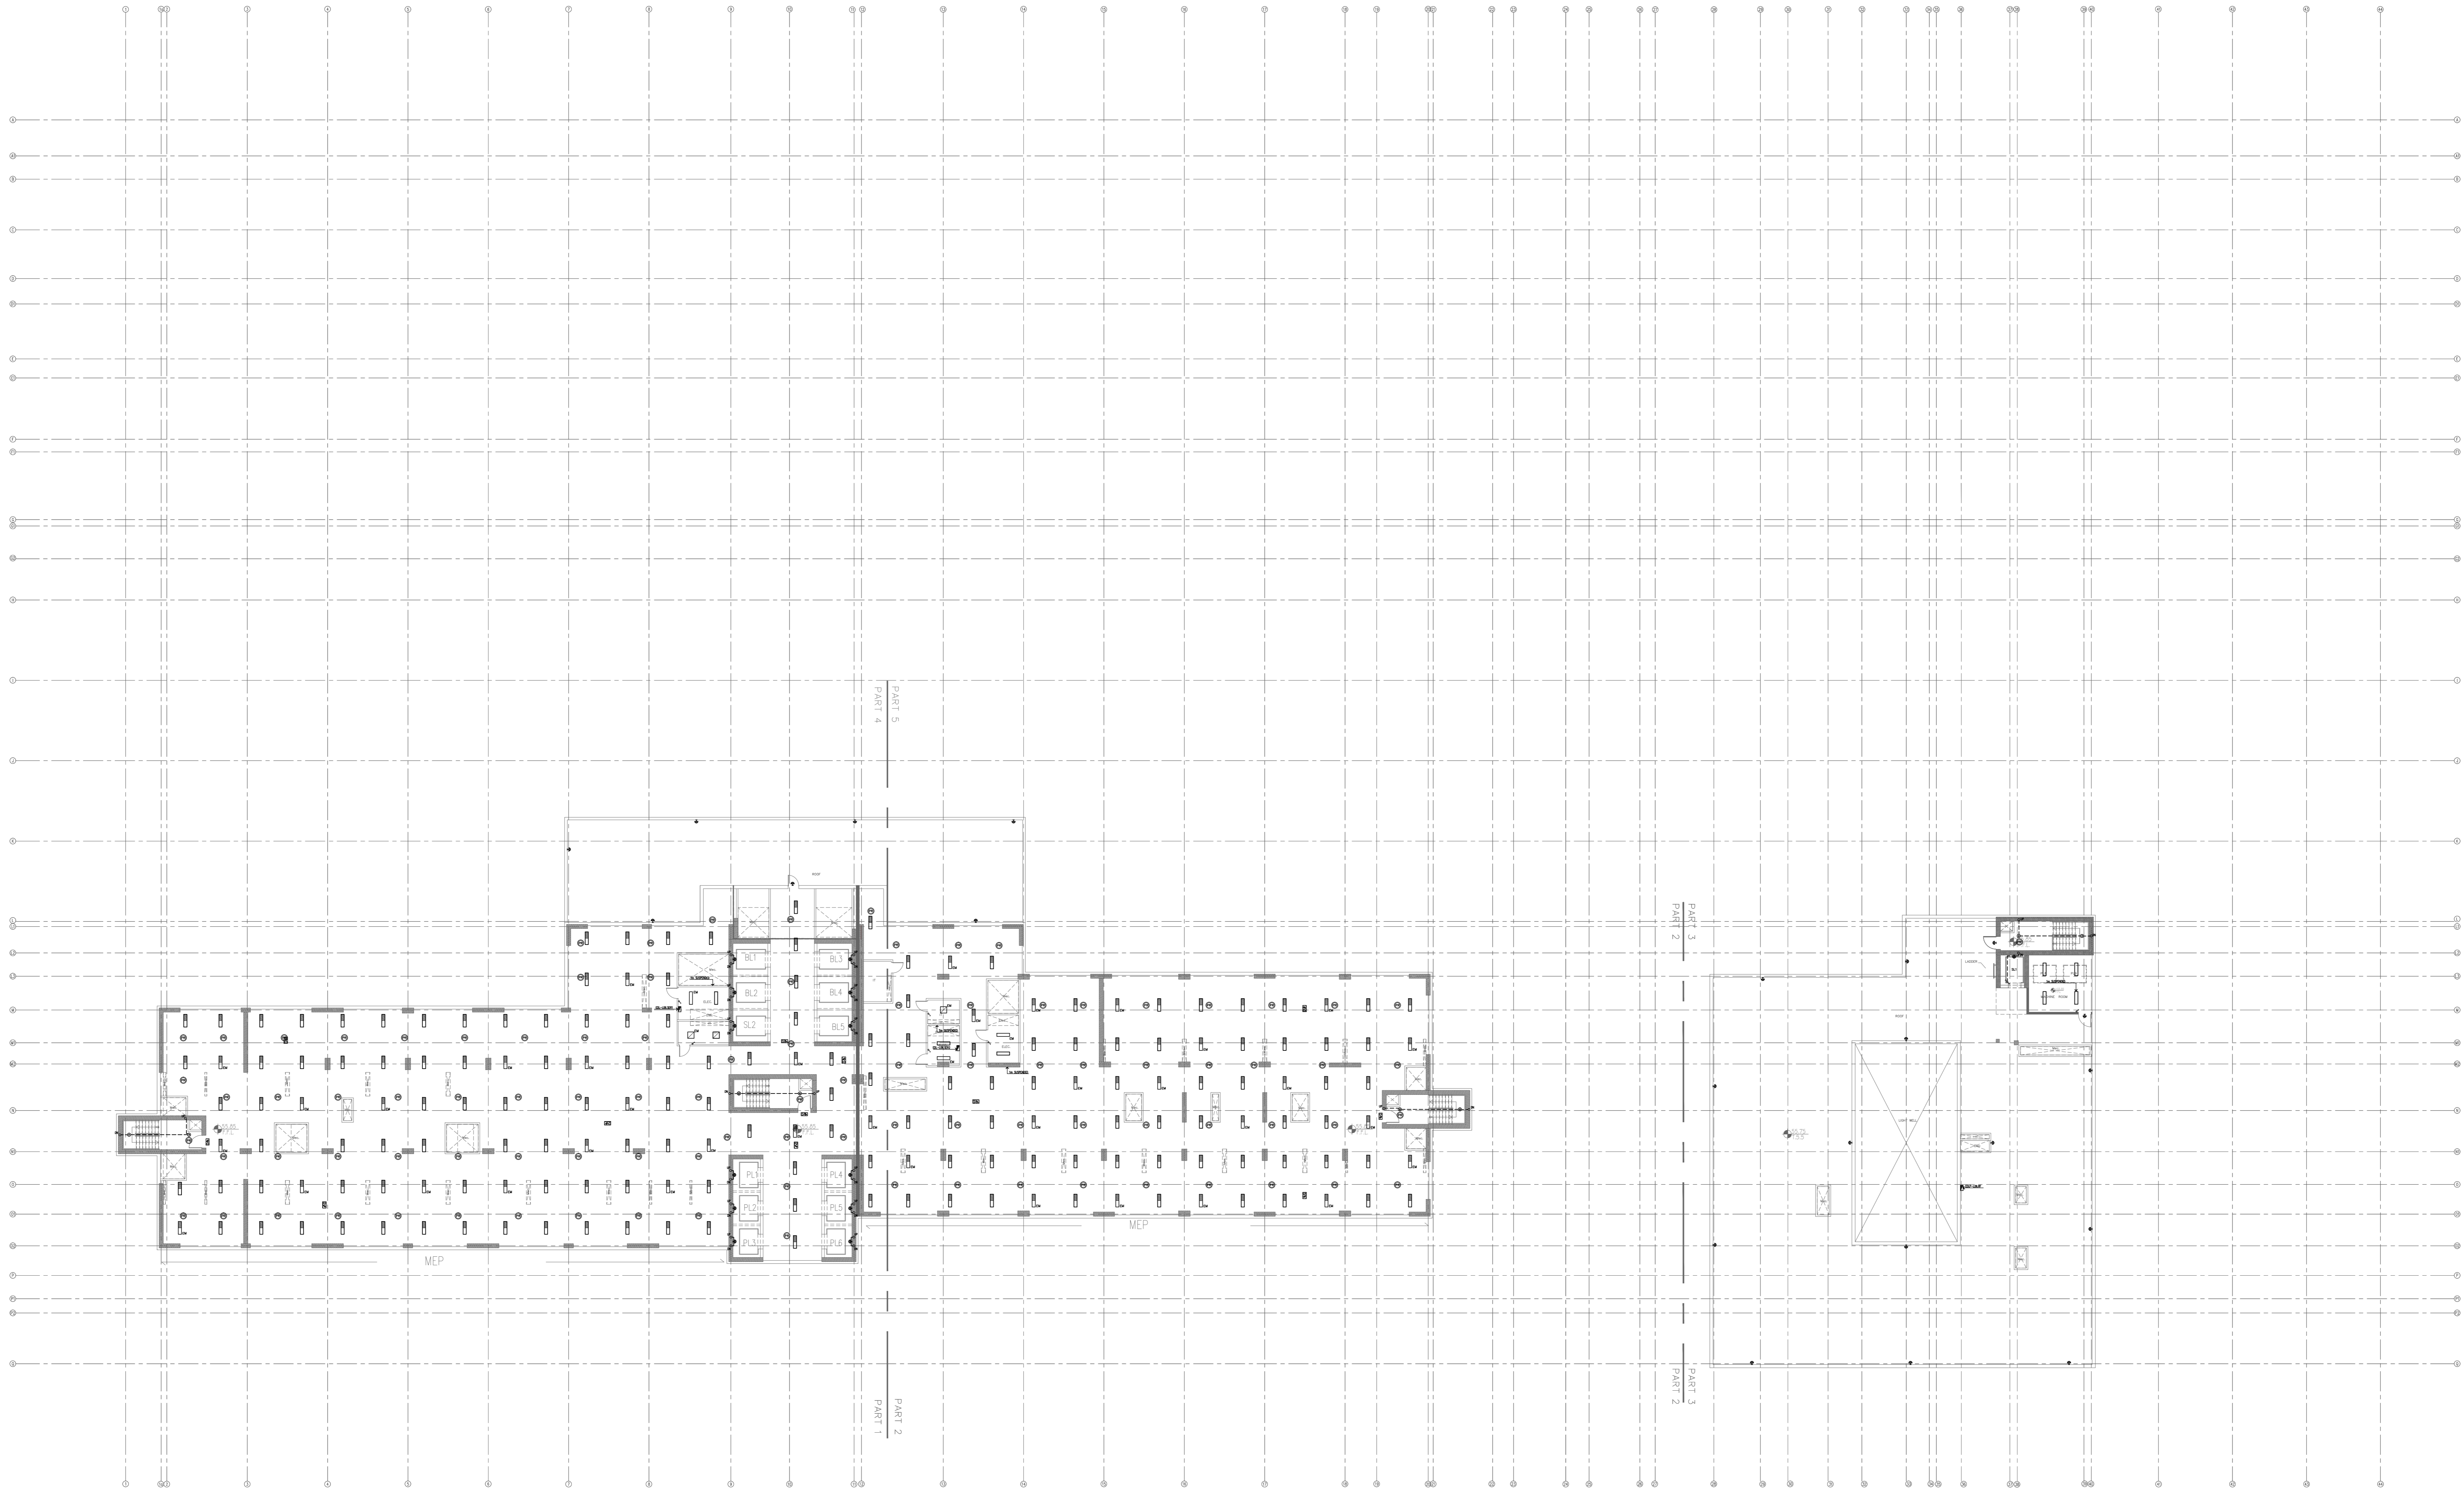

General Notes :

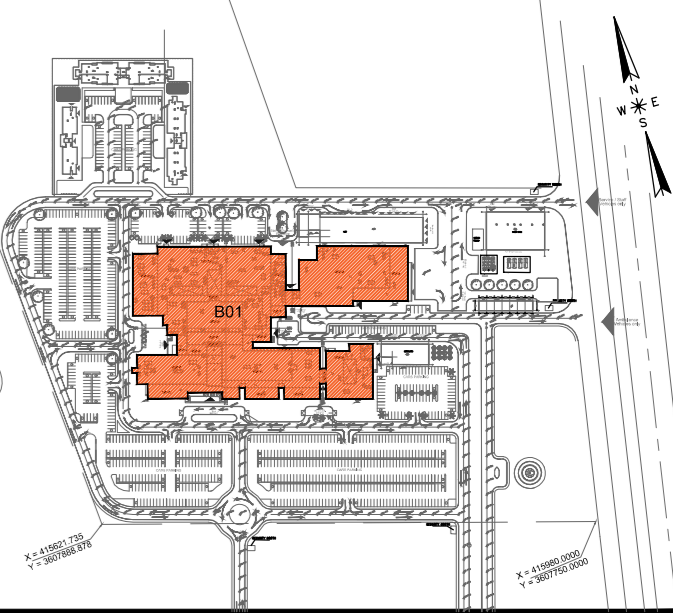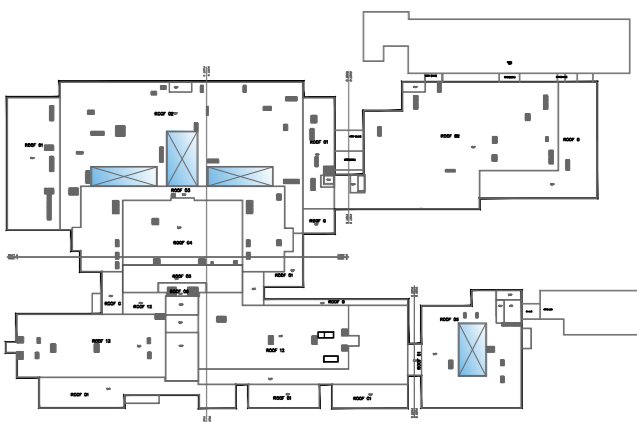

OWNER:
MINISTRY OF HIGHER EDUCATION
AND SCIENTIFIC RESEARCH
University Of Karbala



PROJECT MANAGEMENT CONSULTANT:
**AM
TECH**

MAIN Contractor :
FOURTH DIMENSION
Consulting Engineering & Construction
C/S.C

PRINCIPAL ENGINEERING CONSULTANT:
ARABTECH JARDANEH

CONSULTING HEALTH PLANNERS :
HDP healthcare designers
and project managers

CONSULTING INTERNATIONAL ARCHITECTS :
LEO A DALY
PLANNING ARCHITECTURE ENGINEERING INTERIORS

THIS DRAWING IS THE
COPYRIGHT OF ARABTECH
JARDANEH ENGINEERS &
ARCHITECTS AND MUST NOT BE
REPRODUCED, COPIED OR USED
WITHOUT THE CONSULTANTS'
AUTHORIZATION

REV.	DESCRIPTION	APPRO. BY	DATE

DRAWN BY: E.D. DESIGNED BY: H.O./M.S.H.
CHECKED BY: M.K.H. APPROVED BY: F.J.
QC REVIEW BY: B.M. DWG ISSUE DATE: 26.10.2014


PROJECT:
**KARBALA 600 BED TEACHING
UNIVERSITY HOSPITAL, IRAQ**

CONCEPT DESIGN STAGE	PRELIMINARY DESIGN STAGE
DESIGN DEVELOPMENT STAGE	CONSTRUCTION DRAWINGS STAGE



DRAWING TITLE:

**SIXTH FLOOR PLAN
LIGHTING LAYOUT
OVERALL**

A0B # 01586 DWG: KUH-EL-140 BLOCK # B01
1:250 @ (A0) Sht. 01 of 01 REV. # R0

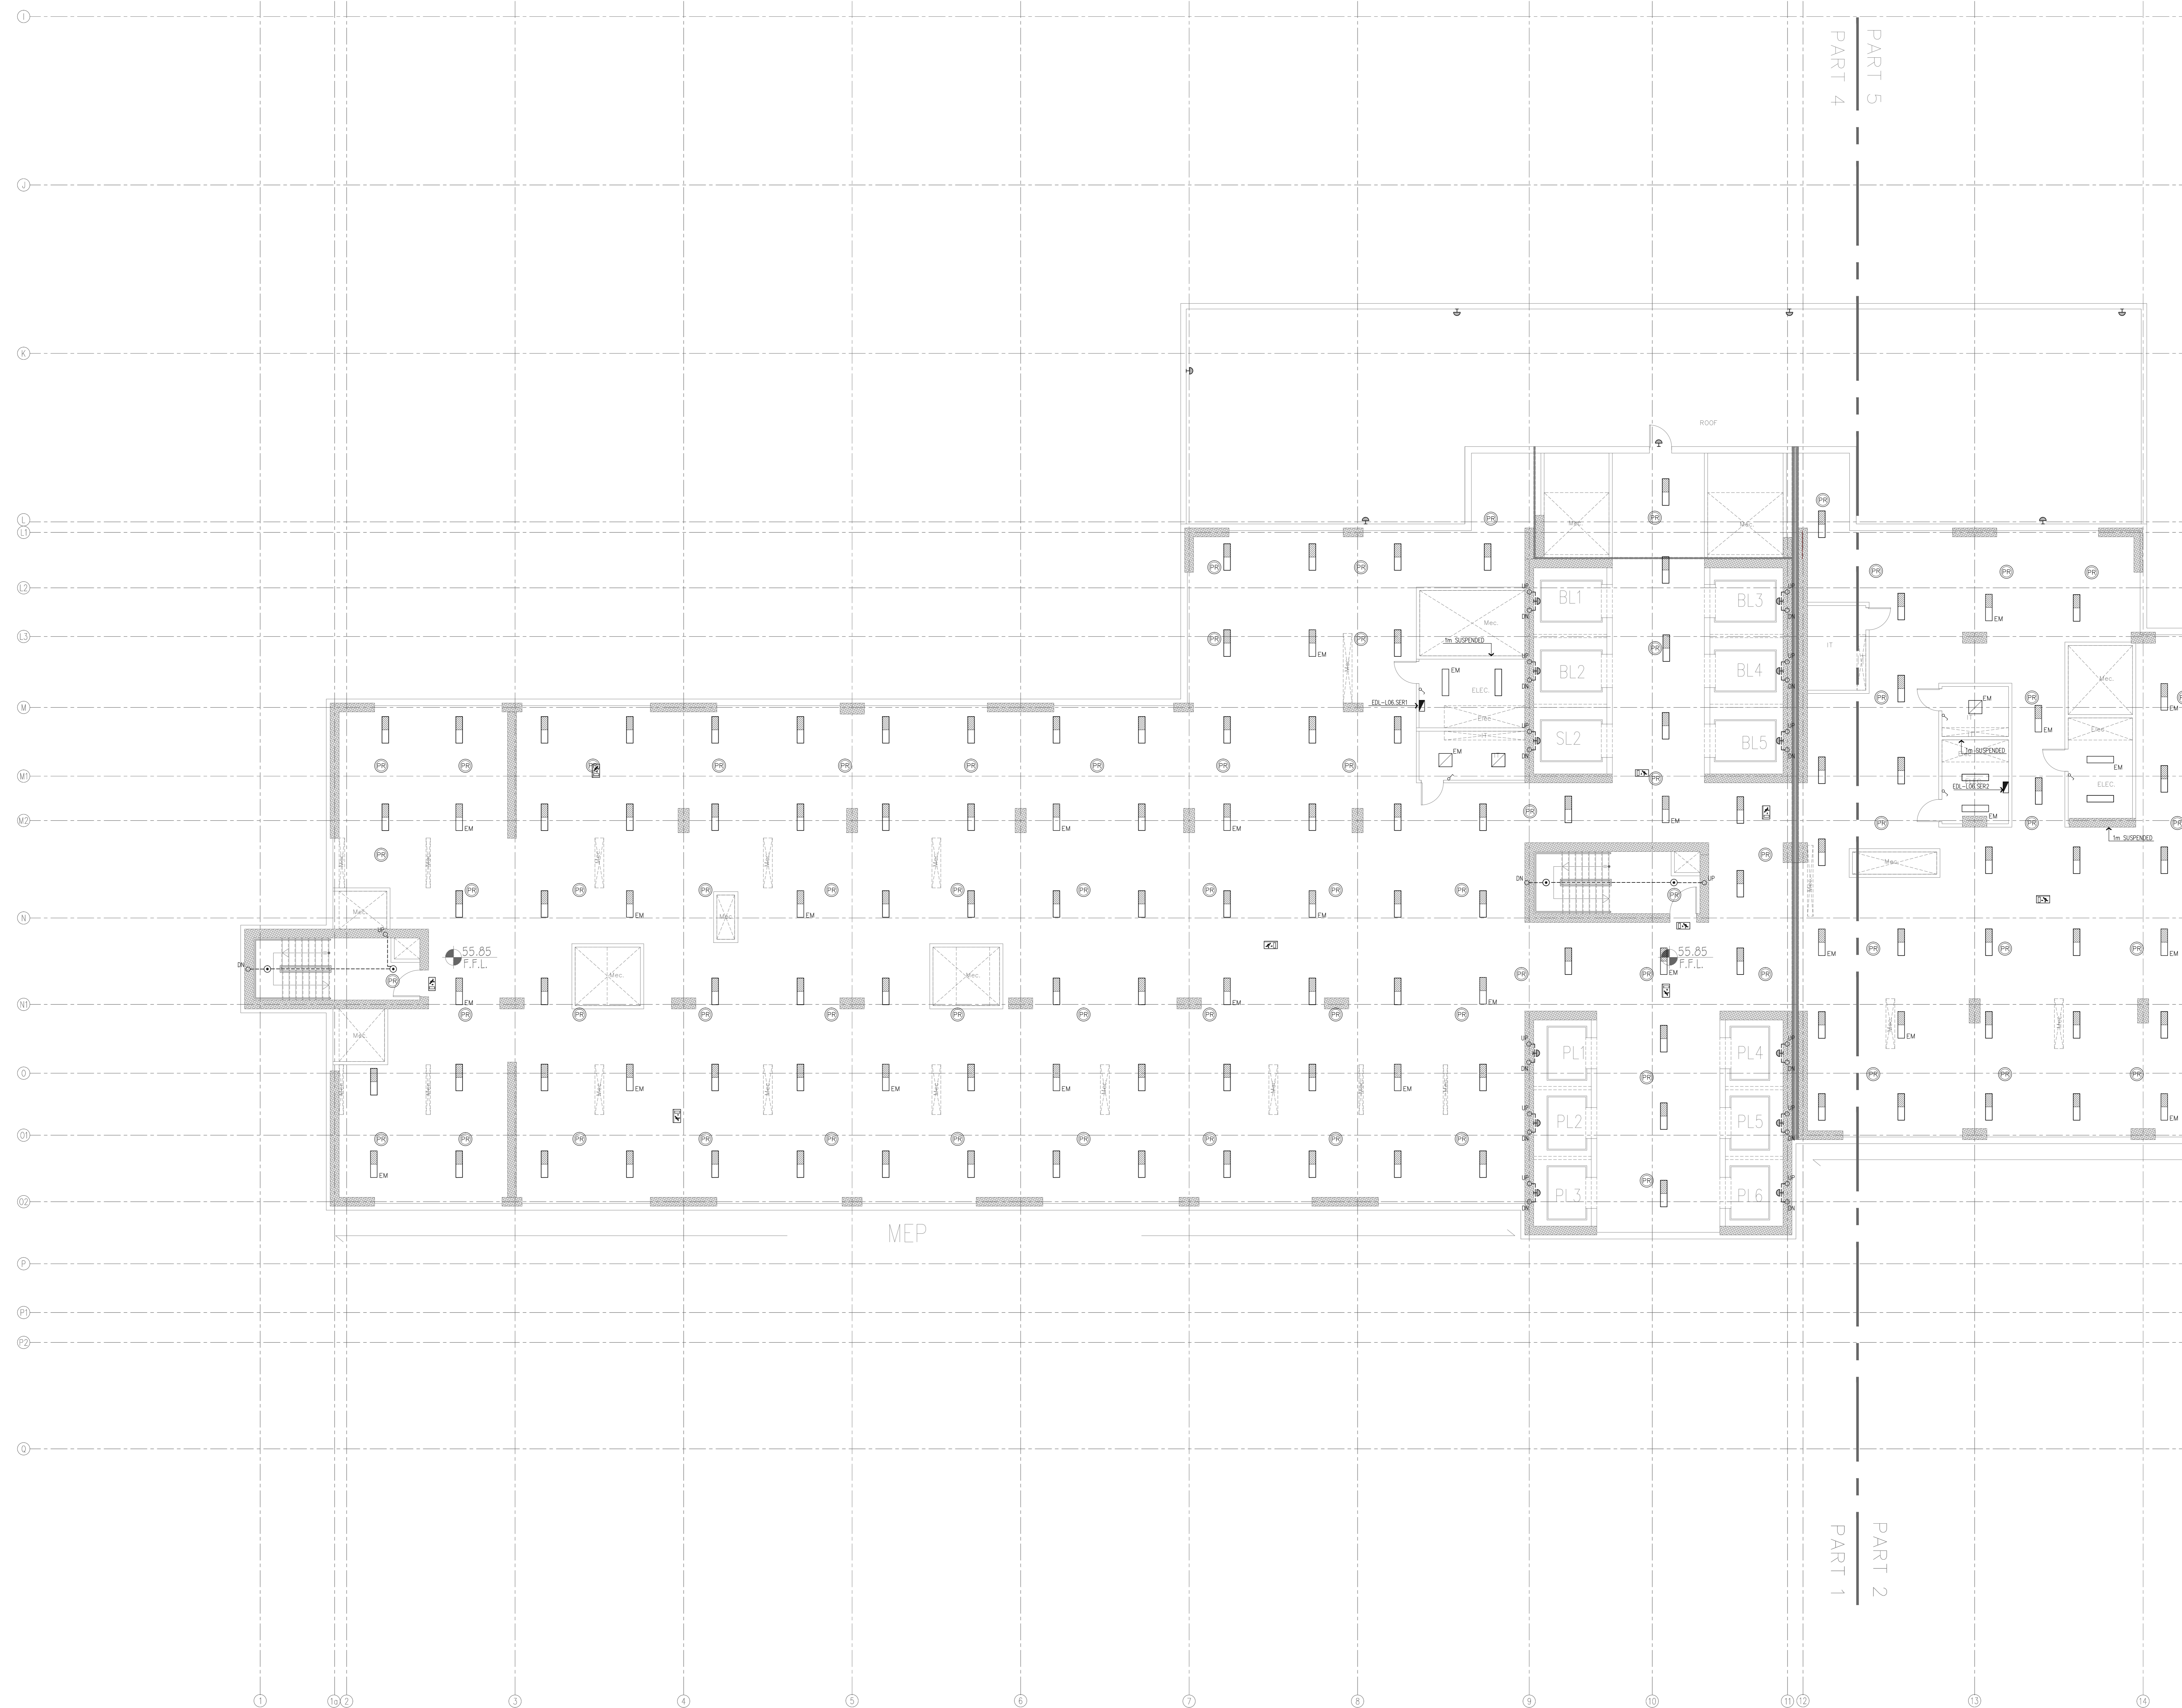

General Notes :

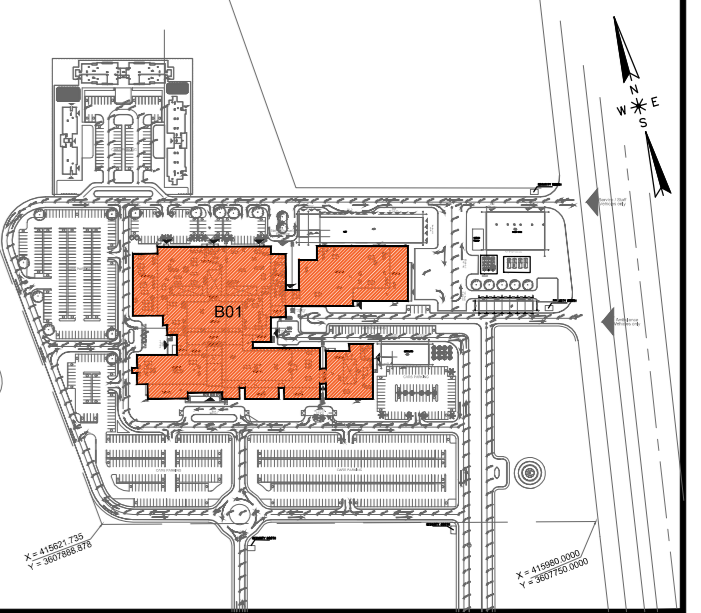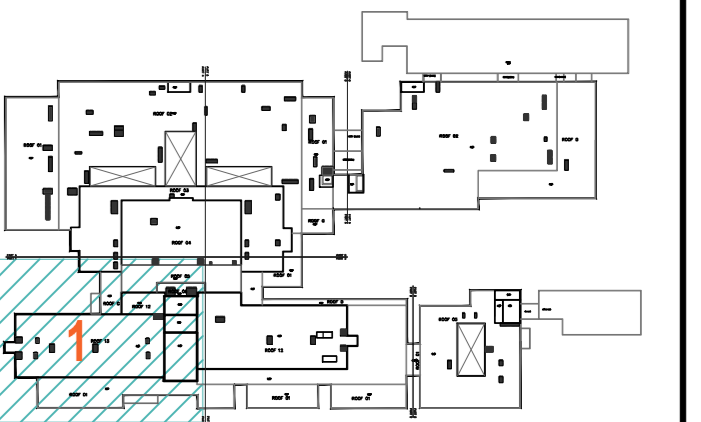

MINISTRY OF HIGHER EDUCATION
AND SCIENTIFIC RESEARCH
University OF Karbala



PROJECT MANAGEMENT CONSULTANT :



MAIN Contractor :



PRINCIPAL ENGINEERING CONSULTANT :

ARABTECH JARDANEH

HDP | healthcare designers
and project managers

CONSULTING INTERNATIONAL ARCHITECTS :

EO A DAILY PLANNING ARCHITECTURE ENGINEERING INTERIORS

THIS DRAWING IS THE
COPYRIGHT OF ARABTECH
JARDANEH ENGINEERS &
ARCHITECTS AND MUST NOT BE
RETAINED, COPIED OR USED
WITHOUT THE CONSULTANTS'
AUTHORIZATION

[illegible]

DRAWN BY:	E.D	DESIGNED BY:	H.O/M.SH
CHECKED BY:	M.KH	APPROVED BY:	F.J
QC REVIEW BY:	B.M	DWG ISSUE DATE: 26.10.2014	


PROJECT: KARBALA 600 BED TEACHING UNIVERSITY HOSPITAL, IRAQ

CONCEPT DESIGN STAGE	PRELIMINARY DESIGN STAGE
DESIGN DEVELOPMENT STAGE	CONSTRUCTION DRAWINGS STAGE



DRAWING TITLE:

SIXTH FLOOR PLAN
LIGHTING LAYOUT
PART 1

B 01586	DWG KUH- EL-141	BLOCK * B01
1:100 @ (A0)	Shd. 01 of 03	REV. * R0

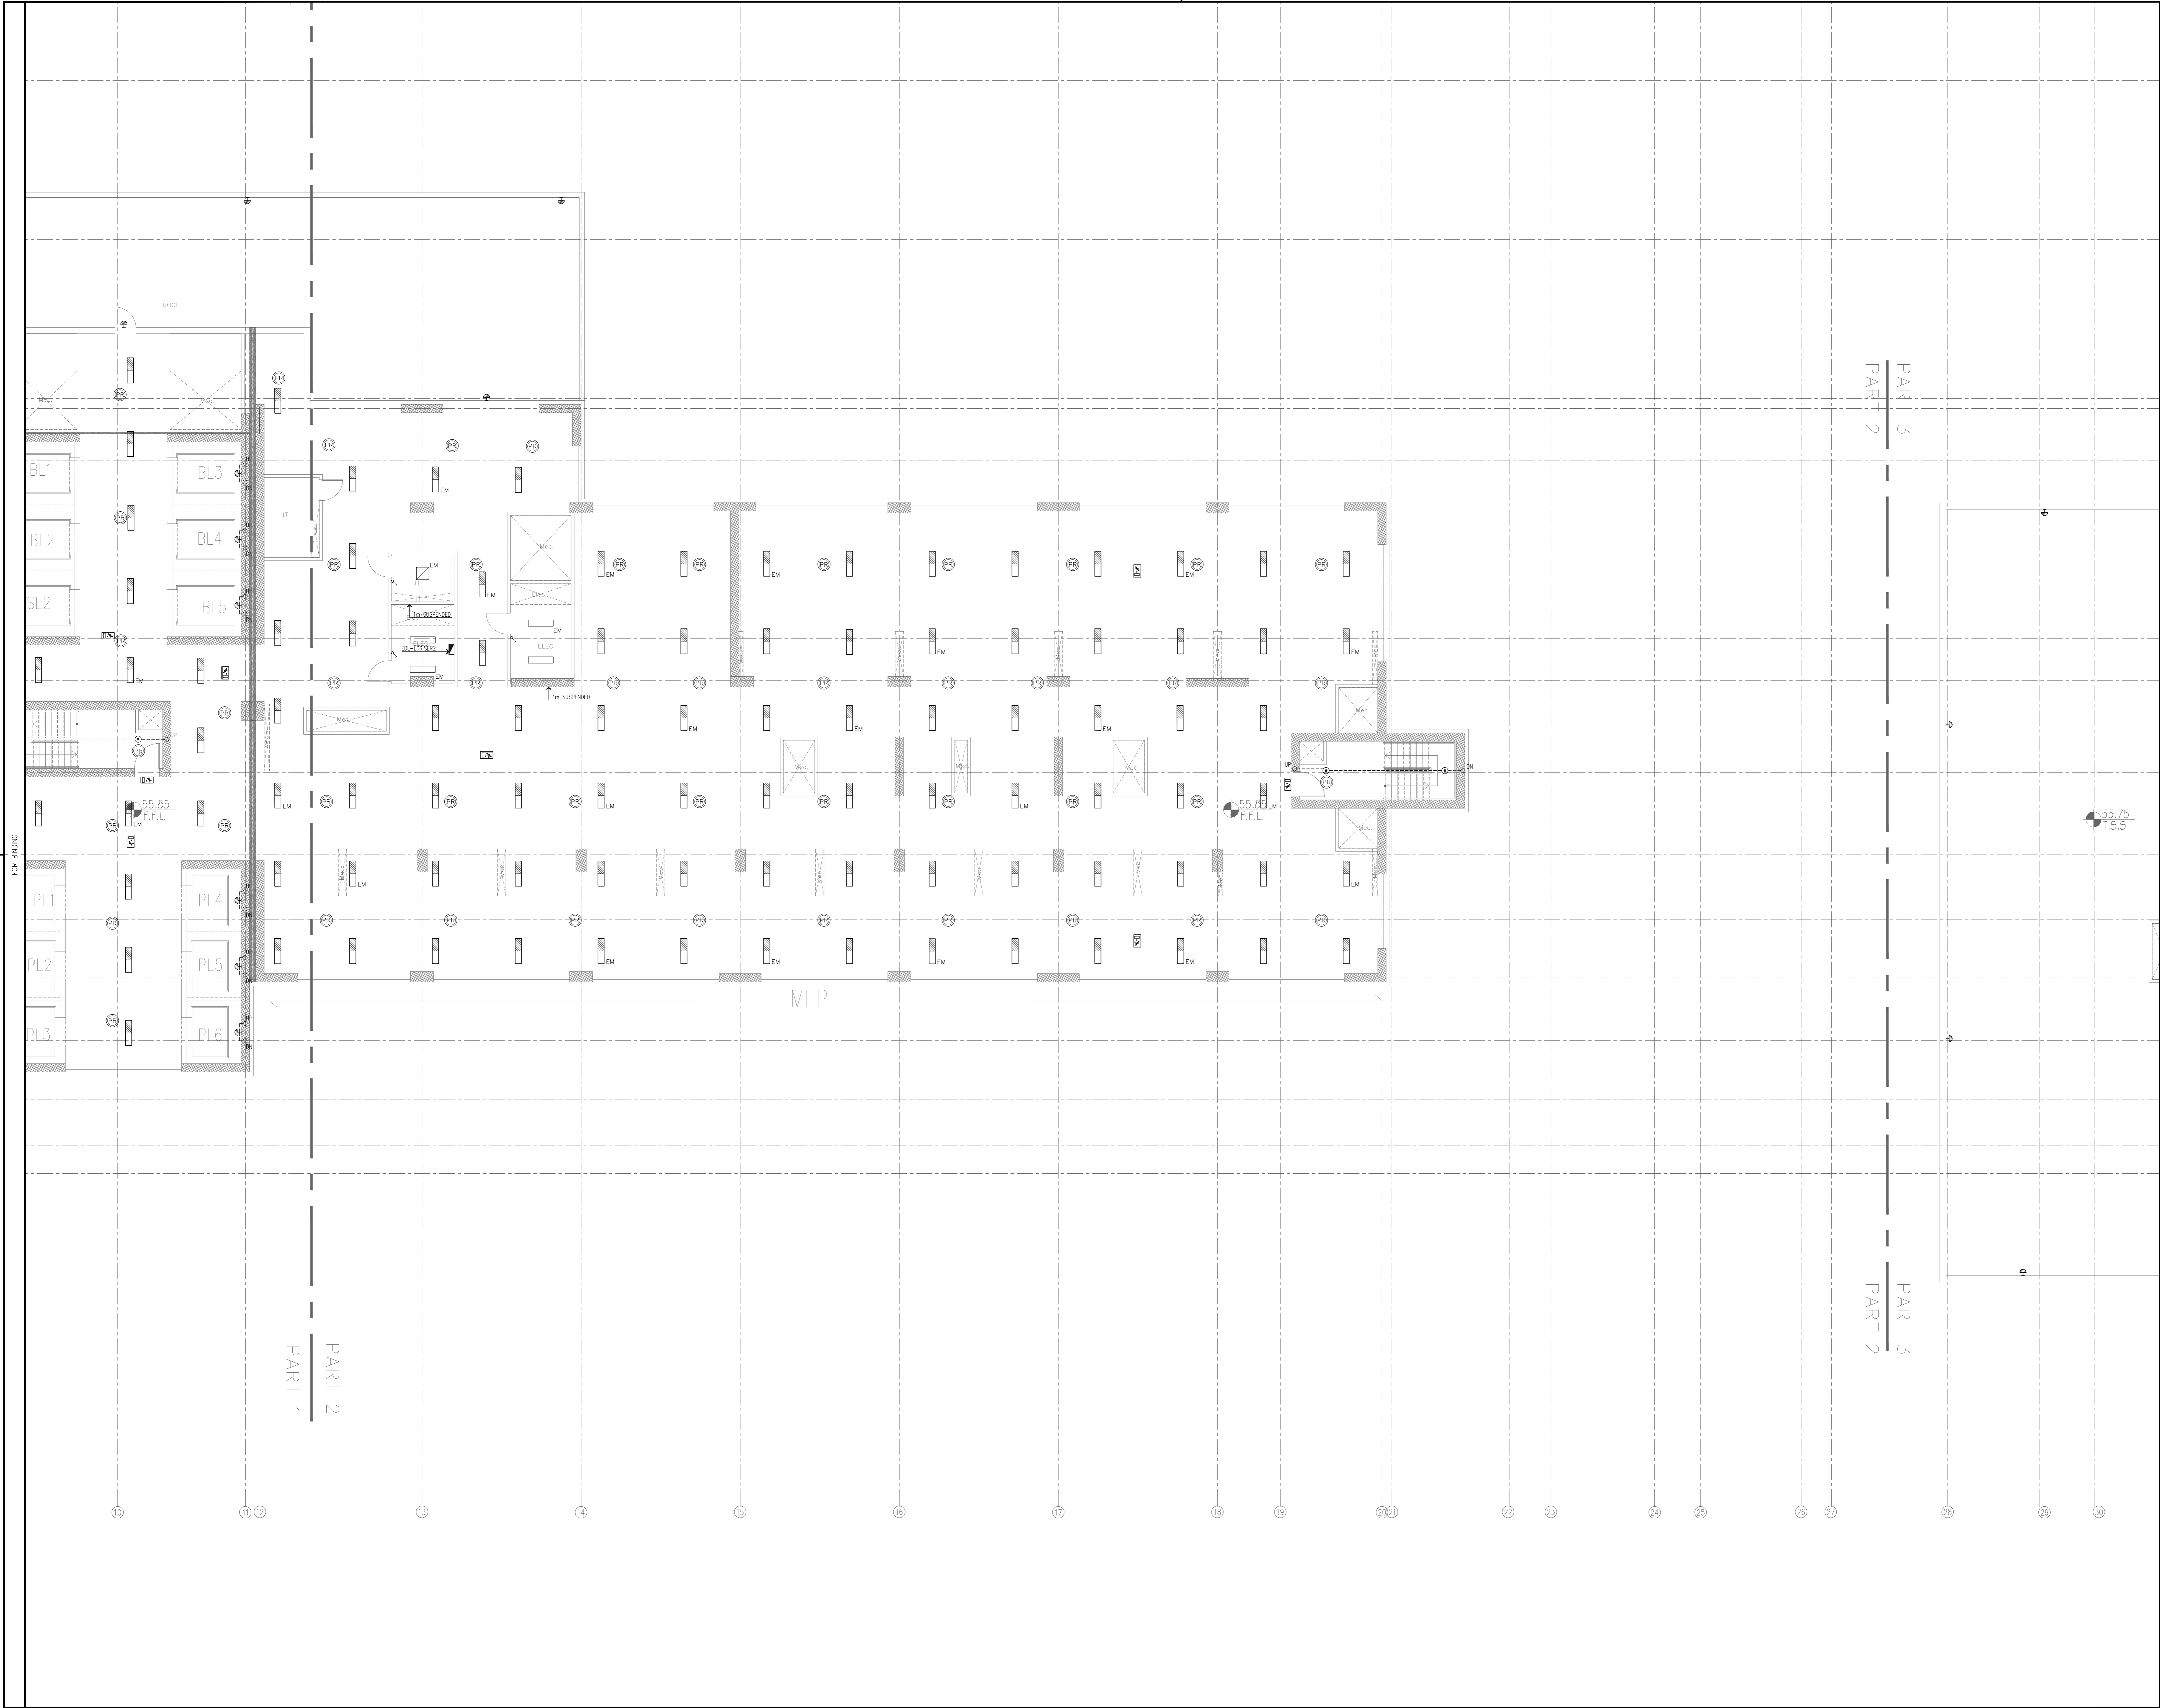

General Notes :

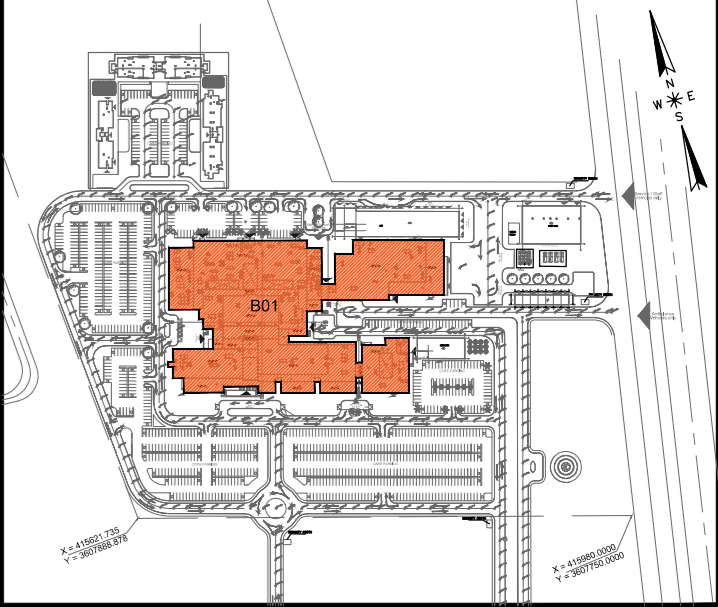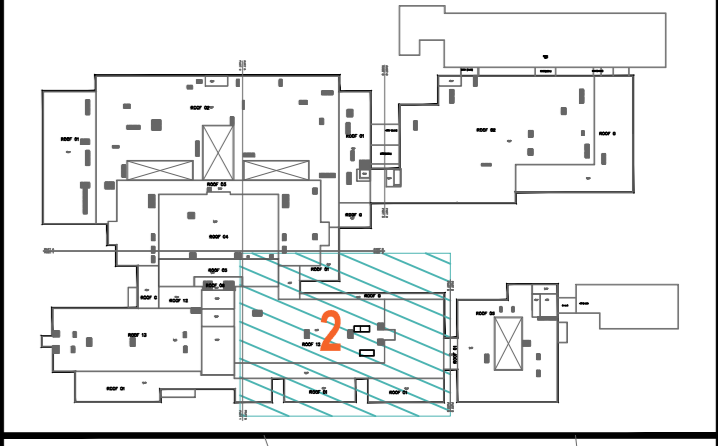

OWNER:
MINISTRY OF HIGHER EDUCATION
AND SCIENTIFIC RESEARCH
University Of Karbala



PROJECT MANAGEMENT CONSULTANT:
AM TECH

MAIN CONTRACTOR:
FOURTH DIMENSION
Controlling Engineering & Construction

PRINCIPAL ENGINEERING CONSULTANT:
ARABTECH JARDANEH

CONSULTING HEALTH PLANNERS:
HDP healthcare designers
and project managers

CONSULTING INTERNATIONAL ARCHITECTS:
LEO A DALY PLANNING ARCHITECTURE ENGINEERING INTERIORS

THIS DRAWING IS THE
COPYRIGHT OF ARABTECH
JARDANEH ENGINEERS &
ARCHITECTS AND MUST NOT BE
REPRODUCED, COPIED OR USED
WITHOUT THE CONSULTANTS'
AUTHORIZATION

REV.	DESCRIPTION	APPRO. BY	DATE


DRAWN BY: E.D. DESIGNED BY: H.O.M.S.H.
CHECKED BY: M.K.H. APPROVED BY: F.J.
QC REVIEW BY: B.M. DWG ISSUE DATE: 26.10.2014

PROJECT:
**KARBALA 600 BED TEACHING
UNIVERSITY HOSPITAL, IRAQ**



CONCEPT DESIGN STAGE
PRELIMINARY DESIGN STAGE
DESIGN DEVELOPMENT STAGE
CONSTRUCTION DRAWINGS STAGE

DRAWING TITLE:
**SIXTH FLOOR PLAN
LIGHTING LAYOUT
PART 2**

A01 01586 DWG: KUH-EL-142 BLOCK: B01
1:100 Sht. 02 of 03 REV: R0

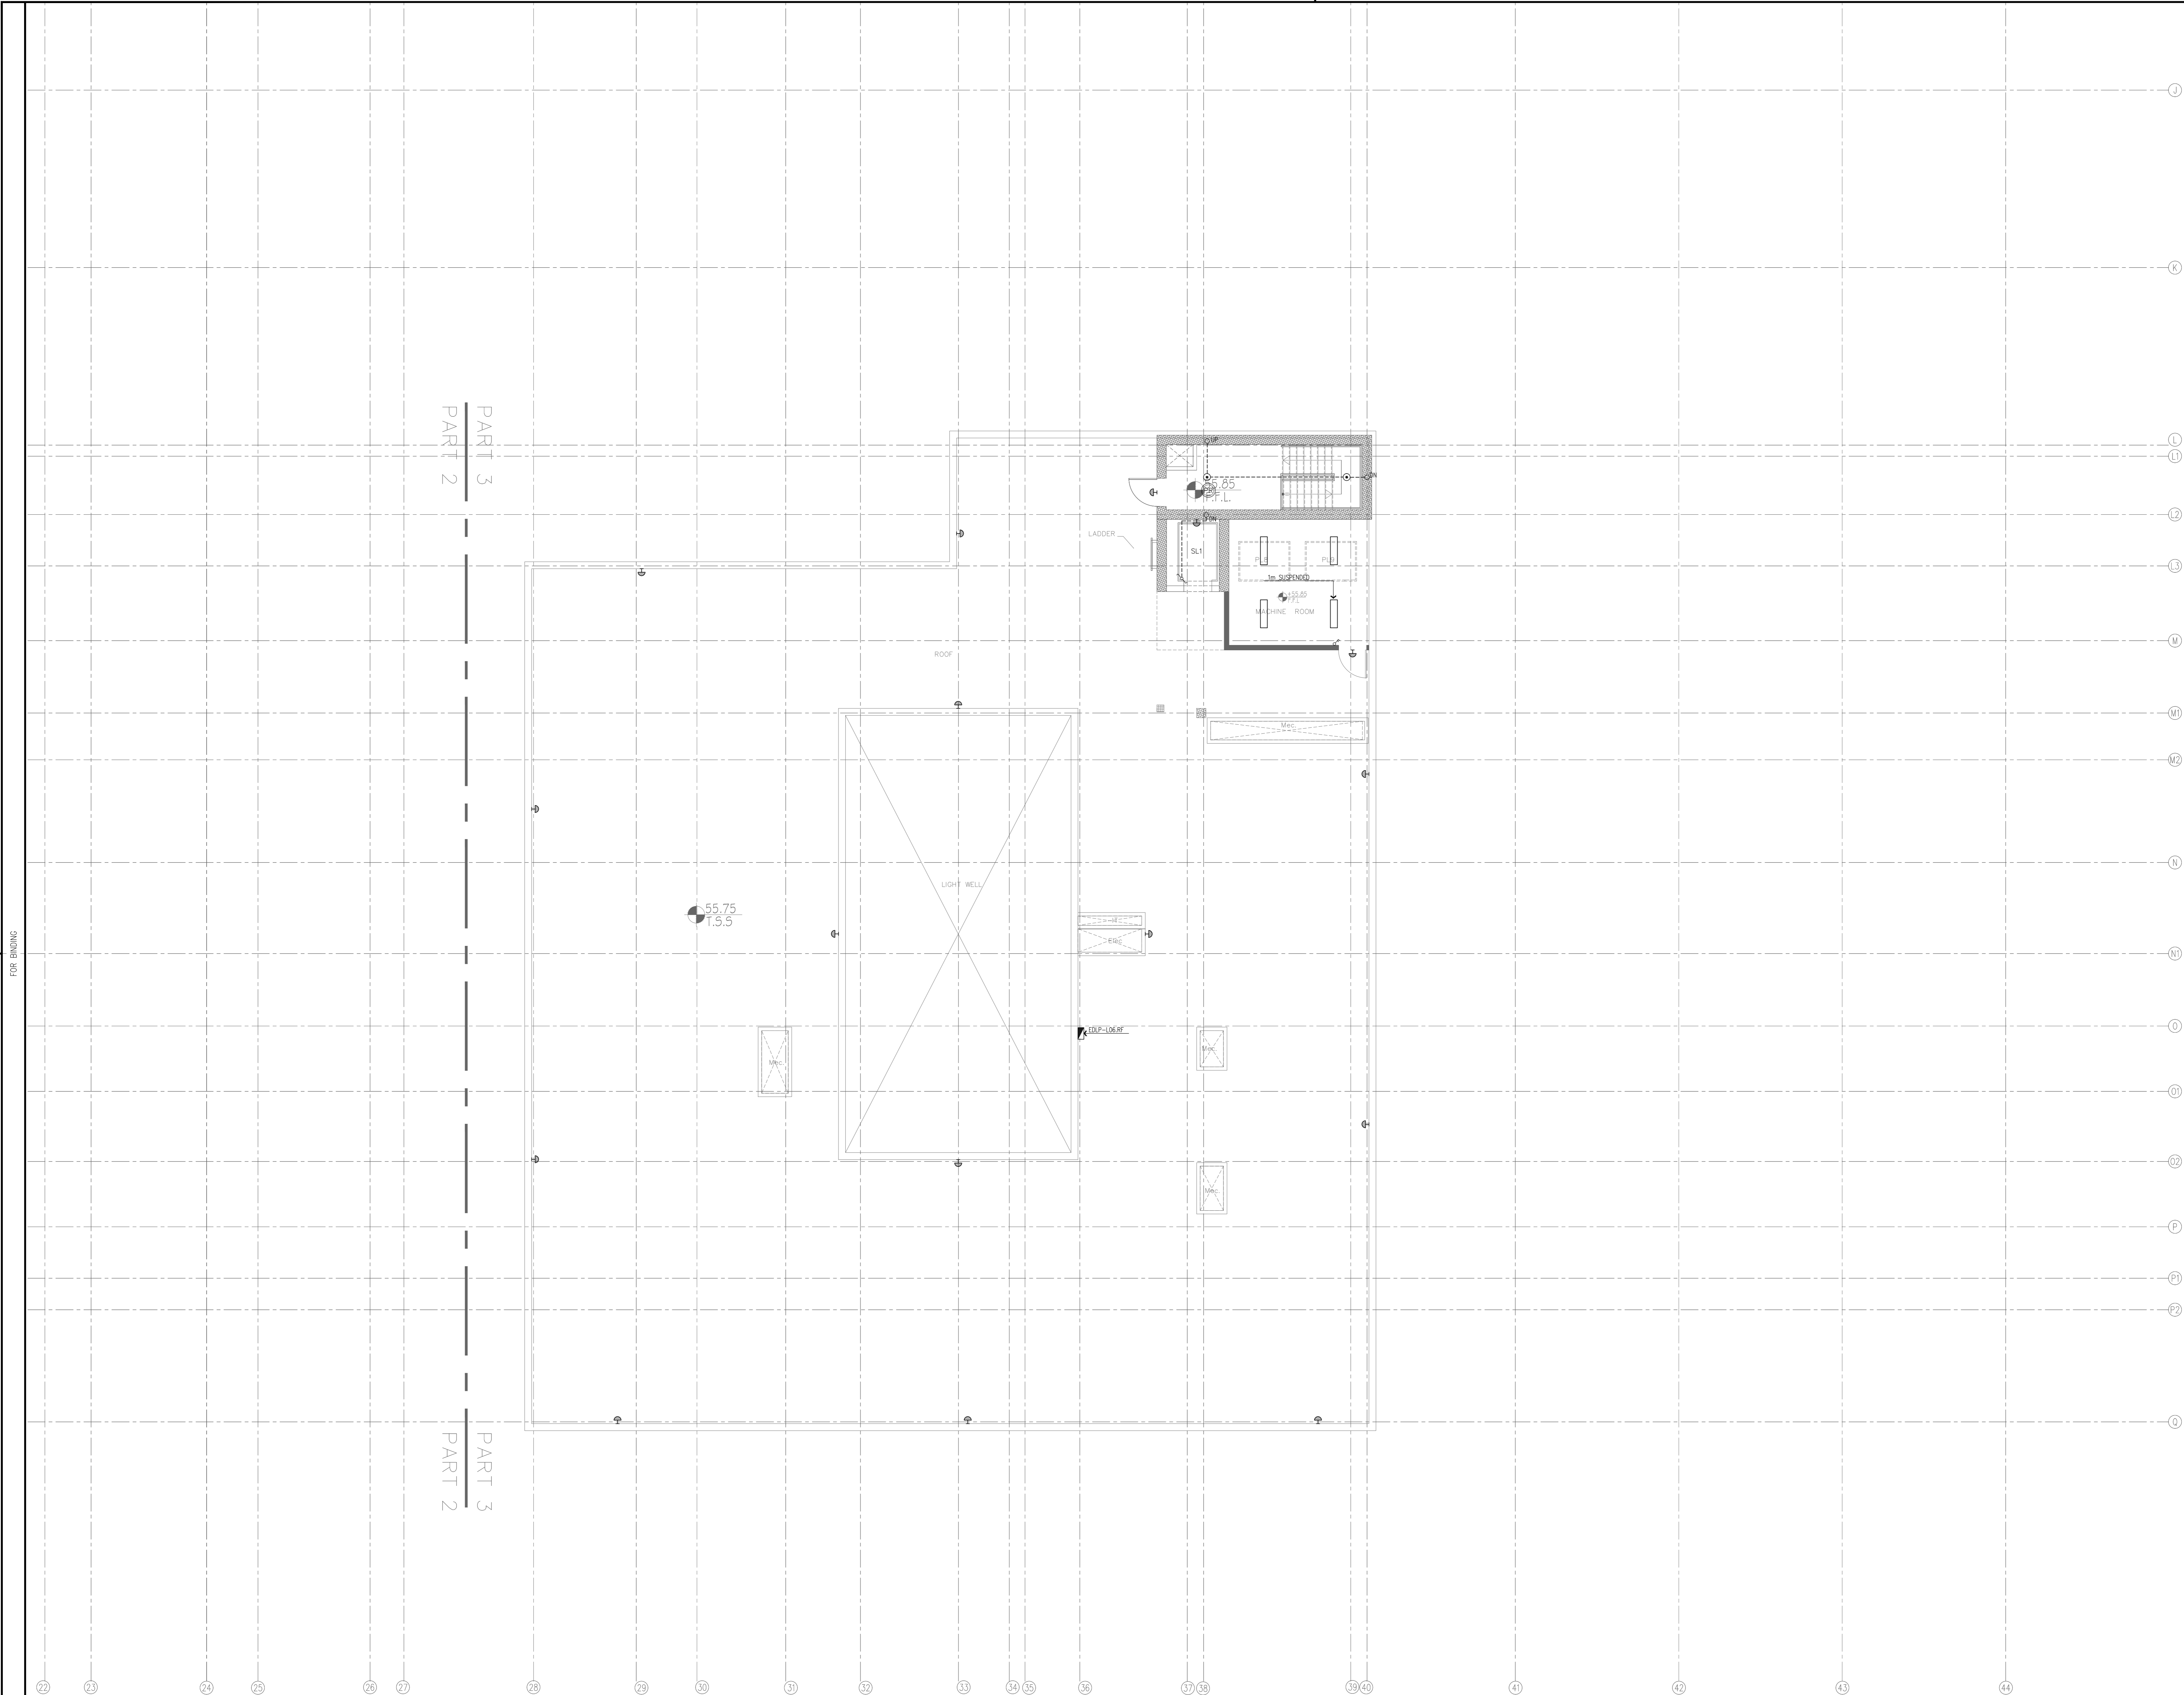

General Notes :

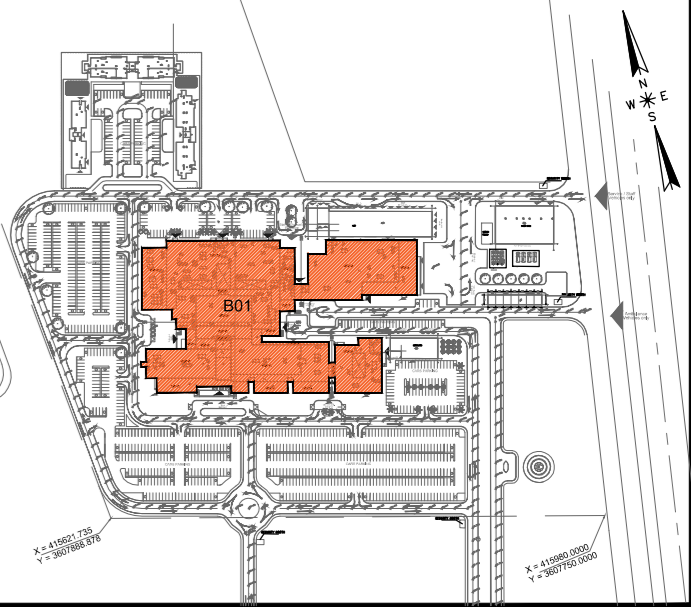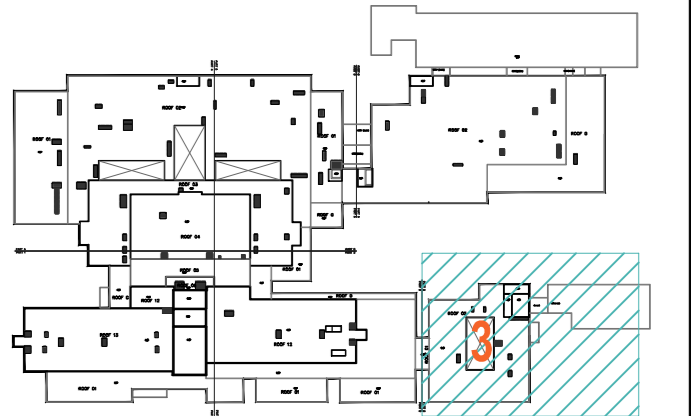

MINISTRY OF HIGHER EDUCATION
AND SCIENTIFIC RESEARCH
University Of Karbala



PROJECT MANAGEMENT CONSULTANT :
AM TECH

MAIN Contractor :
FOURTH DIMENSION
Consulting Engineering & Construction

PRINCIPAL ENGINEERING CONSULTANT :
ARABTECH JARDANEH

CONSULTING HEALTH PLANNERS :
HDP healthcare designers
and project managers

CONSULTING INTERNATIONAL ARCHITECTS :
LEO A DALY
PLANNING ARCHITECTURE ENGINEERING INTERIORS

THIS DRAWING IS THE
COPYRIGHT OF ARABTECH
JARDANEH ENGINEERS &
ARCHITECTS AND MUST NOT BE
REPRODUCED, COPIED OR USED
WITHOUT THE CONSULTANTS'
AUTHORIZATION

REV.	DESCRIPTION	APPRO. BY	DATE

DRAWN BY: E.D	DESIGNED BY: H.O/M.S.H
CHECKED BY: M.K.H	APPROVED BY: F.J
QC REVIEW BY: B.M	DWG ISSUE DATE: 26.10.2014


PROJECT:	
KARBALA 600 BED TEACHING UNIVERSITY HOSPITAL, IRAQ	
CONCEPT DESIGN STAGE	PRELIMINARY DESIGN STAGE
DESIGN DEVELOPMENT STAGE	CONSTRUCTION DRAWINGS STAGE

DRAWING TITLE:



SIXTH FLOOR PLAN
LIGHTING LAYOUT
PART 3

A01	01586	DWG:	KUH-EL-143	BLOCK	B01
1:100	01	03	03	REV.	R0

FOR BUILDING

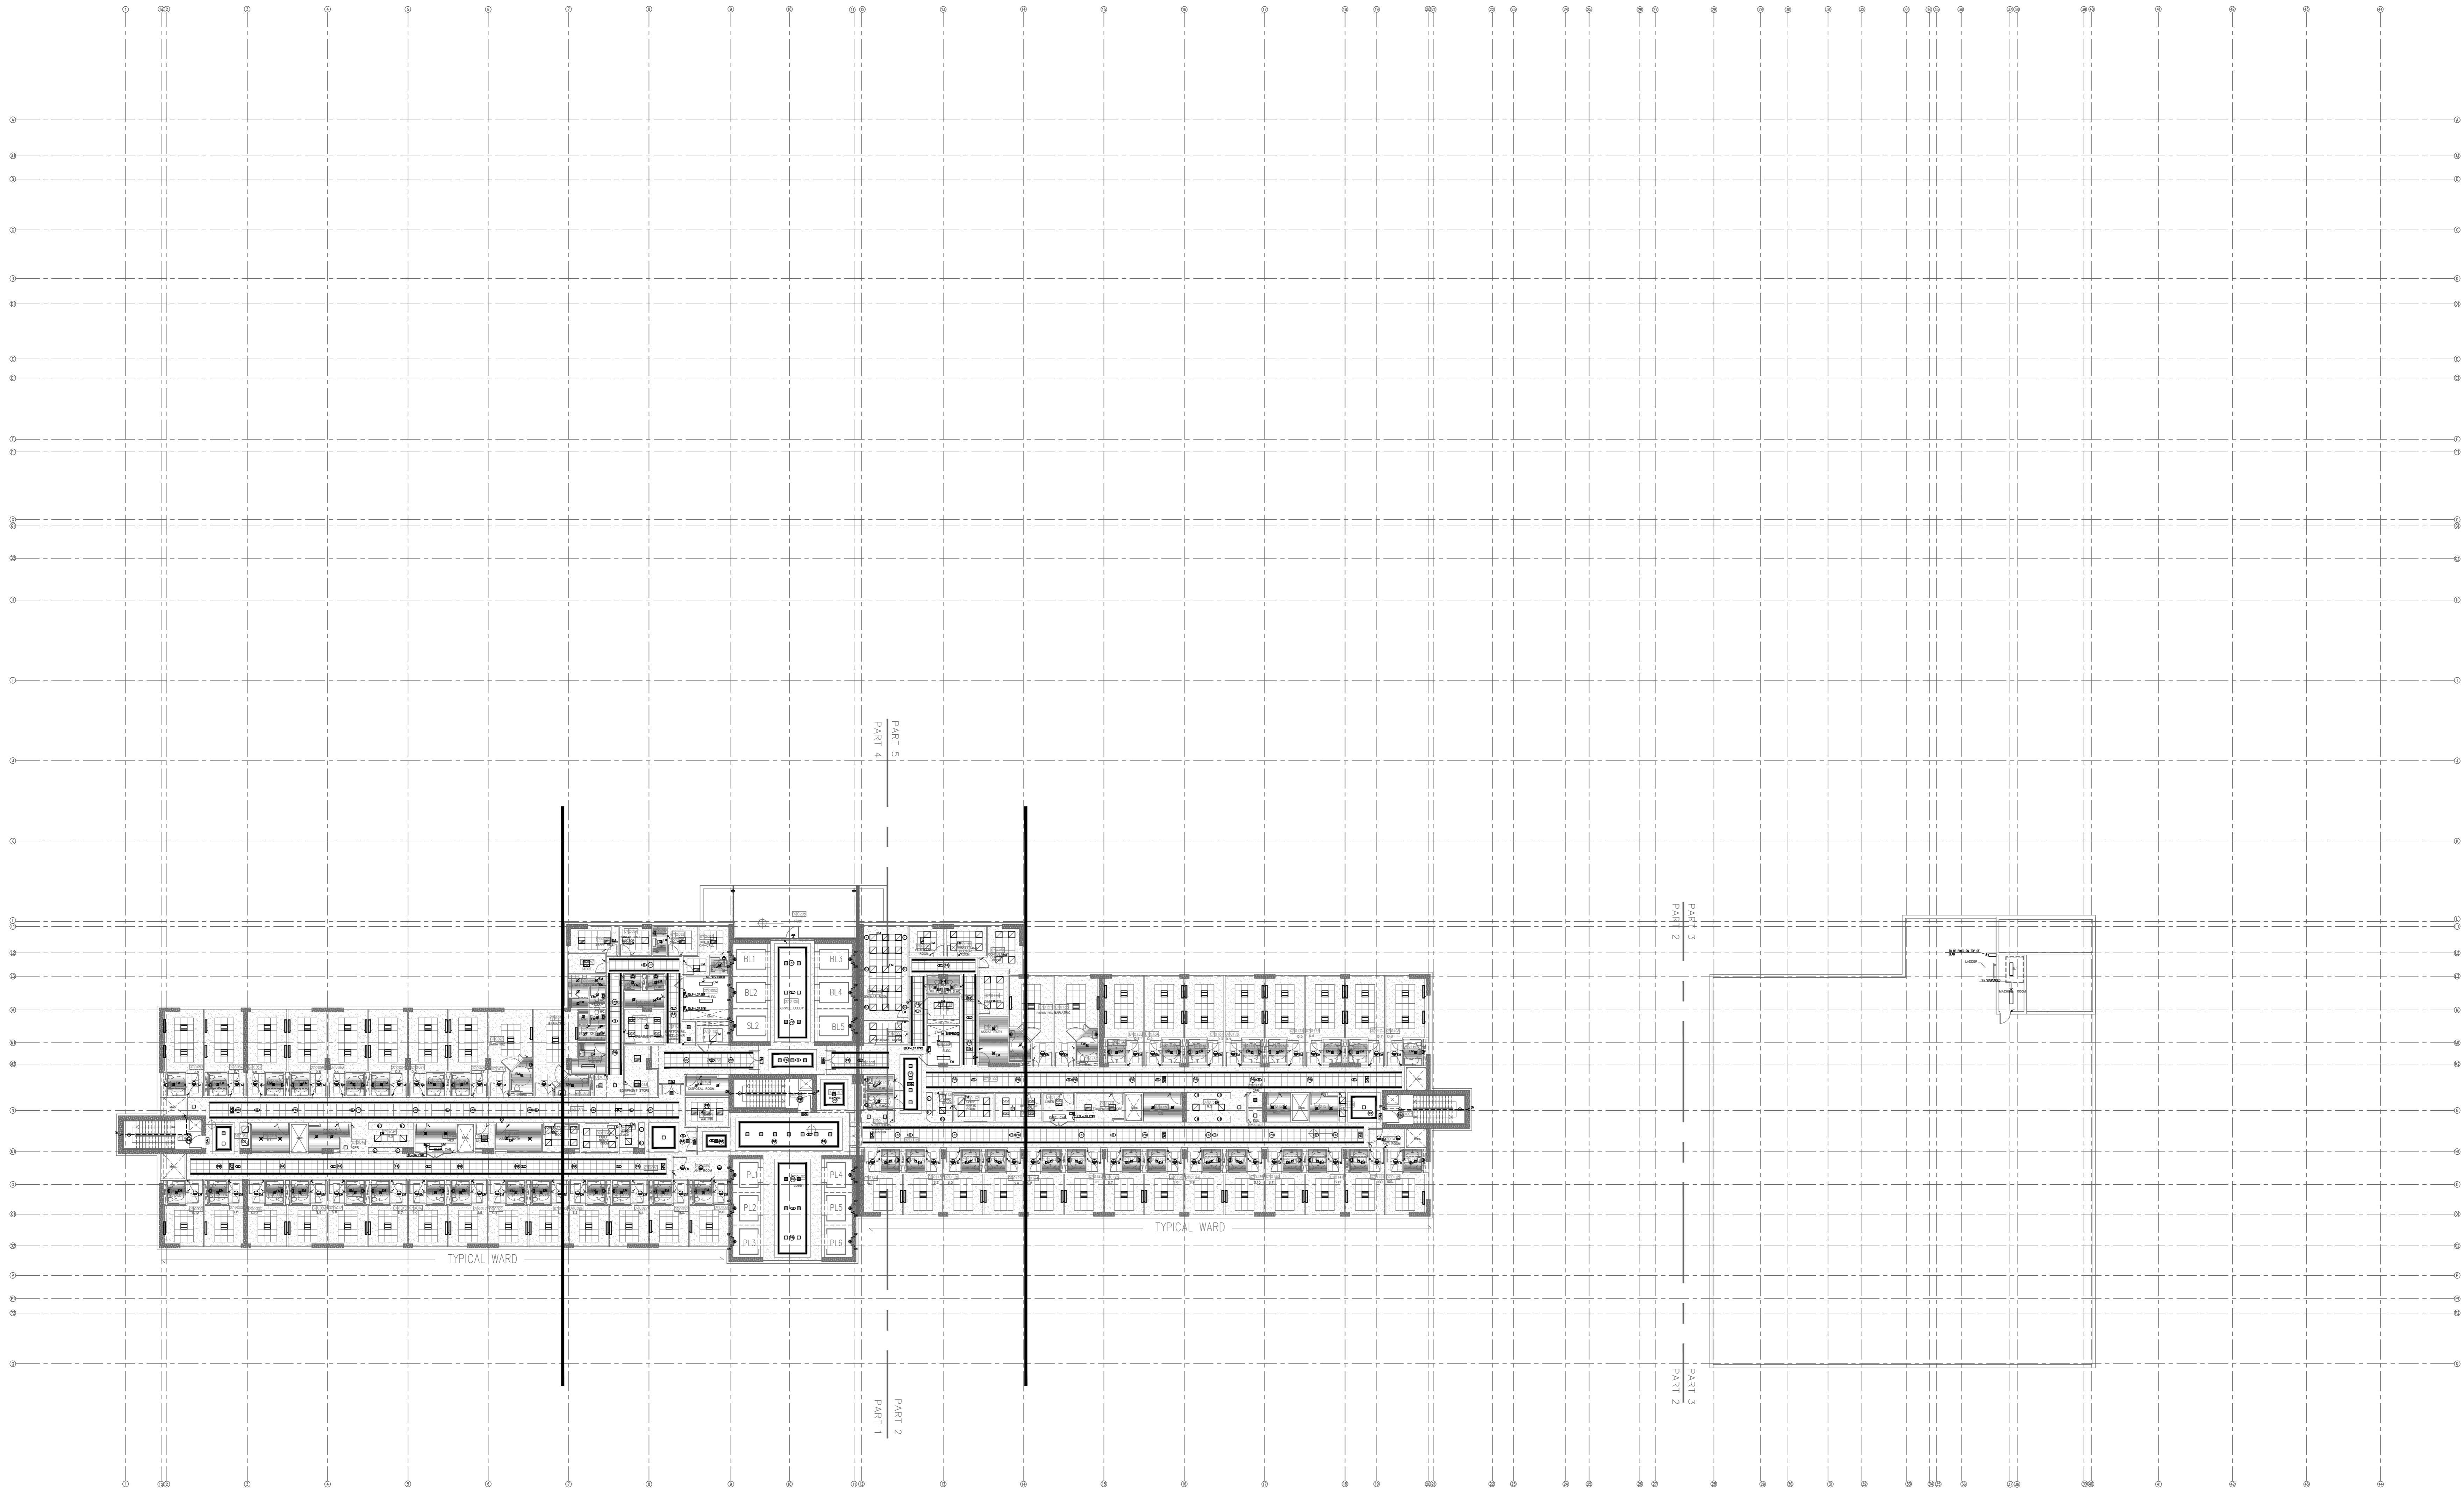

General Notes :

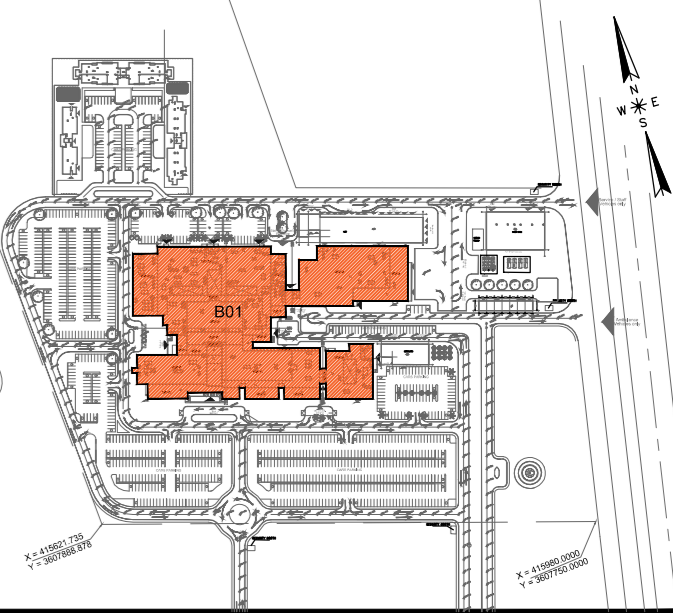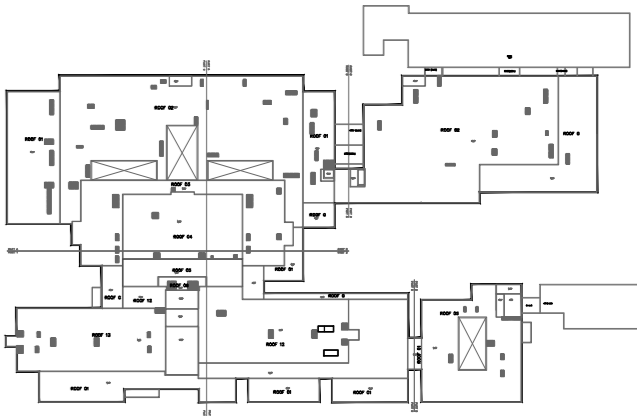

OWNER:
MINISTRY OF HIGHER EDUCATION
AND SCIENTIFIC RESEARCH
University Of Karbala



PROJECT MANAGEMENT CONSULTANT:
AM TECH

MAIN Contractor :
FOURTH DIMENSION
Consulting Engineering & Construction
CIS.C

PRINCIPAL ENGINEERING CONSULTANT:
ARABTECH JARDANEH

CONSULTING HEALTH PLANNERS:
HDP healthcare designers
and project managers

CONSULTING INTERNATIONAL ARCHITECTS:
LEO A DALY
PLANNING ARCHITECTURE ENGINEERING INTERIORS

THIS DRAWING IS THE
COPYRIGHT OF ARABTECH
JARDANEH ENGINEERS &
ARCHITECTS AND MUST NOT BE
REPRODUCED, COPIED OR USED
WITHOUT THE CONSULTANTS'
AUTHORIZATION

REV.	DESCRIPTION	APPRO. BY	DATE

DRAWN BY: E.D. DESIGNED BY: H.O./M.S.H.
CHECKED BY: M.K.H. APPROVED BY: F.J.
QC REVIEW BY: B.M. DWG ISSUE DATE: 26.10.2014


PROJECT:
**KARBALA 600 BED TEACHING
UNIVERSITY HOSPITAL, IRAQ**

CONCEPT DESIGN STAGE PRELIMINARY DESIGN STAGE
DESIGN DEVELOPMENT STAGE CONSTRUCTION DRAWINGS STAGE

DRAWING TITLE:

**SEVENTH FLOOR PLAN
LIGHTING LAYOUT
OVERALL**

A0B 01586 DWG: KUH-EL-144 BLOCK B01
1:250 1/4" (A0) Sht. 01 of 01 REV. RO

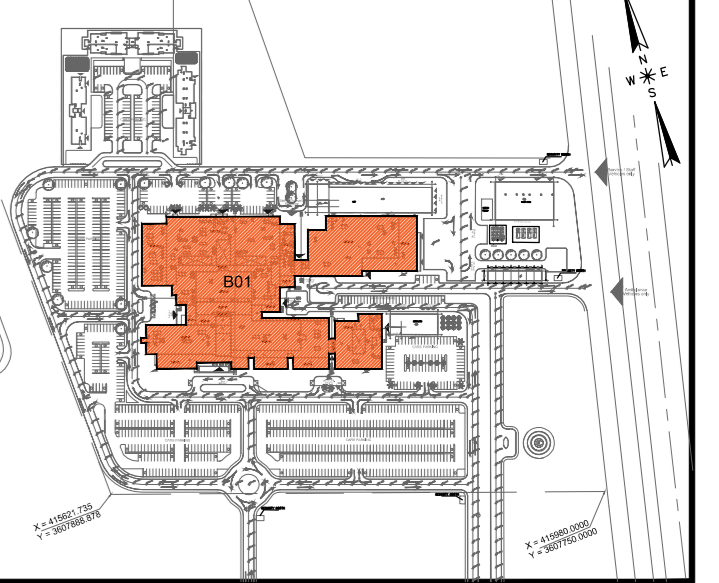

PROJECT MANAGEMENT CONSULTANT :

 **AM
TECH**

MAIN Contractor :



FOURTH DIMENSION
Contracting Engineering procurement



C/B.C.

PRINCIPAL ENGINEERING CONSULTANT :
ARABTECH JARDANEH

HDP | healthcare designers
and project managers

CONSULTING INTERNATIONAL ARCHITECTS :

LEO A DALY PLANNING ARCHITECTURE ENGINEERING INTERIORS

THIS DRAWING IS THE
COPYRIGHT OF ARABTECH
JARDANEH ENGINEERS &
ARCHITECTS AND MUST NOT BE
RETAINED, COPIED OR USED
WITHOUT THE CONSULTANTS'
AUTHORIZATION

[illegible]

DRAWN BY:	E.D	DESIGNED BY:	H.O/M.SH
CHECKED BY:	M.KH	APPROVED BY:	F.J
QC REVIEW BY:	B.M	DWG ISSUE DATE: 26.10.2014	


PROJECT:
KARBALA 600 BED TEACHING
UNIVERSITY HOSPITAL, IRAQ

DESIGN DEVELOPMENT STAGE	CONSTRUCTION DRAWINGS STAGE
DRAWING TITLE:	

SEVENTH FLOOR PLAN
LIGHTING LAYOUT
PART 1

01586	DWG KUH- EL-145	BLOCK * B01
1:100 @ (A0)	Sht. 01 of 02	REV. * R0

A floor plan of a building with various rooms labeled. A red number '2' is placed in a central corridor area, which is also highlighted with blue diagonal hatching. This area is located between a large room on the left and a smaller room on the right.

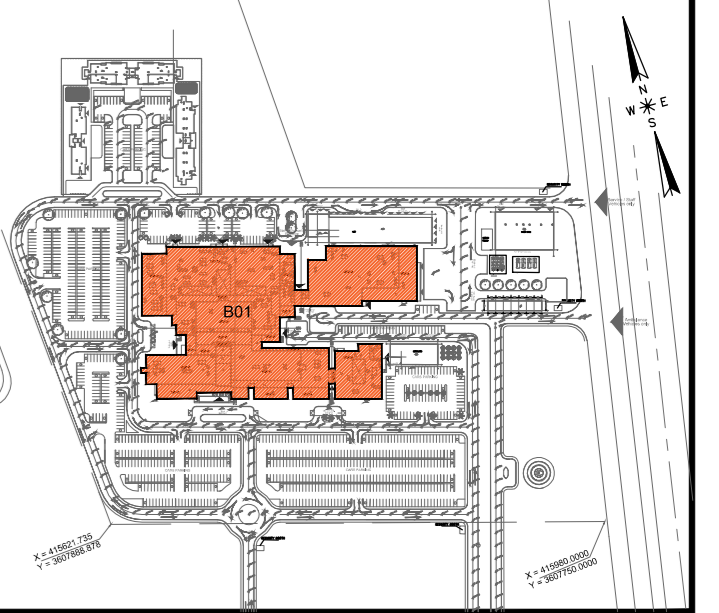

MAIN Contractor : 

FOURTH DIMENSION
Contracting Engineering procurement



C.B.C

HDP | healthcare designers
and project managers

CONSULTING INTERNATIONAL ARCHITECTS :
LEO A DALY PLANNING ARCHITECTURE ENGINEERING INTERIORS

[illegible]

PROJECT:
KARBALA 600 BED TEACHING
UNIVERSITY HOSPITAL, IRAQ


CONCEPT DESIGN STAGE	PRELIMINARY DESIGN STAGE
DESIGN DEVELOPMENT STAGE	CONSTRUCTION DRAWINGS STAGE

DRAWING TITLE:



01586	DWG KUH-EL-146	BLOCK * B01
1:100 @ (A0)	Sh. 02 of 02	REV. * R0

SAVED BY: Afif.alsayed ON: 25.10.2014 @ 09:03 CAD FILE NAME: 01586-EL-146-B01-R0.DWG

FOR BUILDING

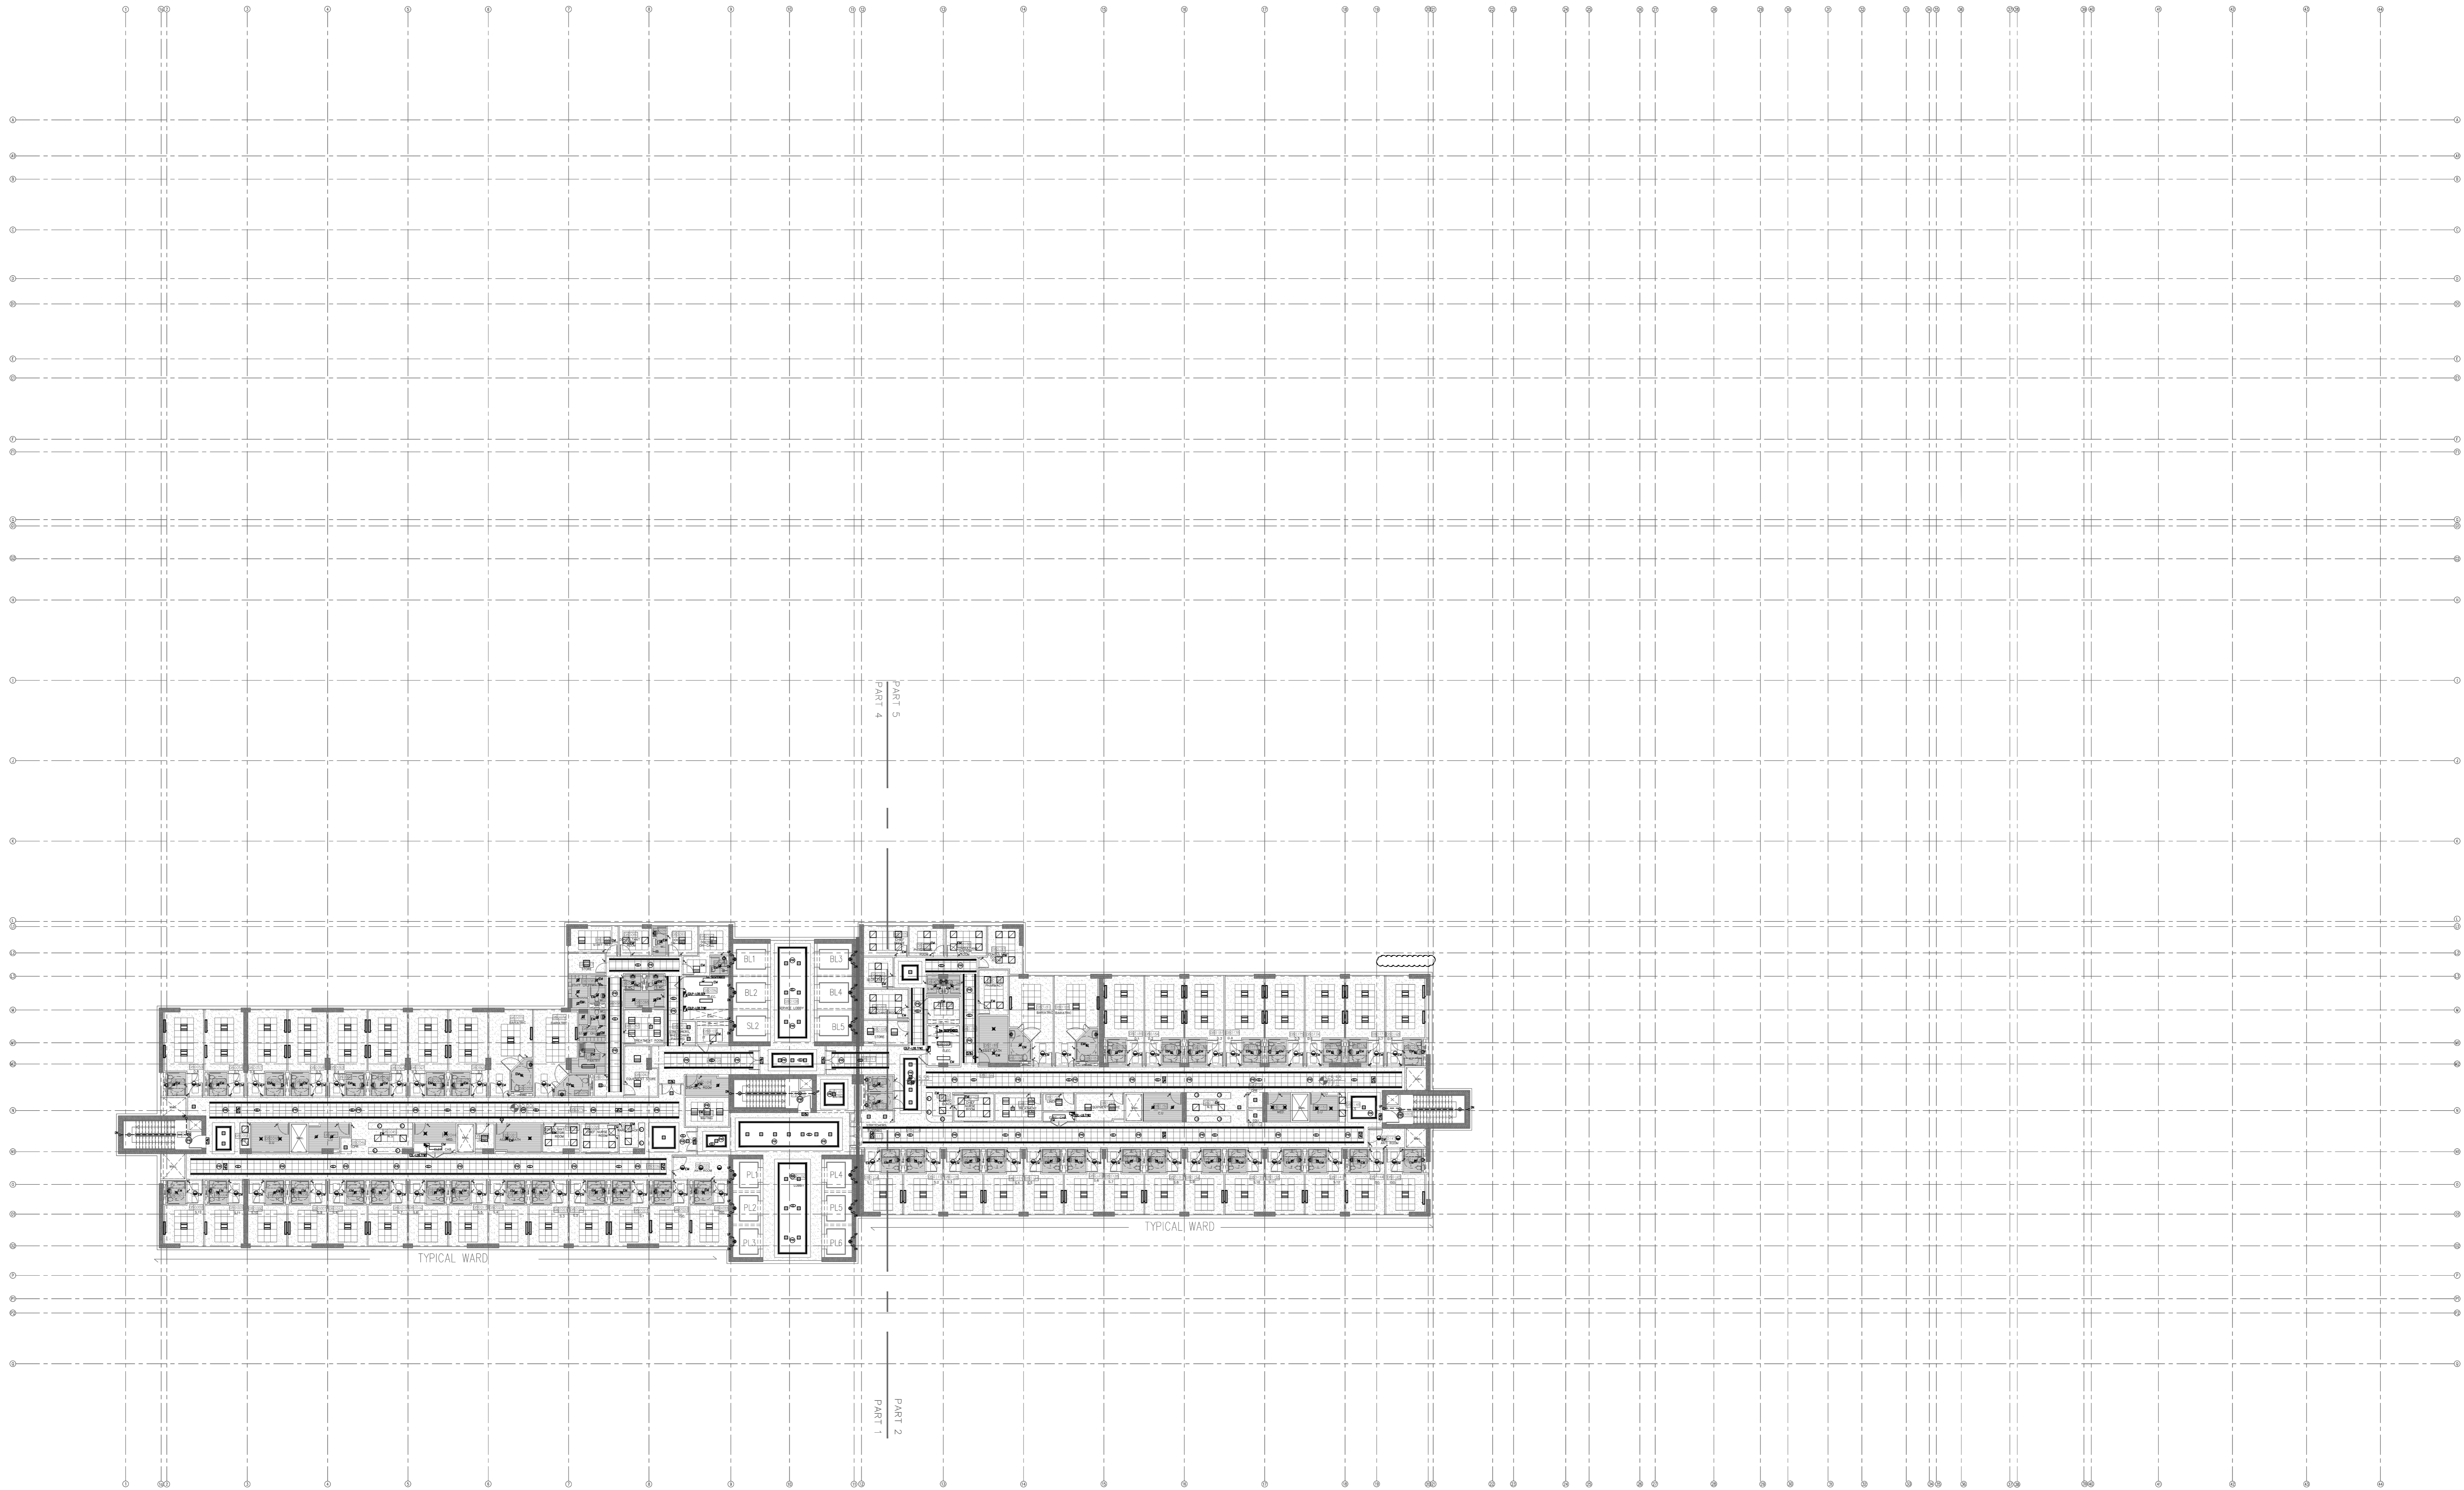

General Notes :

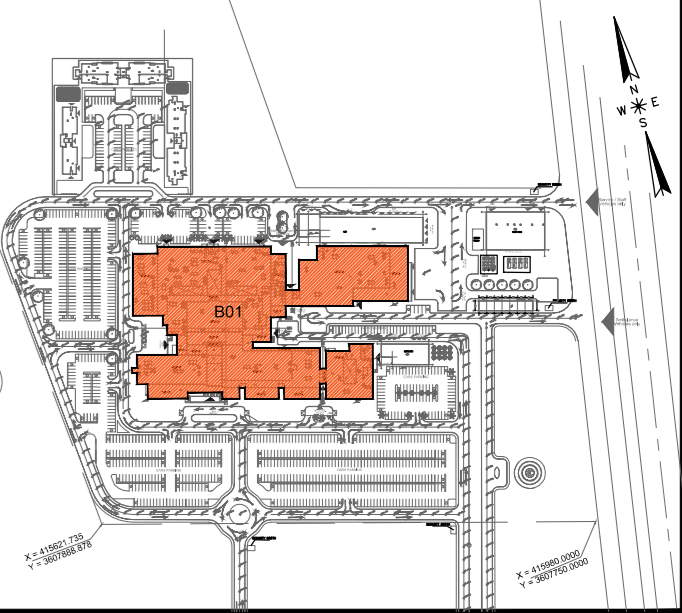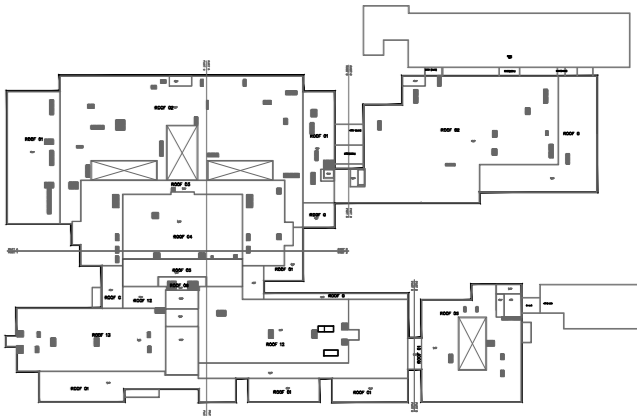

MINISTRY OF HIGHER EDUCATION
AND SCIENTIFIC RESEARCH
University Of Karbala



PROJECT MANAGEMENT CONSULTANT
**AM
TECH**

MAIN Contractor :
FOURTH DIMENSION
Consulting Engineering & Construction
C/E

PRINCIPAL ENGINEERING CONSULTANT :
ARABTECH JARDANEH

CONSULTING HEALTH PLANNERS :
HDP healthcare designers
and project managers

CONSULTING INTERNATIONAL ARCHITECTS :
LEO A DALY
PLANNING ARCHITECTURE ENGINEERING INTERIORS

THIS DRAWING IS THE
COPYRIGHT OF ARABTECH
JARDANEH ENGINEERS &
ARCHITECTS AND MUST NOT BE
REPRODUCED, COPIED OR USED
WITHOUT THE CONSULTANTS'
AUTHORIZATION

REV.	DESCRIPTION	APPRO. BY	DATE

DRAWN BY: E.D. DESIGNED BY: H.O.M.S.H.
CHECKED BY: M.K.H. APPROVED BY: F.J.
QC REVIEW BY: B.M. DWG ISSUE DATE: 26.10.2014


PROJECT:
**KARBALA 600 BED TEACHING
UNIVERSITY HOSPITAL, IRAQ**

CONCEPT DESIGN STAGE PRELIMINARY DESIGN STAGE
DESIGN DEVELOPMENT STAGE CONSTRUCTION DRAWINGS STAGE

DRAWING TITLE:

**EIGHTH FLOOR PLAN
LIGHTING LAYOUT
OVERALL**

A0B 01586 DWG KUH-EL-147 BLOCK B01
1:250 1st of 01 REV. RO

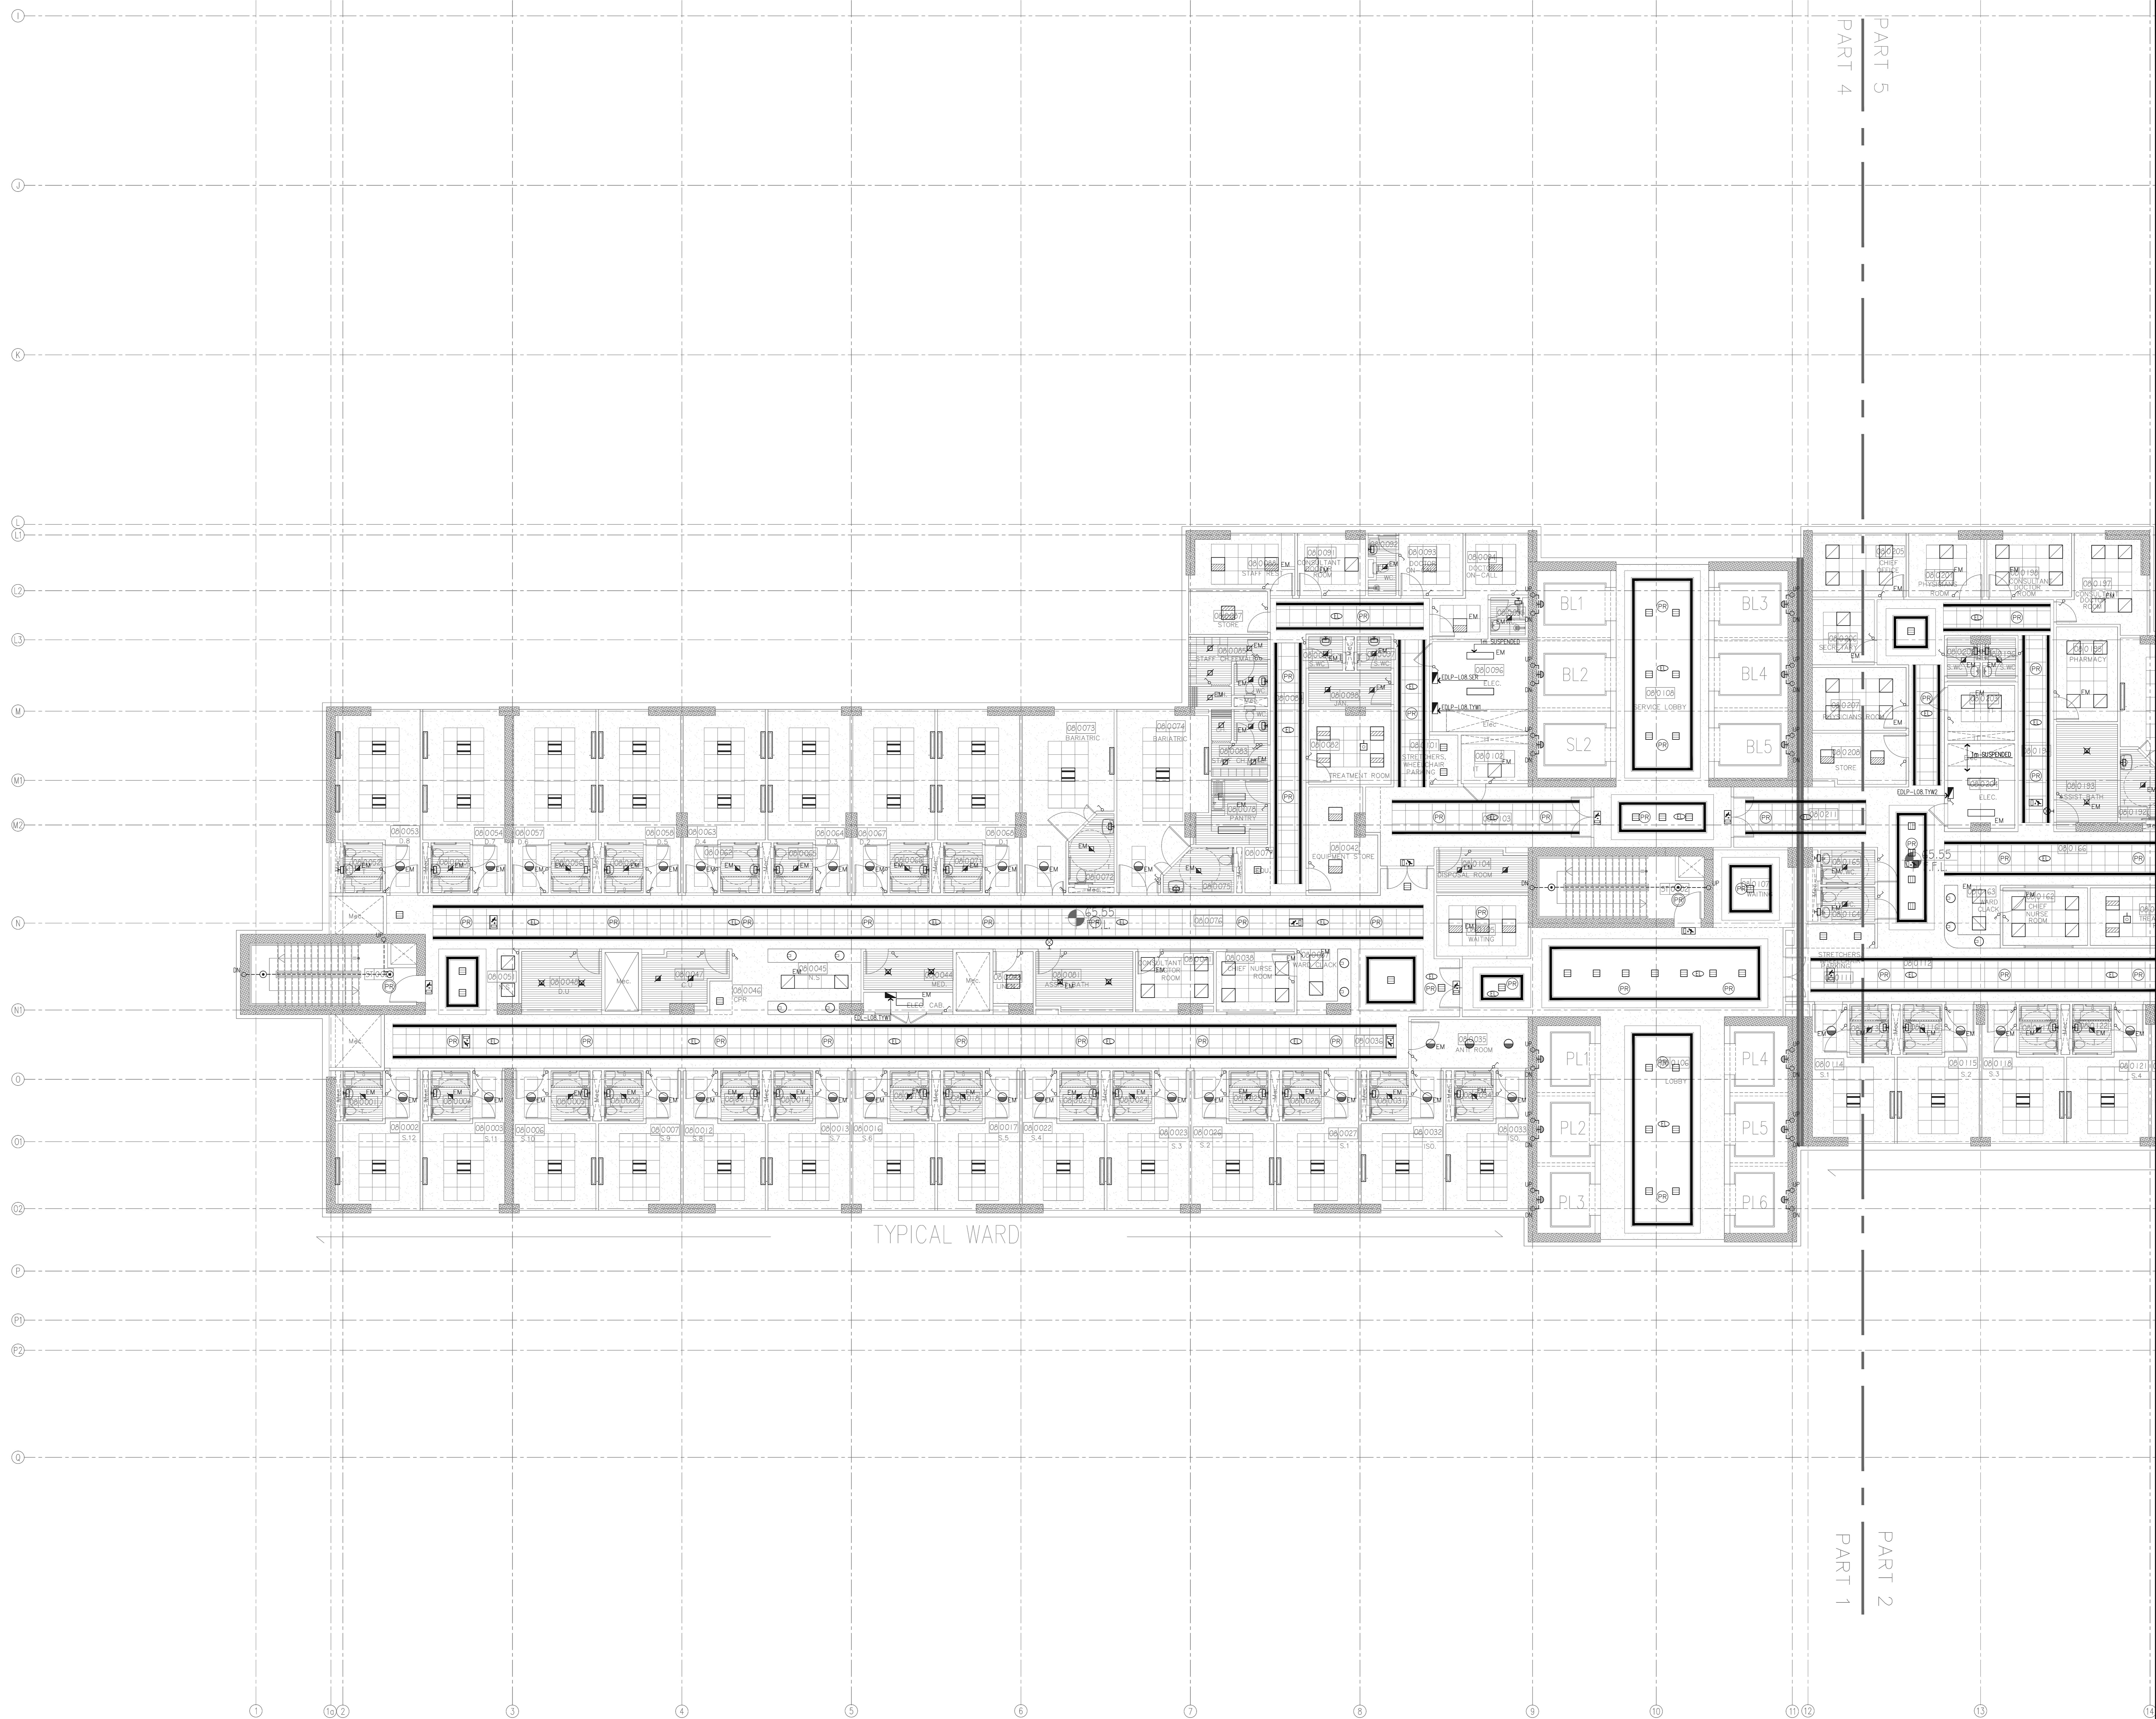

General Notes :

MINISTRY OF HIGHER EDUCATION
AND SCIENTIFIC RESEARCH
University OF Karbala

PROJECT MANAGEMENT CONSULTANT

MAIN Contractor

PRINCIPAL ENGINEERING CONSULTANT


HDP | healthcare designers
and project managers

THIS DRAWING IS THE
COPYRIGHT OF ARABTECH
JARDANEH ENGINEERS &
ARCHITECTS AND MUST NOT BE
RETAINED, COPIED OR USED
WITHOUT THE CONSULTANTS'
AUTHORIZATION

DRAWN BY: E.D	DESIGNED BY: H.O/M.S
CHECKED BY: M.KH	APPROVED BY: F.J
QC REVIEW BY: B.M	DWG ISSUE DATE: 26.10.2

EIGHTH FLOOR PLAN
LIGHTING LAYOUT
PART 1

A floor plan of a building with various rooms and corridors. A specific area in the lower-left quadrant is highlighted with blue diagonal hatching and a large red number '2' in the center. This area appears to be a small room or a section of a larger room.

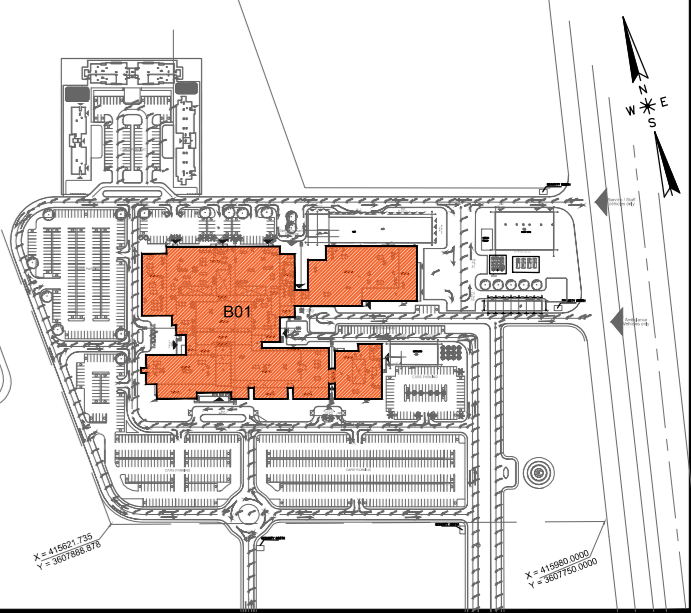

MAIN Contractor :  

CONSULTING HEALTH PLANNERS :

HDP | healthcare designers
and project managers

THIS DRAWING IS THE
COPYRIGHT OF ARABTECH
JARDANEH ENGINEERS &
ARCHITECTS AND MUST NOT BE
RETAINED, COPIED OR USED
WITHOUT THE CONSULTANTS'
AUTHORIZATION

[illegible]

PROJECT:
KARBALA 600 BED TEACHING
UNIVERSITY HOSPITAL, IRAQ

CONCEPT DESIGN STAGE	PRELIMINARY DESIGN STAGE
DESIGN DEVELOPMENT STAGE	CONSTRUCTION DRAWINGS STAGE

DRAWING TITLE:

EIGHTH FLOOR PLAN

LIGHTING LAYOUT

PART 2


	DWG	
--	-----	--

01586	KUH-EL-149	BLOCK * B01
-------	------------	----------------

1:100	⊗ (A0)	Sh.	02	of	02	REV. #	R0
-------	--------	-----	----	----	----	-----------	----

CAD FILE NAME: 01586-EL-149-B01-R0.DWG

THIS DRAWING IS THE COPYRIGHT OF ARABTECH JARDANEH ENGINEERS & ARCHITECTS AND
MUST NOT BE RETAINED, COPIED OR USED WITHOUT THE CONSULTANT'S AUTHORIZATION

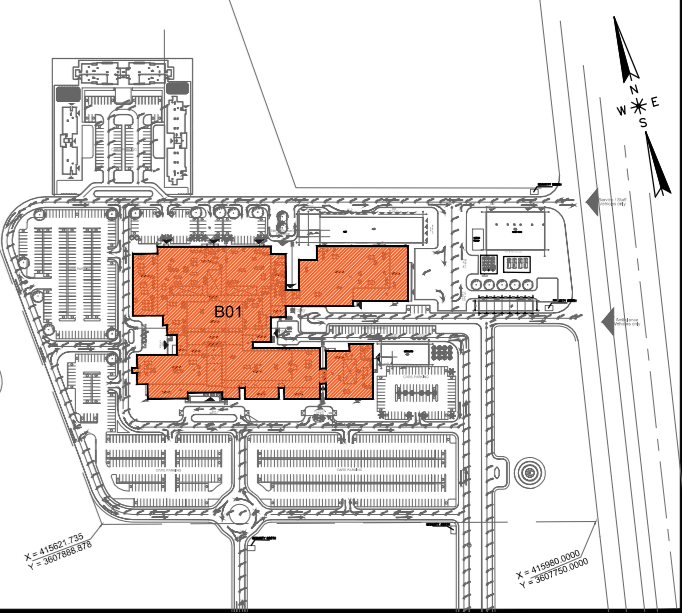

وزارة التعليم العالي والبحث العلمي
Ministry of Higher Education & Scientific Research



4TH DIMENSION
Sourcing Engineering procurement

ARABTECH JARDANEH

HDP | healthcare designers
and project managers

EO ADALY PLANNING ARCHITECTURE ENGINEERING INTERIORS

[illegible]

PROJECT:
KARBALA 600 BED TEACHING
UNIVERSITY HOSPITAL, IRAQ

CONCEPT DESIGN STAGE	PRELIMINARY DESIGN STAGE
DESIGN DEVELOPMENT STAGE	CONSTRUCTION DRAWINGS STAGE

DRAWING TITLE:

NINTH FLOOR PLAN
LIGHTING LAYOUT
OVERALL

01586	DWG KUH-EL-150	BLOCK * B01
1:250 @ (A0)	Sheet 01 of 01	REV. * R0



ARABTECH JARDANEH

CONSULTING INTERNATIONAL ARCHITECTS :
EO A DAILY PLANNING ARCHITECTURE ENGINEERING INTERIORS

NO.	DESCRIPTION	APPD. BY	DATE
			dd/mm/yyyy


PROJECT: KARBALA 600 BED TEACHING UNIVERSITY HOSPITAL, IRAQ


DRAWING TITLE:

01586	DWG KUH-EL-151	BLOCK * B01
1:100 (A0)	Sheet 01 of 02	REV. * R0

AD FILE NAME: 01586-EL-151-001-R0.DWG

THIS DRAWING IS THE COPYRIGHT OF ARABTECH JARDANEH ENGINEERS & ARCHITECTS AND MUST NOT BE RETAINED, COPIED OR USED WITHOUT THE CONSULTANT'S AUTHORIZATION

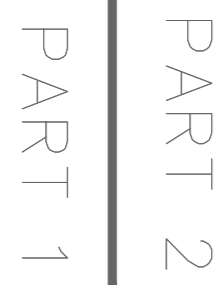

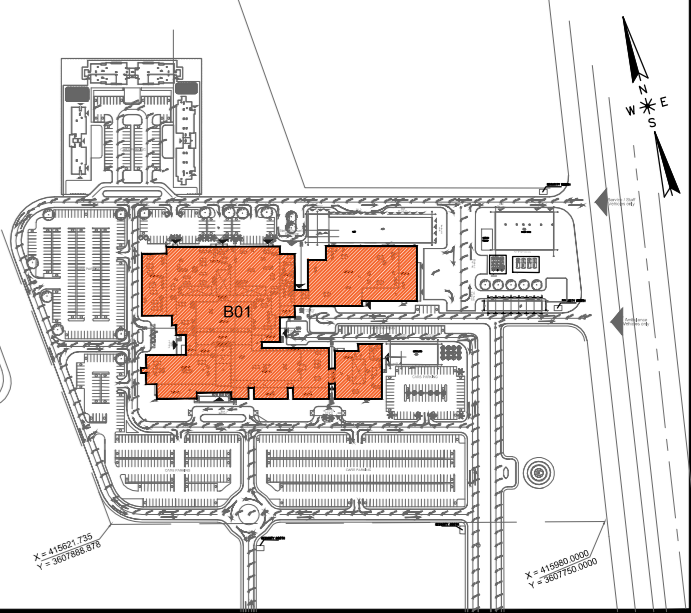

وزارة التعليم العالي والبحث العلمي
Ministry of Higher Education & Scientific Research



FOURTH DIMENSION
Contracting Engineering procurement

ARABTECH JARDANEH

CONSULTING INTERNATIONAL ARCHITECTS :
LEO A DALY PLANNING ARCHITECTURE ENGINEERING INTERIORS

THIS DRAWING IS THE
COPYRIGHT OF ARABTECH
JARDANEH ENGINEERS &
ARCHITECTS AND MUST NOT BE
RETAINED, COPIED OR USED
WITHOUT THE CONSULTANTS'
AUTHORIZATION

[illegible]

DRAWN BY:	E.D	DESIGNED BY:	H.O/M.SH
CHECKED BY:	M.KH	APPROVED BY:	F.J
QC REVIEW BY:	B.M	DWG ISSUE DATE: 26.10.2014	

PROJECT:
KARBALA 600 BED TEACHING
UNIVERSITY HOSPITAL, IRAQ


CONCEPT DESIGN STAGE	PRELIMINARY DESIGN STAGE
DESIGN DEVELOPMENT STAGE	CONSTRUCTION DRAWINGS STAGE

DRAWING TITLE:

FIFTH FLOOR PLAN
LIGHTING LAYOUT
OVERALL

01586	DWG KUH-EL-153	BLOCK * B01
1:250 (A0)	Sheet 01 of 01	REV. * R0

A detailed floor plan of a building, likely a school or office. A red arrow points to a specific area in the lower-left section of the plan, which is shaded with blue diagonal lines. The plan includes various rooms, corridors, and structural elements like walls and doors.

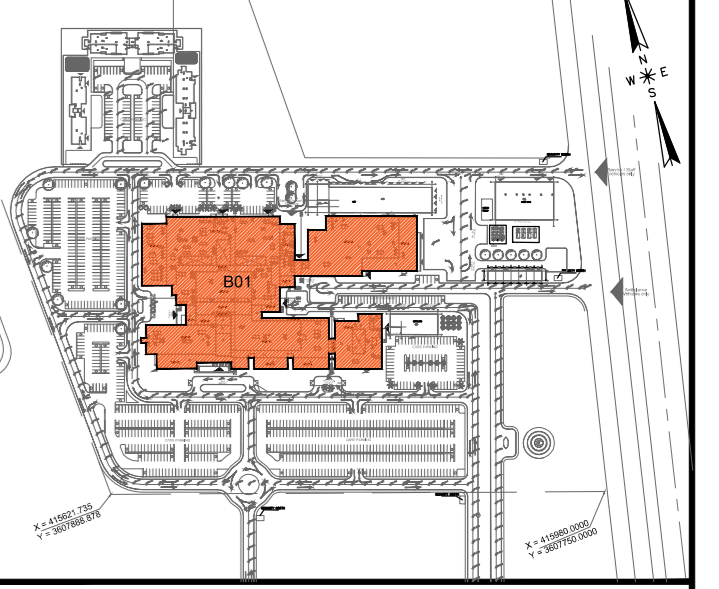

MAIN Contractor :  

HDP | healthcare designers
and project managers

CONSULTING INTERNATIONAL ARCHITECTS :
LEO A DALY PLANNING ARCHITECTURE ENGINEERING INTERIORS

[illegible]

PROJECT: KARBALA 600 BED TEACHING UNIVERSITY HOSPITAL, IRAQ

CONCEPT DESIGN STAGE	PRELIMINARY DESIGN STAGE
DESIGN DEVELOPMENT STAGE	CONSTRUCTION DRAWINGS STAGE


DRAWING TITLE:

01586	DWG KUH-EL-154	BLOCK * B01
1:100 @ (AO)	She. 01 of 02	REV. * R0



CAD FILE NAME: 01586-EL-154-B01-R0.DWG

SAVED BY: Afif.oleboed ON: 25.10.2014 @ 09:05

CAD FILE NAME: 01586-EL-154-B01-R0.DWG

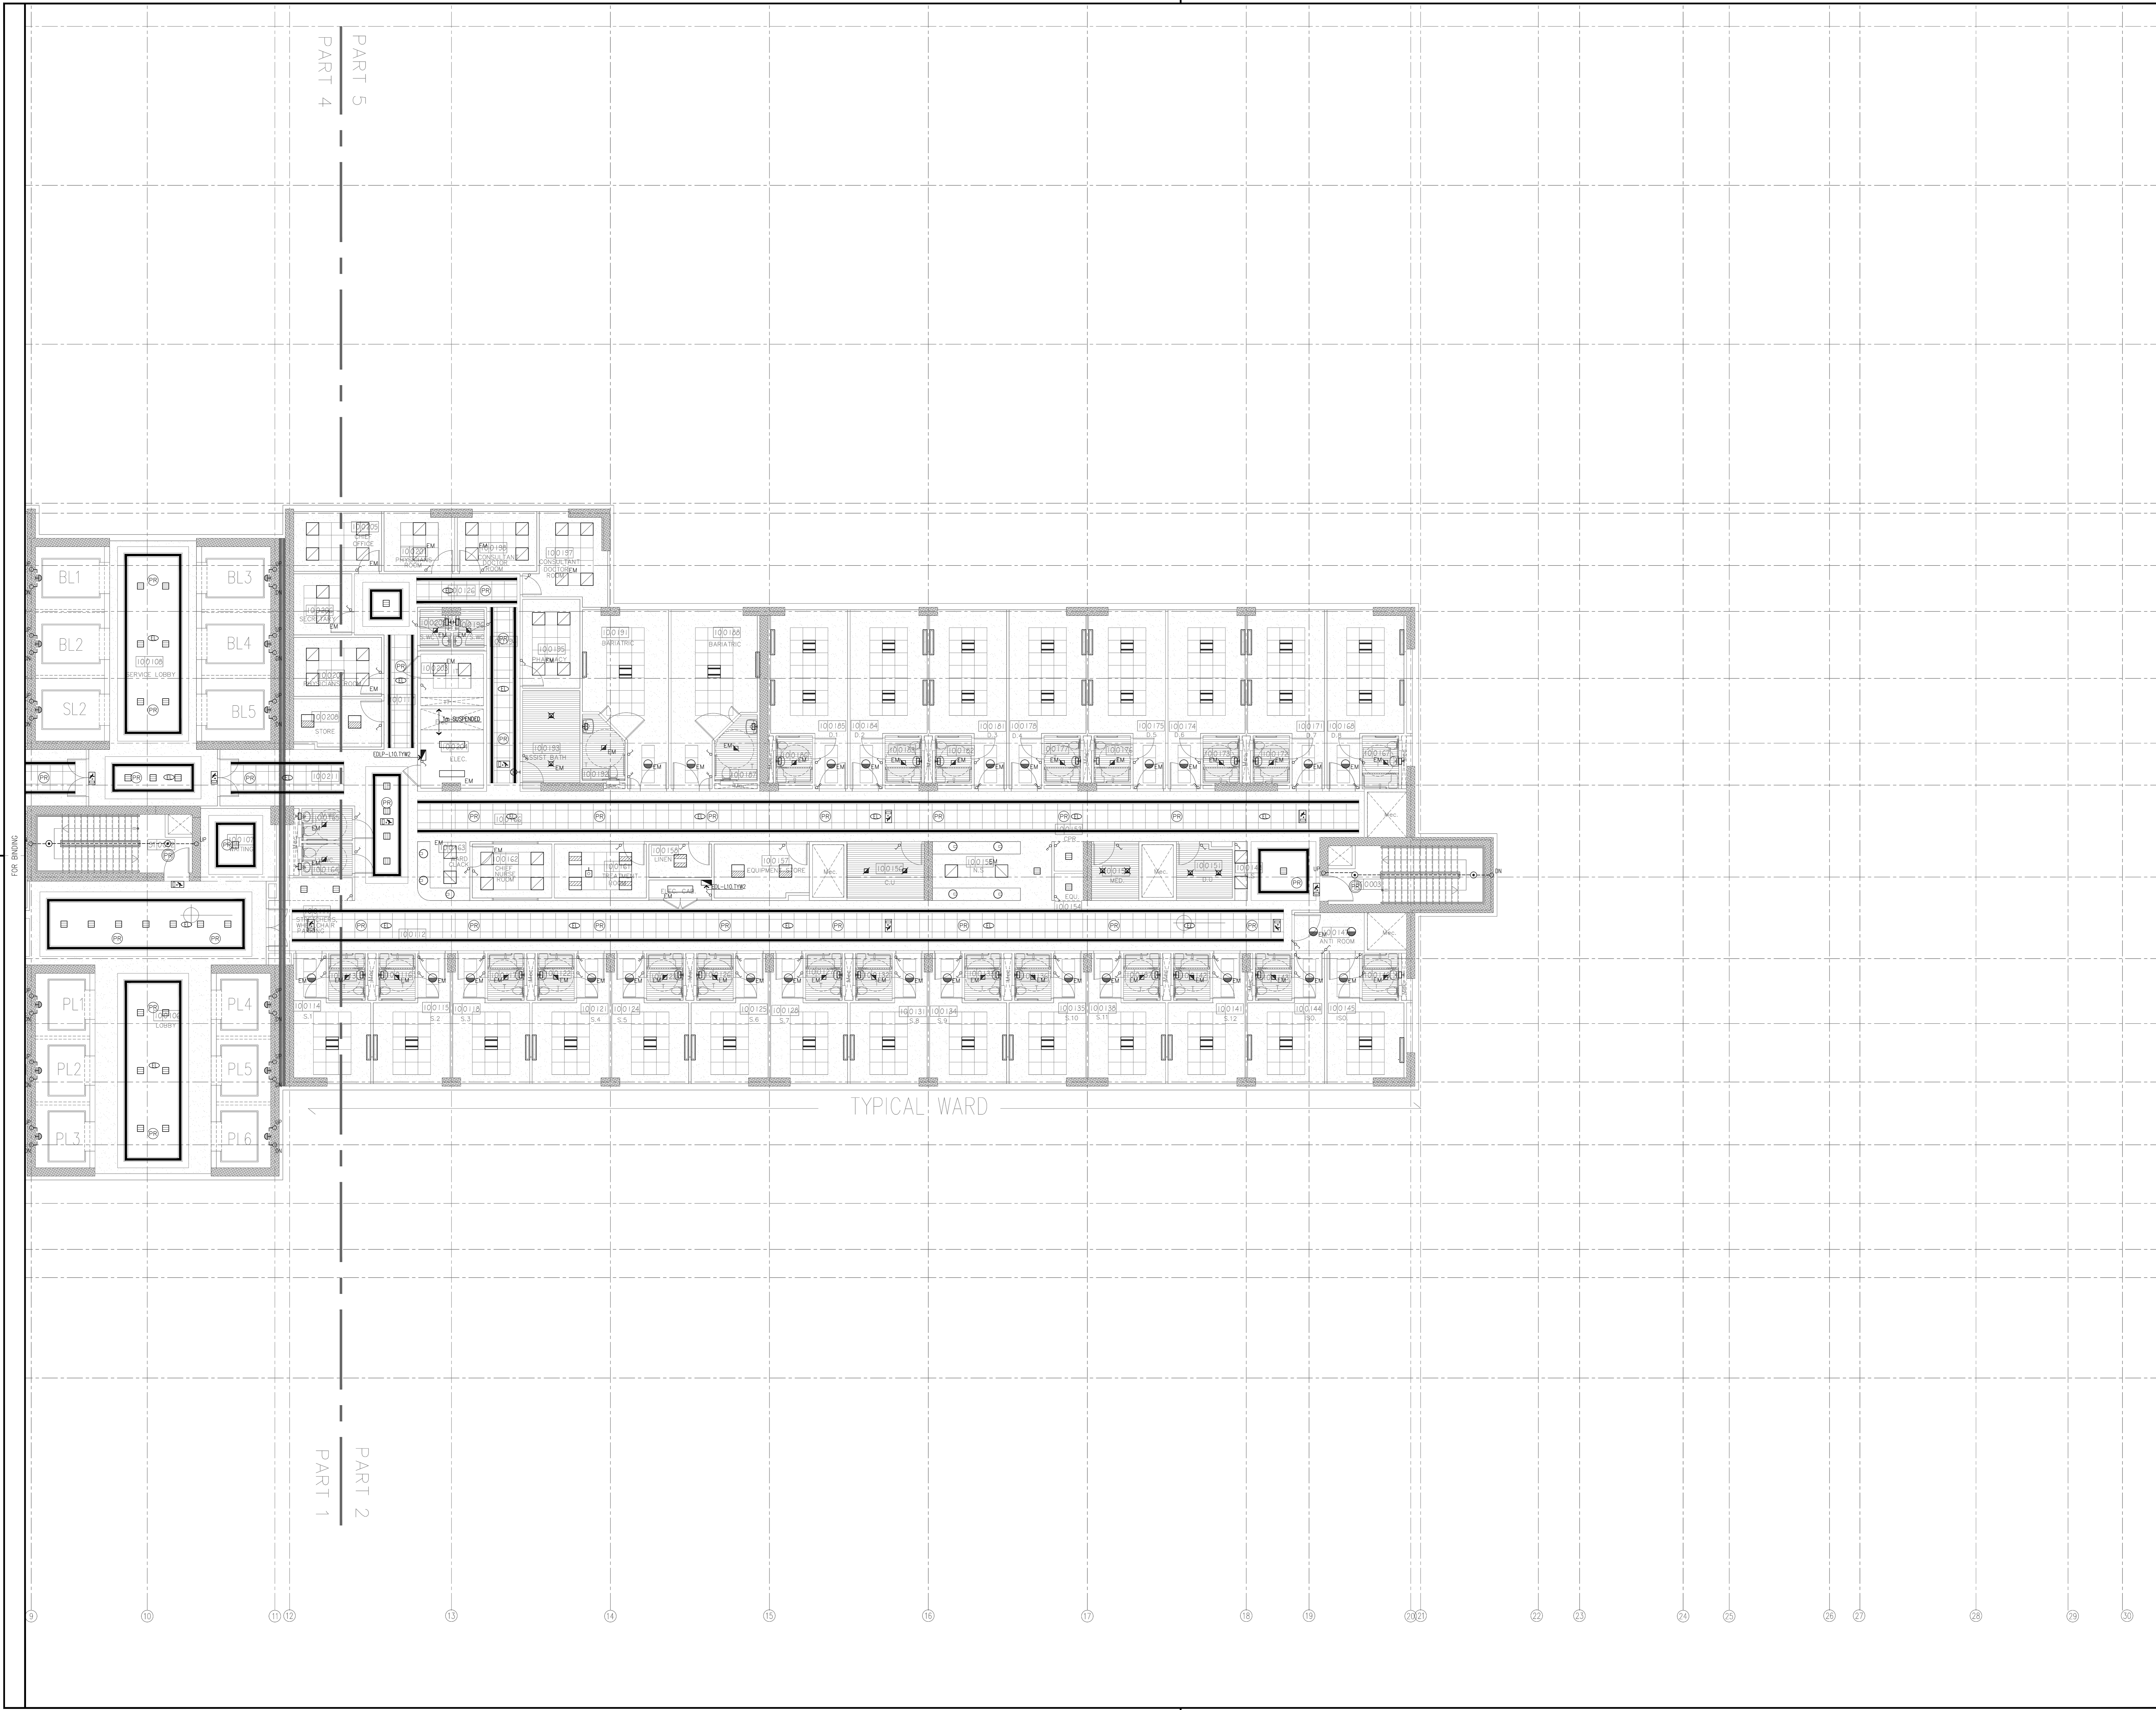

General Notes :

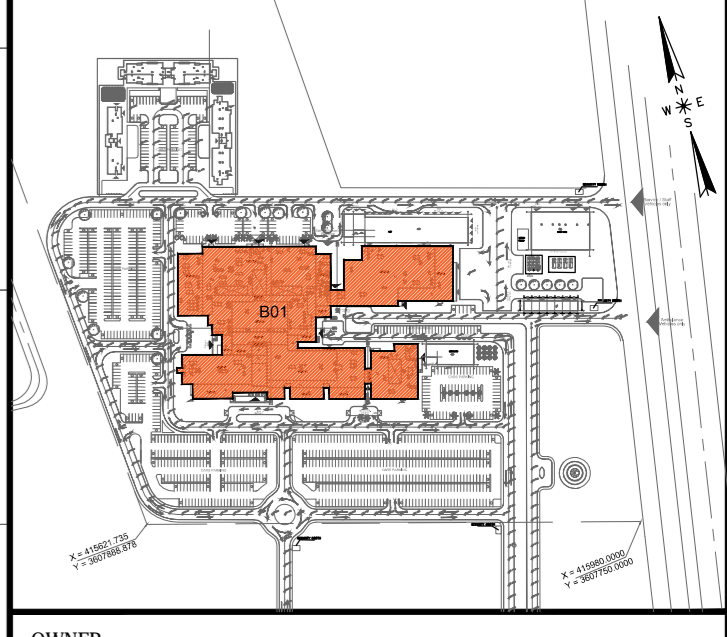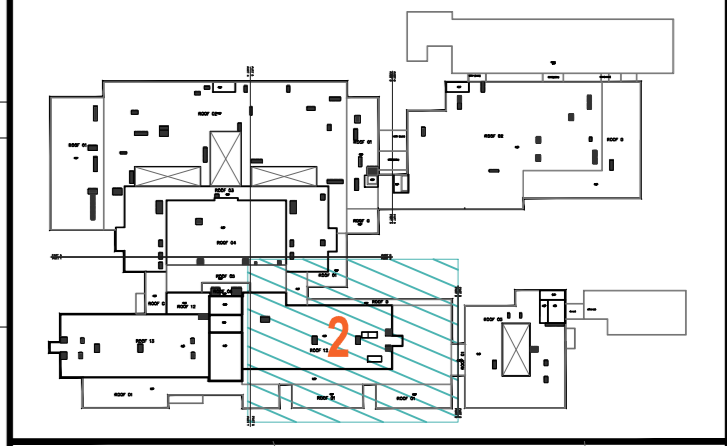

MINISTRY OF HIGHER EDUCATION
AND SCIENTIFIC RESEARCH
University Of Karbala



PROJECT MANAGEMENT CONSULTANT
AM TECH

MAIN CONTRACTOR
FOURTH DIMENSION
Consulting Engineering & Construction

PRINCIPAL ENGINEERING CONSULTANT
ARABTECH JARDANEH

CONSULTING HEALTH PLANNERS
HDP healthcare designers
and project managers

CONSULTING INTERNATIONAL ARCHITECTS
LEO A DALY PLANNING ARCHITECTURE ENGINEERING INTERIORS

THIS DRAWING IS THE
COPYRIGHT OF ARABTECH
JARDANEH ENGINEERS &
ARCHITECTS AND MUST NOT BE
REPRODUCED, COPIED OR USED
WITHOUT THE CONSULTANTS
AUTHORIZATION

REV.	DESCRIPTION	APPRO. BY	DATE

DRAWN BY: E.D. DESIGNED BY: H.O.M.S.H.
CHECKED BY: M.K.H. APPROVED BY: F.J.
QC REVIEW BY: B.M. DWG ISSUE DATE: 26.10.2014

PROJECT:
**KARBALA 600 BED TEACHING
UNIVERSITY HOSPITAL, IRAQ**


CONCEPT DESIGN STAGE PRELIMINARY DESIGN STAGE
DESIGN DEVELOPMENT STAGE CONSTRUCTION DRAWINGS STAGE

DRAWING TITLE:



**TENTH FLOOR PLAN
LIGHTING LAYOUT
PART 2**

A01 01586 DWG: KUH-EL-155 BLOCK: B01
1:100 01 (A0) Sht. 02 of 02 REV: R0

FOR BUILDING

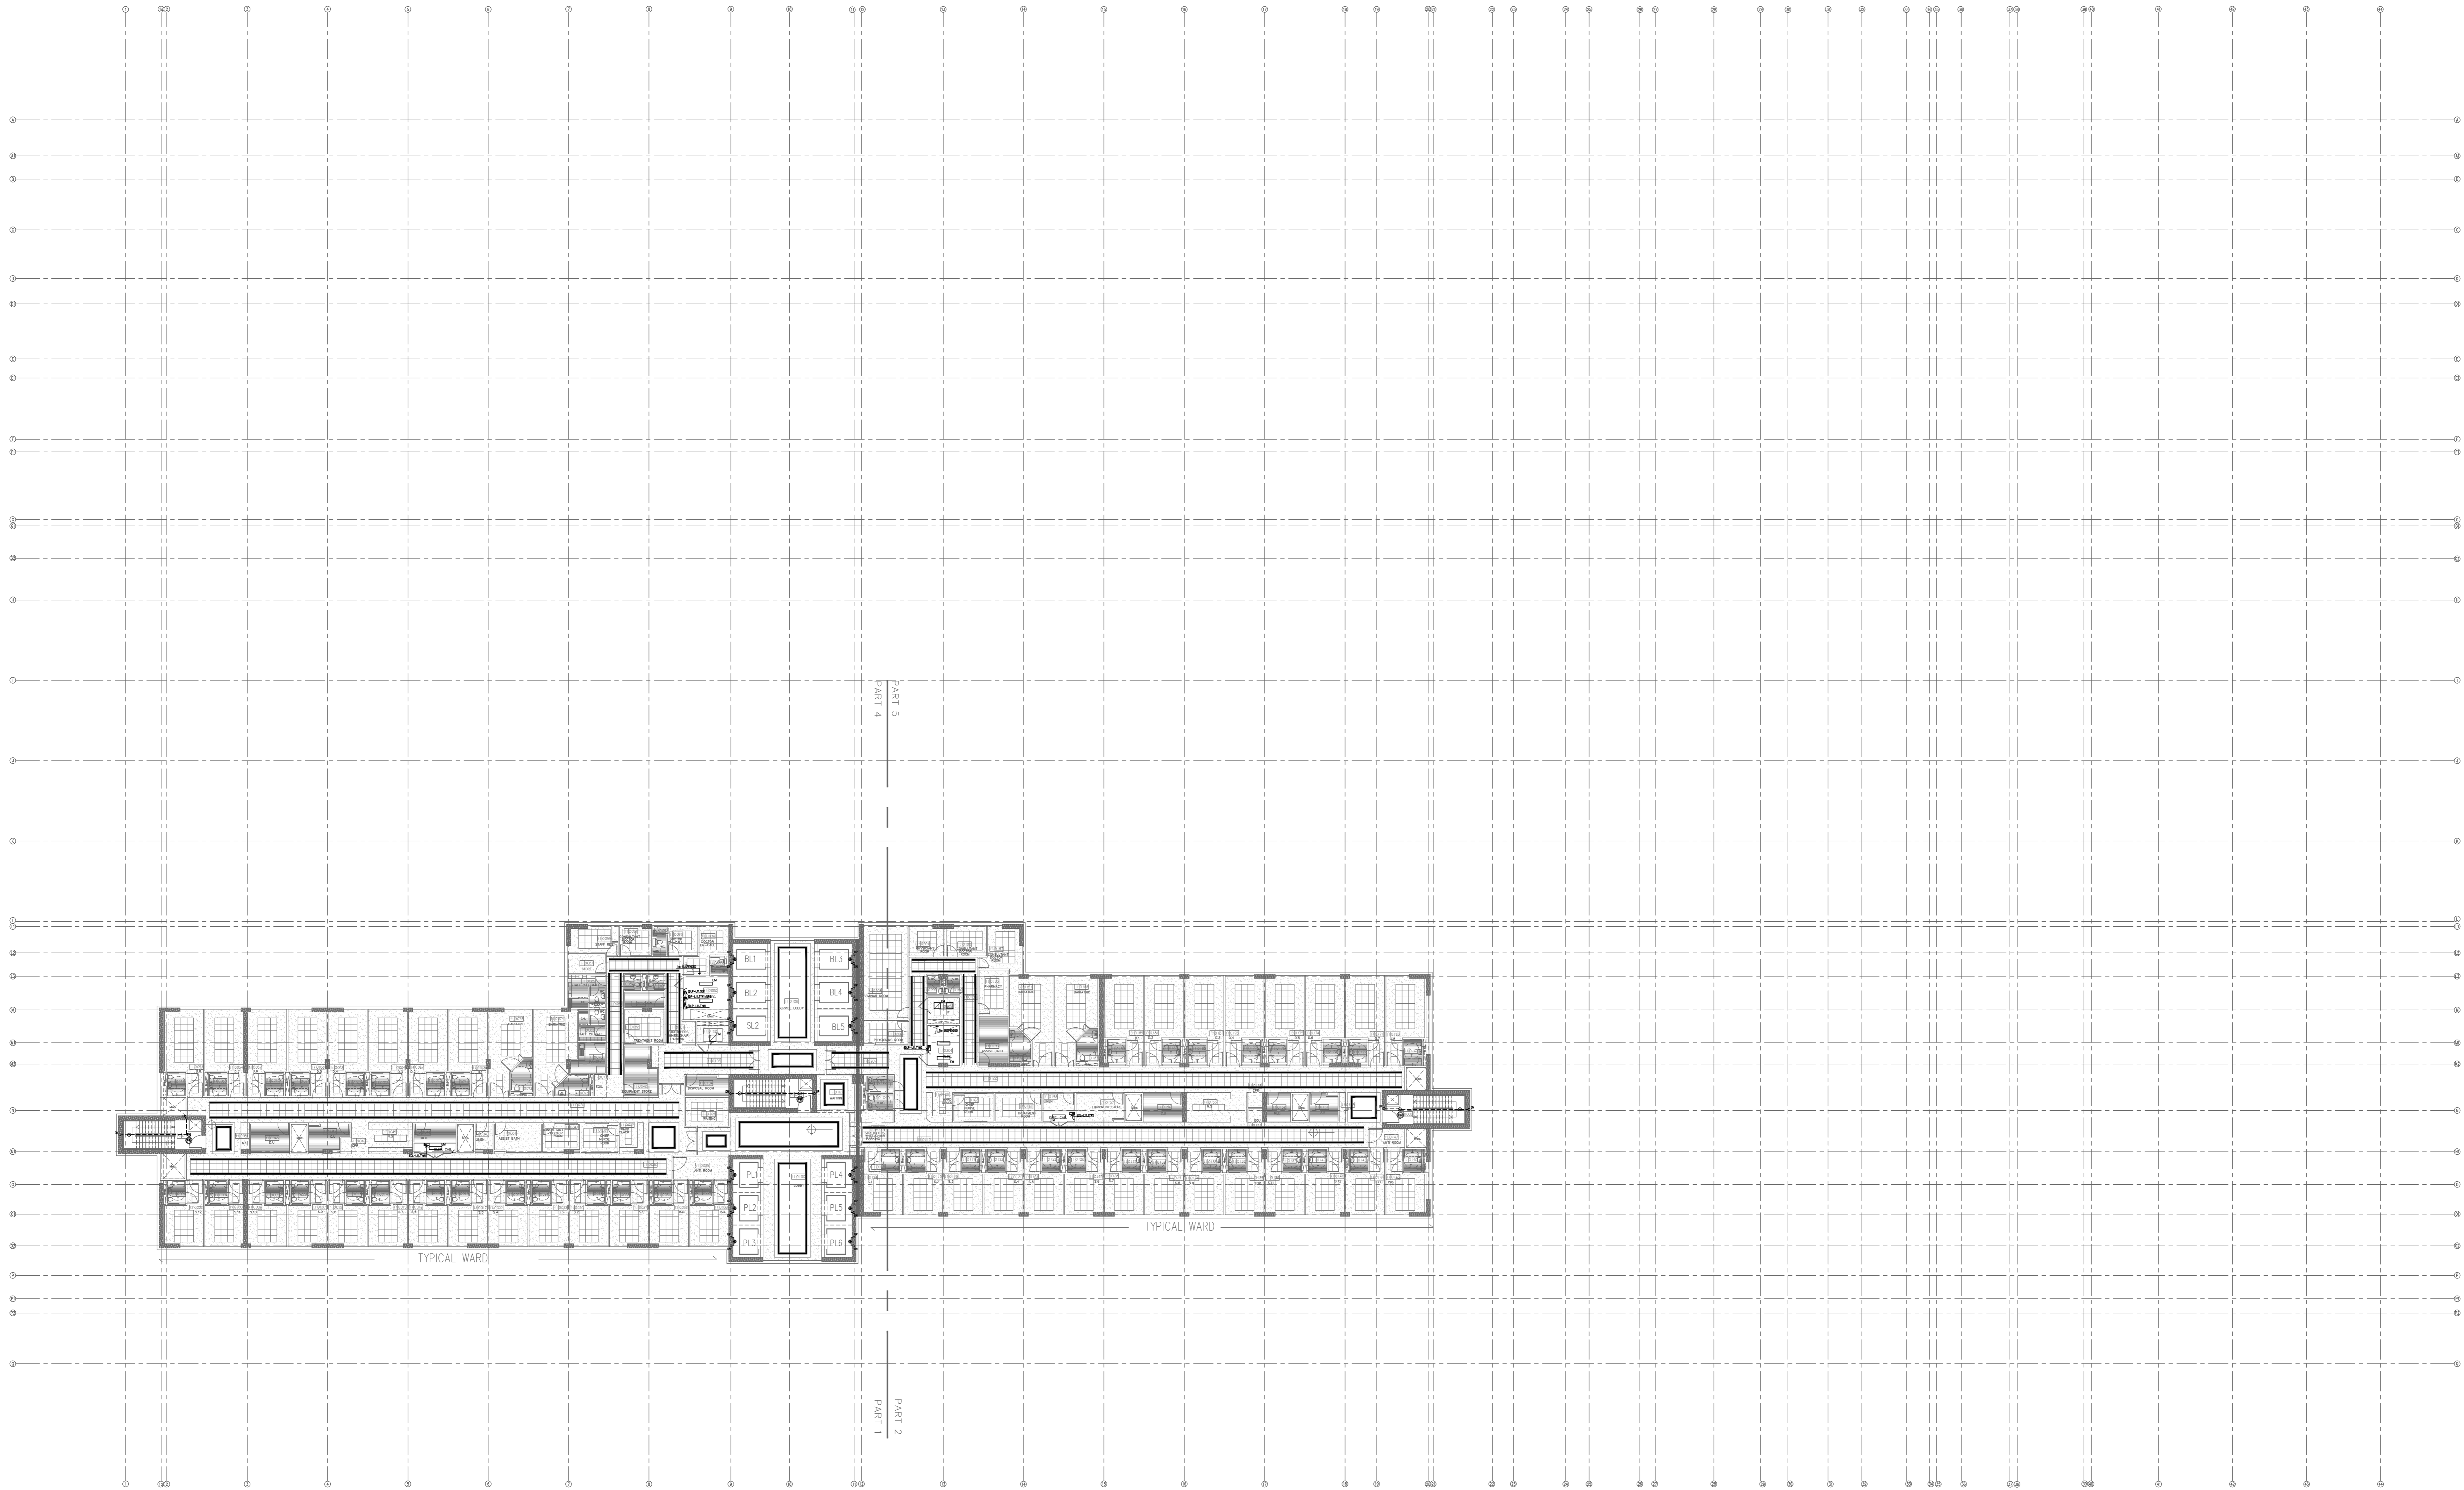

General Notes :

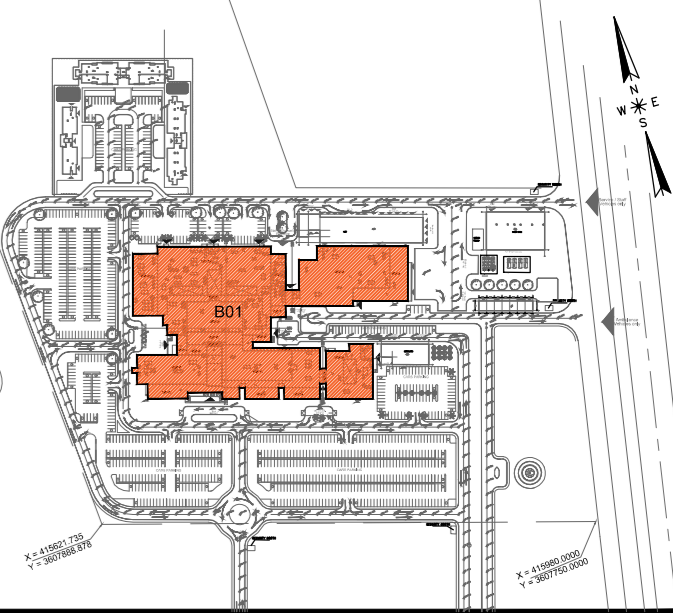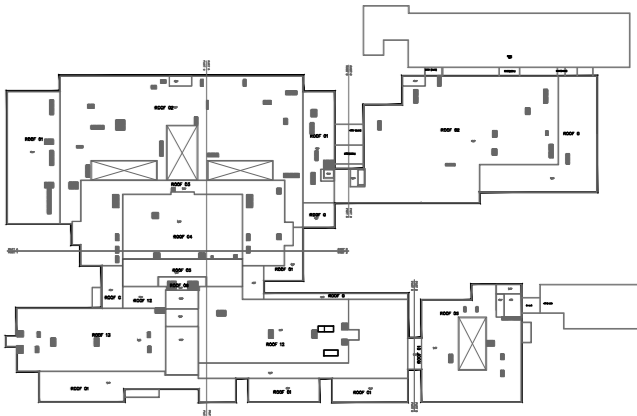

MINISTRY OF HIGHER EDUCATION
AND SCIENTIFIC RESEARCH
University Of Karbala



PROJECT MANAGEMENT CONSULTANT
AM TECH

MAIN Contractor :
FOURTH DIMENSION
Consulting Engineering & Construction
C/S.C

PRINCIPAL ENGINEERING CONSULTANT :
ARABTECH JARDANEH

CONSULTING HEALTH PLANNERS :
HDP healthcare designers
and project managers

CONSULTING INTERNATIONAL ARCHITECTS :
LEO A DALY
PLANNING ARCHITECTURE ENGINEERING INTERIORS

THIS DRAWING IS THE
COPYRIGHT OF ARABTECH
JARDANEH ENGINEERS &
ARCHITECTS AND MUST NOT BE
REPRODUCED, COPIED OR USED
WITHOUT THE CONSULTANTS'
AUTHORIZATION

REV.	DESCRIPTION	APPRO. BY	DATE

DRAWN BY: E.D	DESIGNED BY: H.O/M.S.H
CHECKED BY: M.K.H	APPROVED BY: F.J
QC REVIEW BY: B.M	DWG ISSUE DATE: 26.10.2014


PROJECT:
**KARBALA 600 BED TEACHING
UNIVERSITY HOSPITAL, IRAQ**

CONCEPT DESIGN STAGE	PRELIMINARY DESIGN STAGE
DESIGN DEVELOPMENT STAGE	CONSTRUCTION DRAWINGS STAGE



DRAWING TITLE:

**ELEVENTH FLOOR PLAN
LIGHTING LAYOUT
OVERALL**

A0B #	DWG #	BLOCK #	REV #
01586	KUH-EL-156	B01	RO
1:250	Sheet 01 of 01		

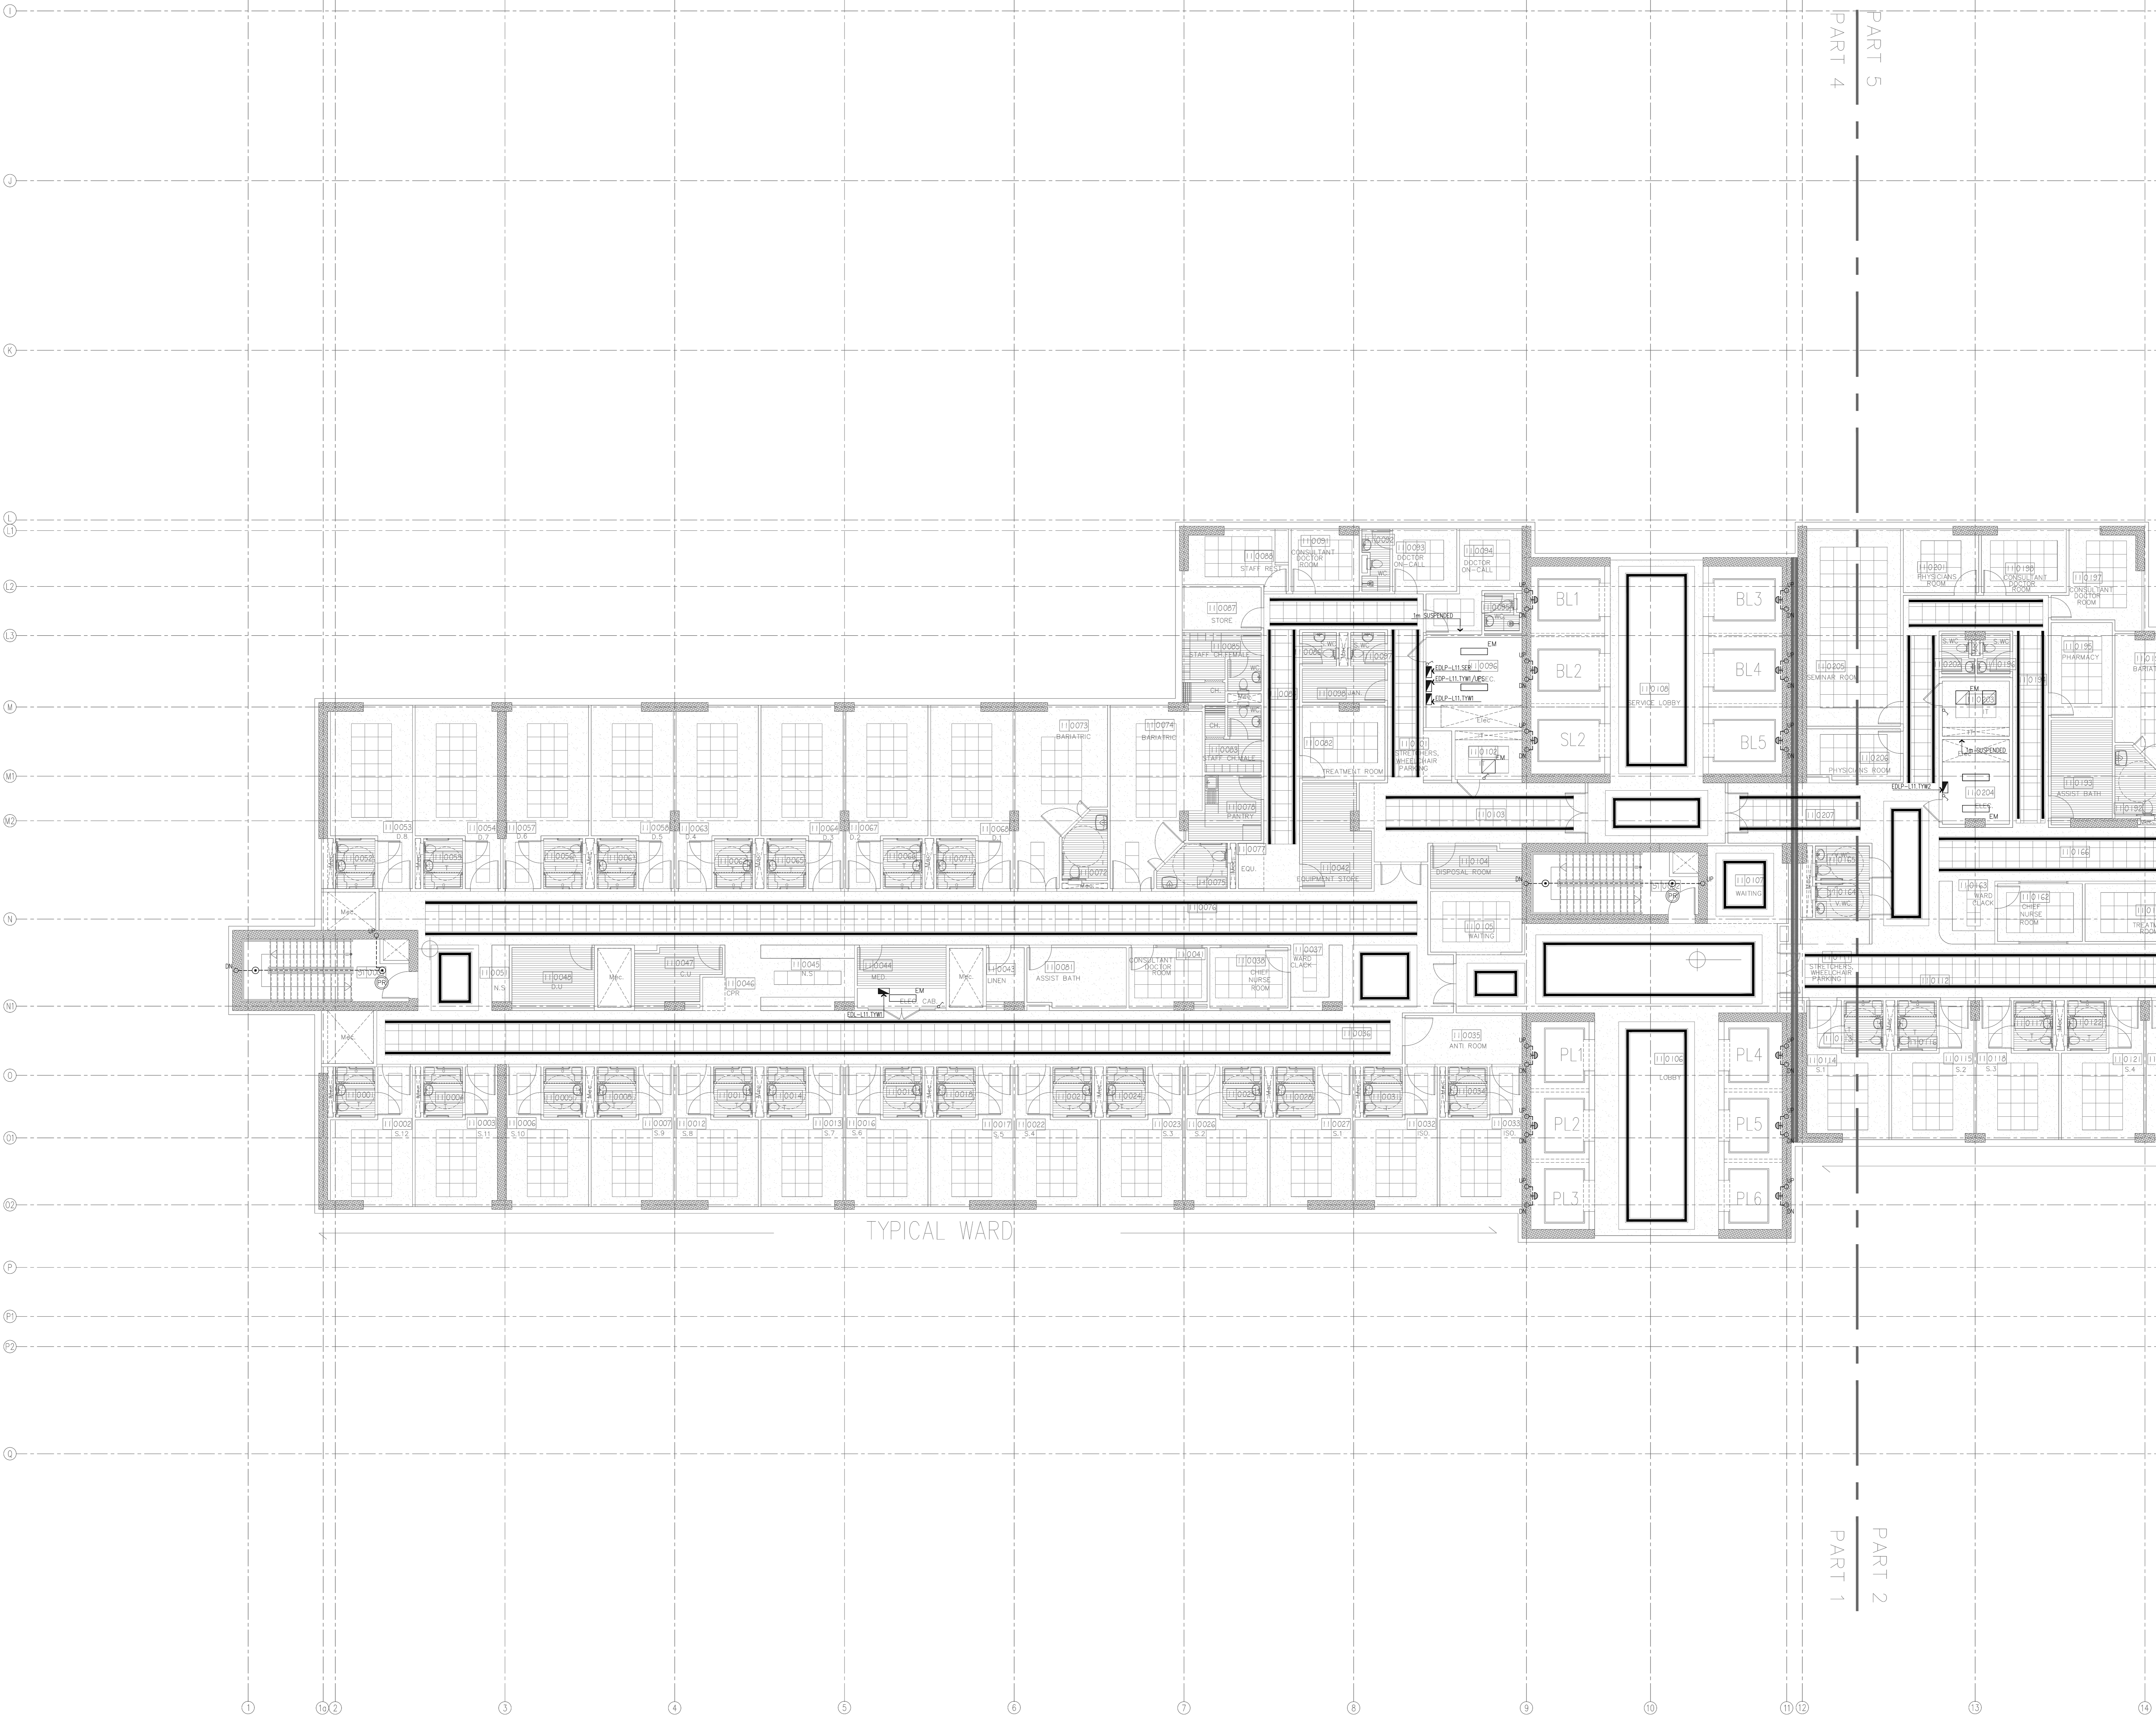

General Notes :

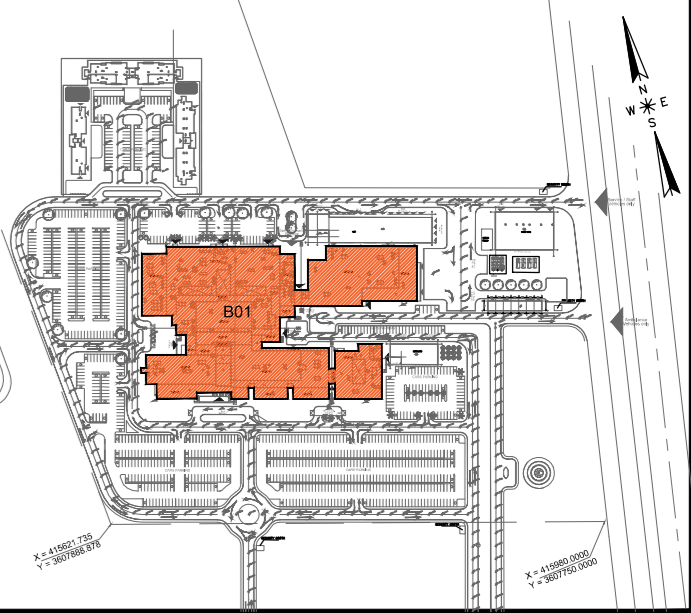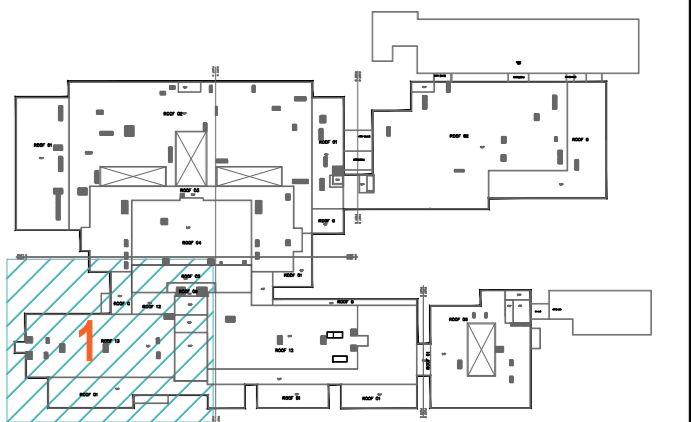

MINISTRY OF HIGHER EDUCATION
AND SCIENTIFIC RESEARCH
University Of Karbala



PROJECT MANAGEMENT CONSULTANT
AM TECH

MAIN CONTRACTOR
FOURTH DIMENSION
Consulting Engineering & Construction

PRINCIPAL ENGINEERING CONSULTANT
ARABTECH JARDANEH

CONSULTING HEALTH PLANNERS
HDP healthcare designers
and project managers

CONSULTING INTERNATIONAL ARCHITECTS
LEO A DALY PLANNING ARCHITECTURE ENGINEERING INTERIORS

THIS DRAWING IS THE
COPYRIGHT OF ARABTECH
JARDANEH ENGINEERS &
ARCHITECTS AND MUST NOT BE
REPRODUCED, COPIED OR USED
WITHOUT THE CONSULTANTS
AUTHORIZATION

REV.	DESCRIPTION	APPRO. BY	DATE

DRAWN BY: E.D. DESIGNED BY: H.O.M.S.H.
CHECKED BY: M.K.H. APPROVED BY: F.J.
QC REVIEW BY: B.M. DWG ISSUE DATE: 26.10.2014

PROJECT:
**KARBALA 600 BED TEACHING
UNIVERSITY HOSPITAL, IRAQ**


CONCEPT DESIGN STAGE	PRELIMINARY DESIGN STAGE
DESIGN DEVELOPMENT STAGE	CONSTRUCTION DRAWINGS STAGE

DRAWING TITLE:

**ELEVENTH FLOOR PLAN
LIGHTING LAYOUT
PART 1**

A01 01586 DWG: KUH-EL-157 BLOCK: B01
1:100 01 of 02 REV: R0

A floor plan of a building with various rooms and corridors. A specific area, likely a staircase or a small room, is highlighted with blue diagonal hatching and a large red number '2' in the center. This area is located in the lower-left quadrant of the plan.

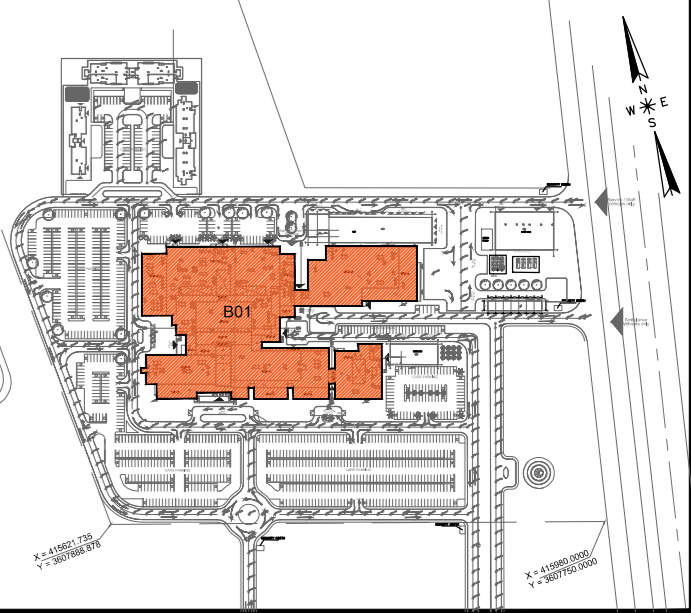

ARABTECH JARDANEH

HDP | healthcare designers
and project managers

LEO A DALY PLANNING ARCHITECTURE ENGINEERING INTERIORS

THIS DRAWING IS THE
COPYRIGHT OF ARABTECH
JARDANEH ENGINEERS &
CHITECTS AND MUST NOT BE
RETAINED, COPIED OR USED
WITHOUT THE CONSULTANTS'
AUTHORIZATION

[illegible]


PROJECT: _____

CONCEPT DESIGN STAGE	PRELIMINARY DESIGN STAGE
DESIGN DEVELOPMENT STAGE	CONSTRUCTION DRAWINGS STAGE



ELEVENTH FLOOR PLAN
LIGHTING LAYOUT
PART 2

01586	DWG KUH-EL-158	BLOCK * B01
1:100 @ (A0)	Sheet 02 of 02	REV. * R0

FOR BUILDING

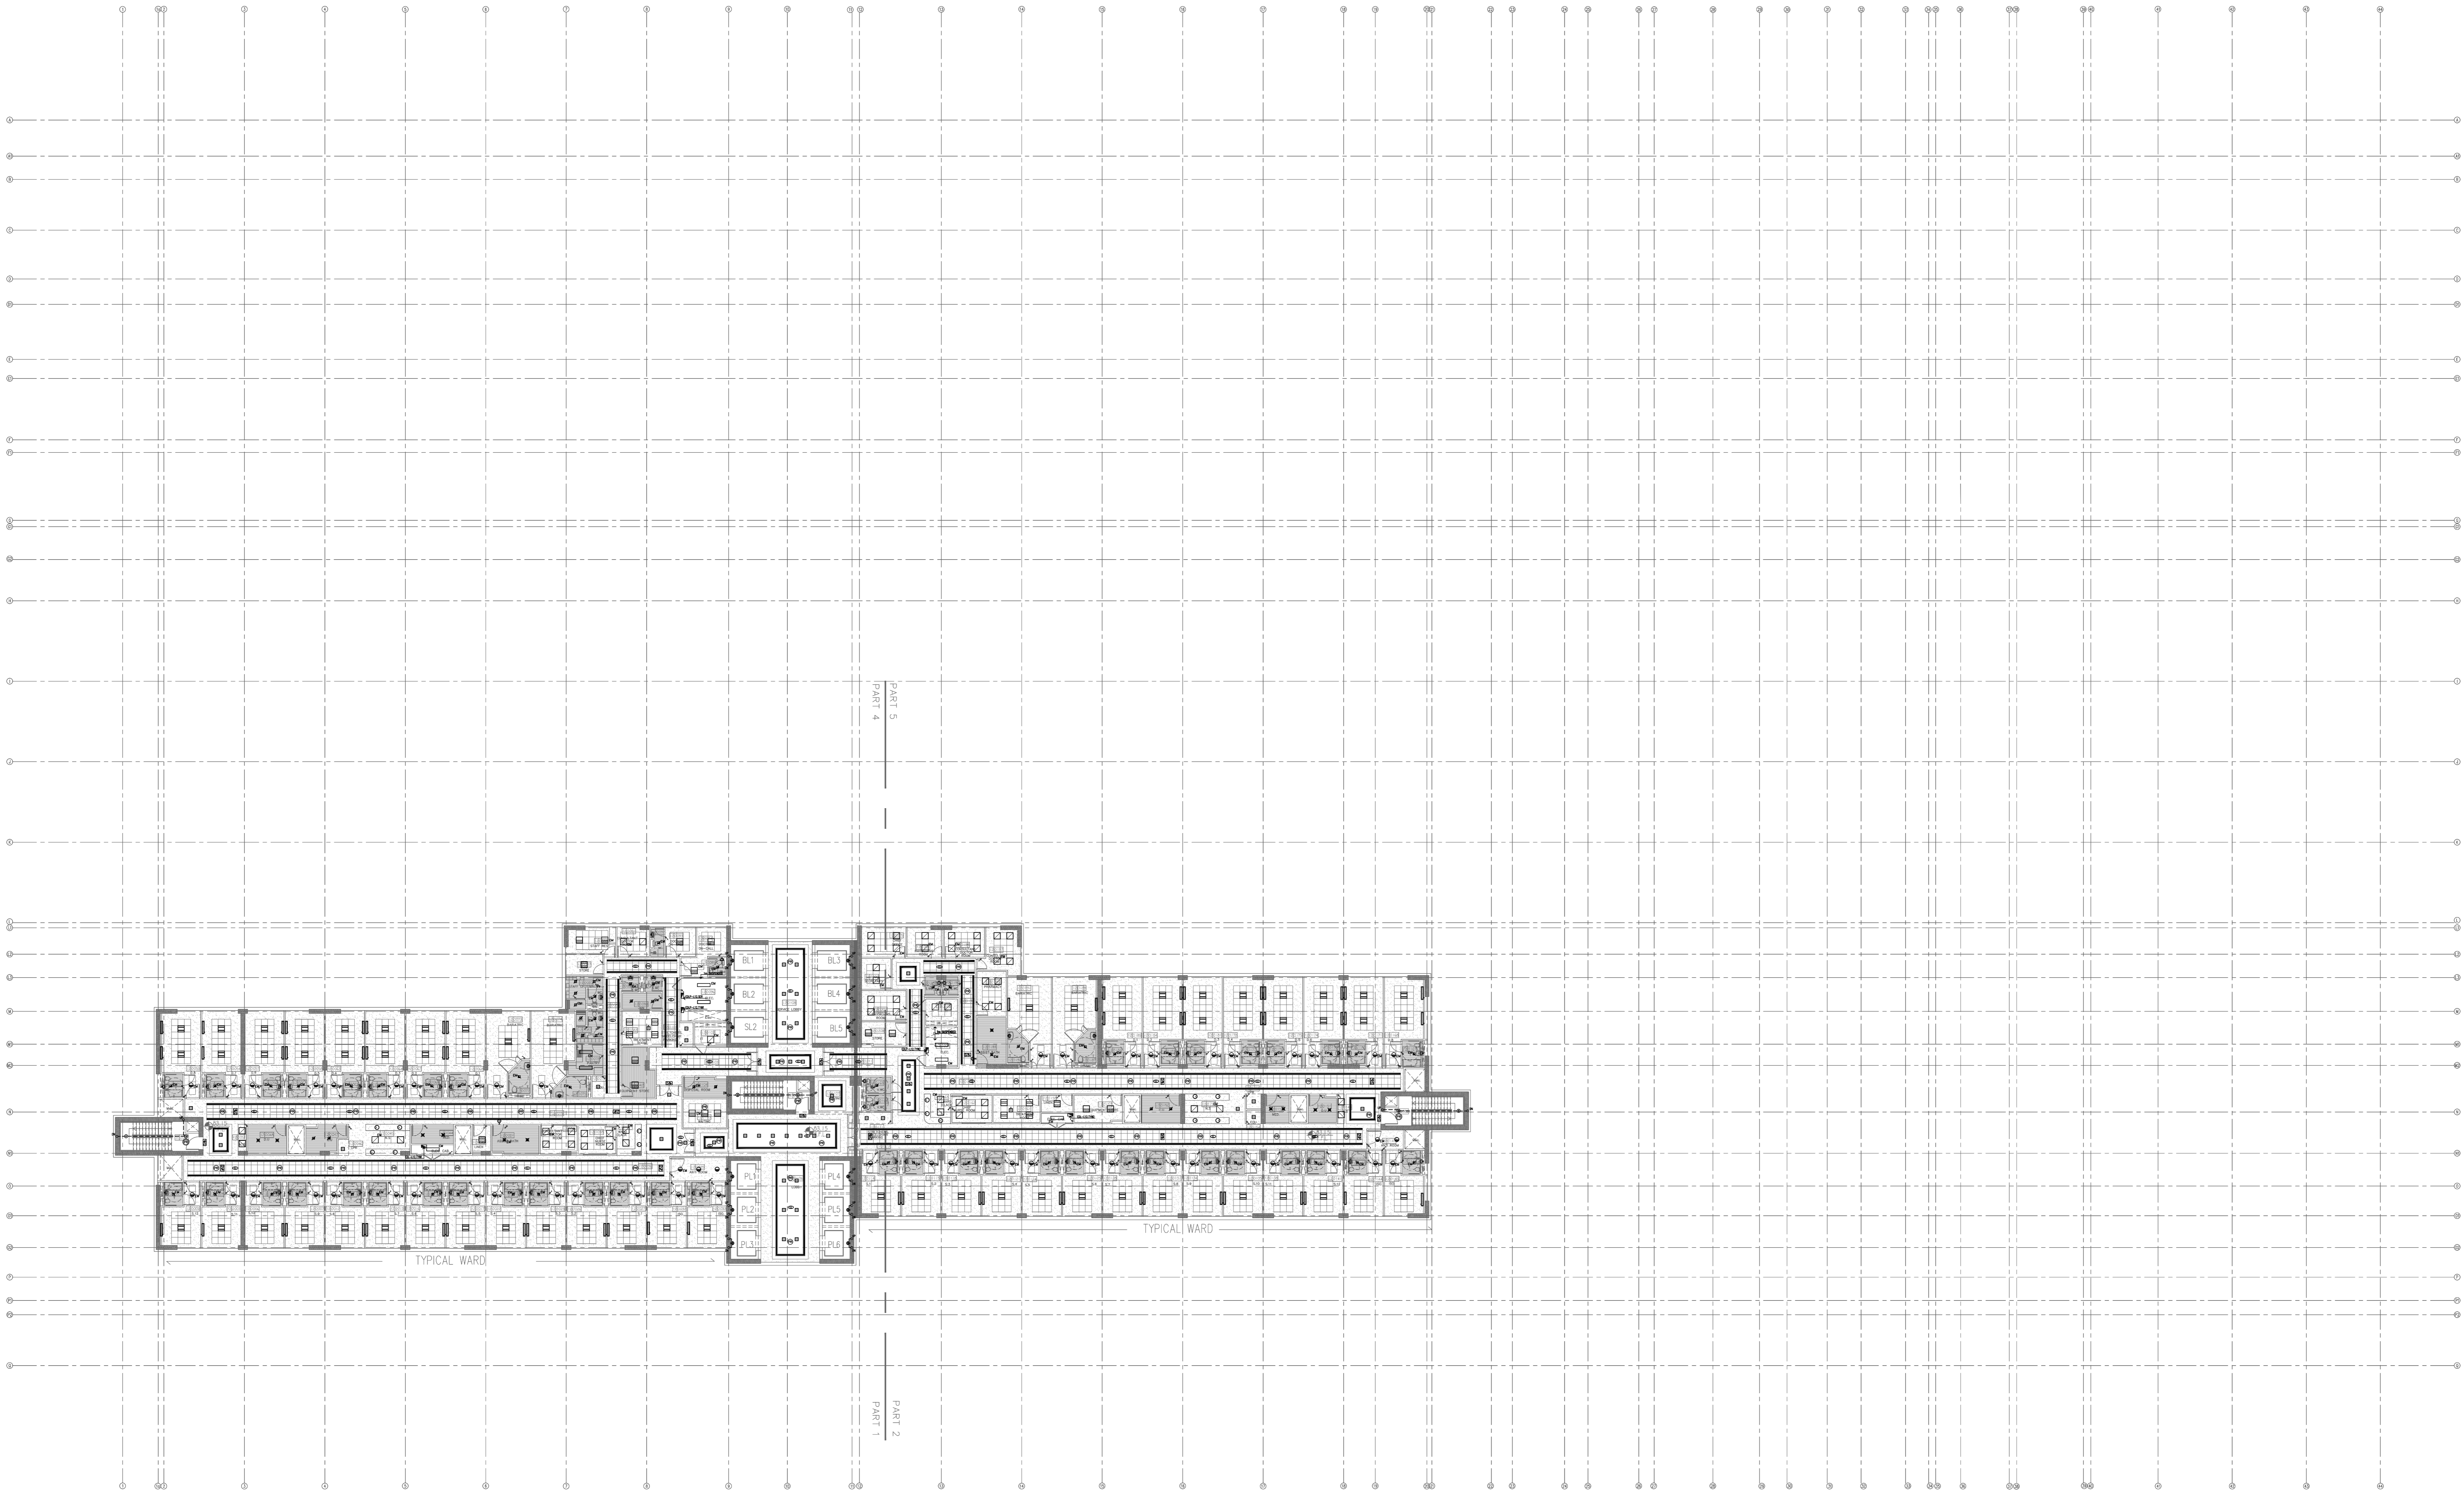

General Notes :

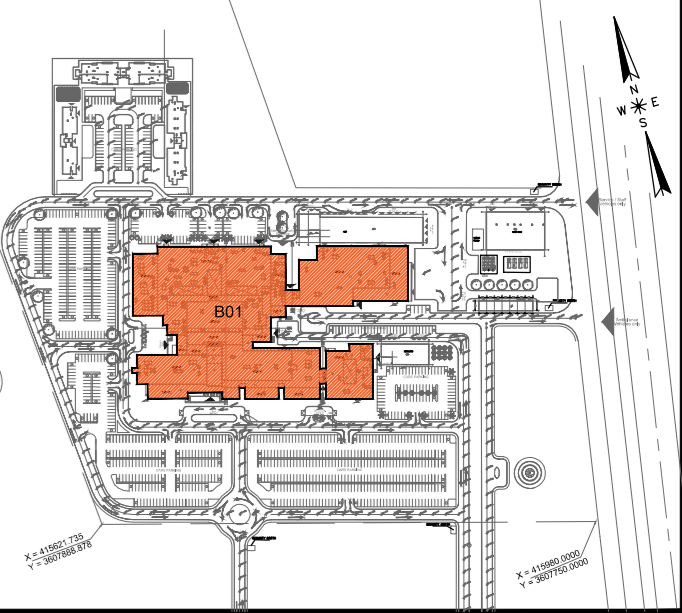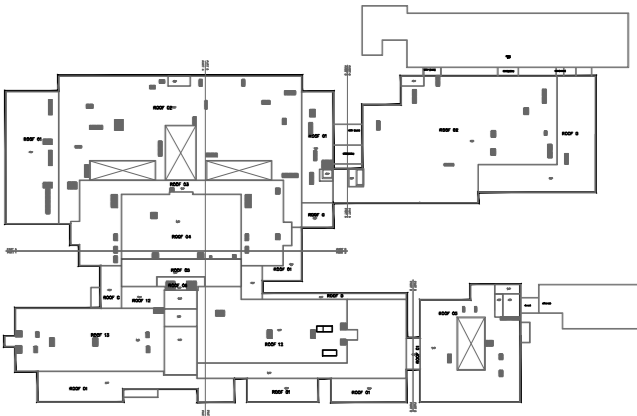

OWNER:
MINISTRY OF HIGHER EDUCATION
AND SCIENTIFIC RESEARCH
University Of Karbala



PROJECT MANAGEMENT CONSULTANT:
AM TECH

MAIN Contractor :
FOURTH DIMENSION
Consulting Engineering & Construction
C/S.C

PRINCIPAL ENGINEERING CONSULTANT:
ARABTECH JARDANEH

CONSULTING HEALTH PLANNERS:
HDP healthcare designers
and project managers

CONSULTING INTERNATIONAL ARCHITECTS:
LEO A DALY
PLANNING ARCHITECTURE ENGINEERING INTERIORS

THIS DRAWING IS THE
COPYRIGHT OF ARABTECH
JARDANEH ENGINEERS &
ARCHITECTS AND MUST NOT BE
REPRODUCED, COPIED OR USED
WITHOUT THE CONSULTANTS'
AUTHORIZATION

REV.	DESCRIPTION	APPRO. BY	DATE


DRAWN BY: E.D	DESIGNED BY: H.O/M/SH
CHECKED BY: M.KH	APPROVED BY: F.J
QC REVIEW BY: B.M	DWG ISSUE DATE: 26.10.2014

PROJECT:	
KARBALA 600 BED TEACHING UNIVERSITY HOSPITAL, IRAQ	
CONCEPT DESIGN STAGE	PRELIMINARY DESIGN STAGE
DESIGN DEVELOPMENT STAGE	CONSTRUCTION DRAWINGS STAGE



DRAWING TITLE:

TWELFTH FLOOR PLAN
LIGHTING LAYOUT
OVERALL

A0B #	01586	DWG #	KUH-EL-159	BLOCK #	B01
T-250	01	01	01	REV.	RO

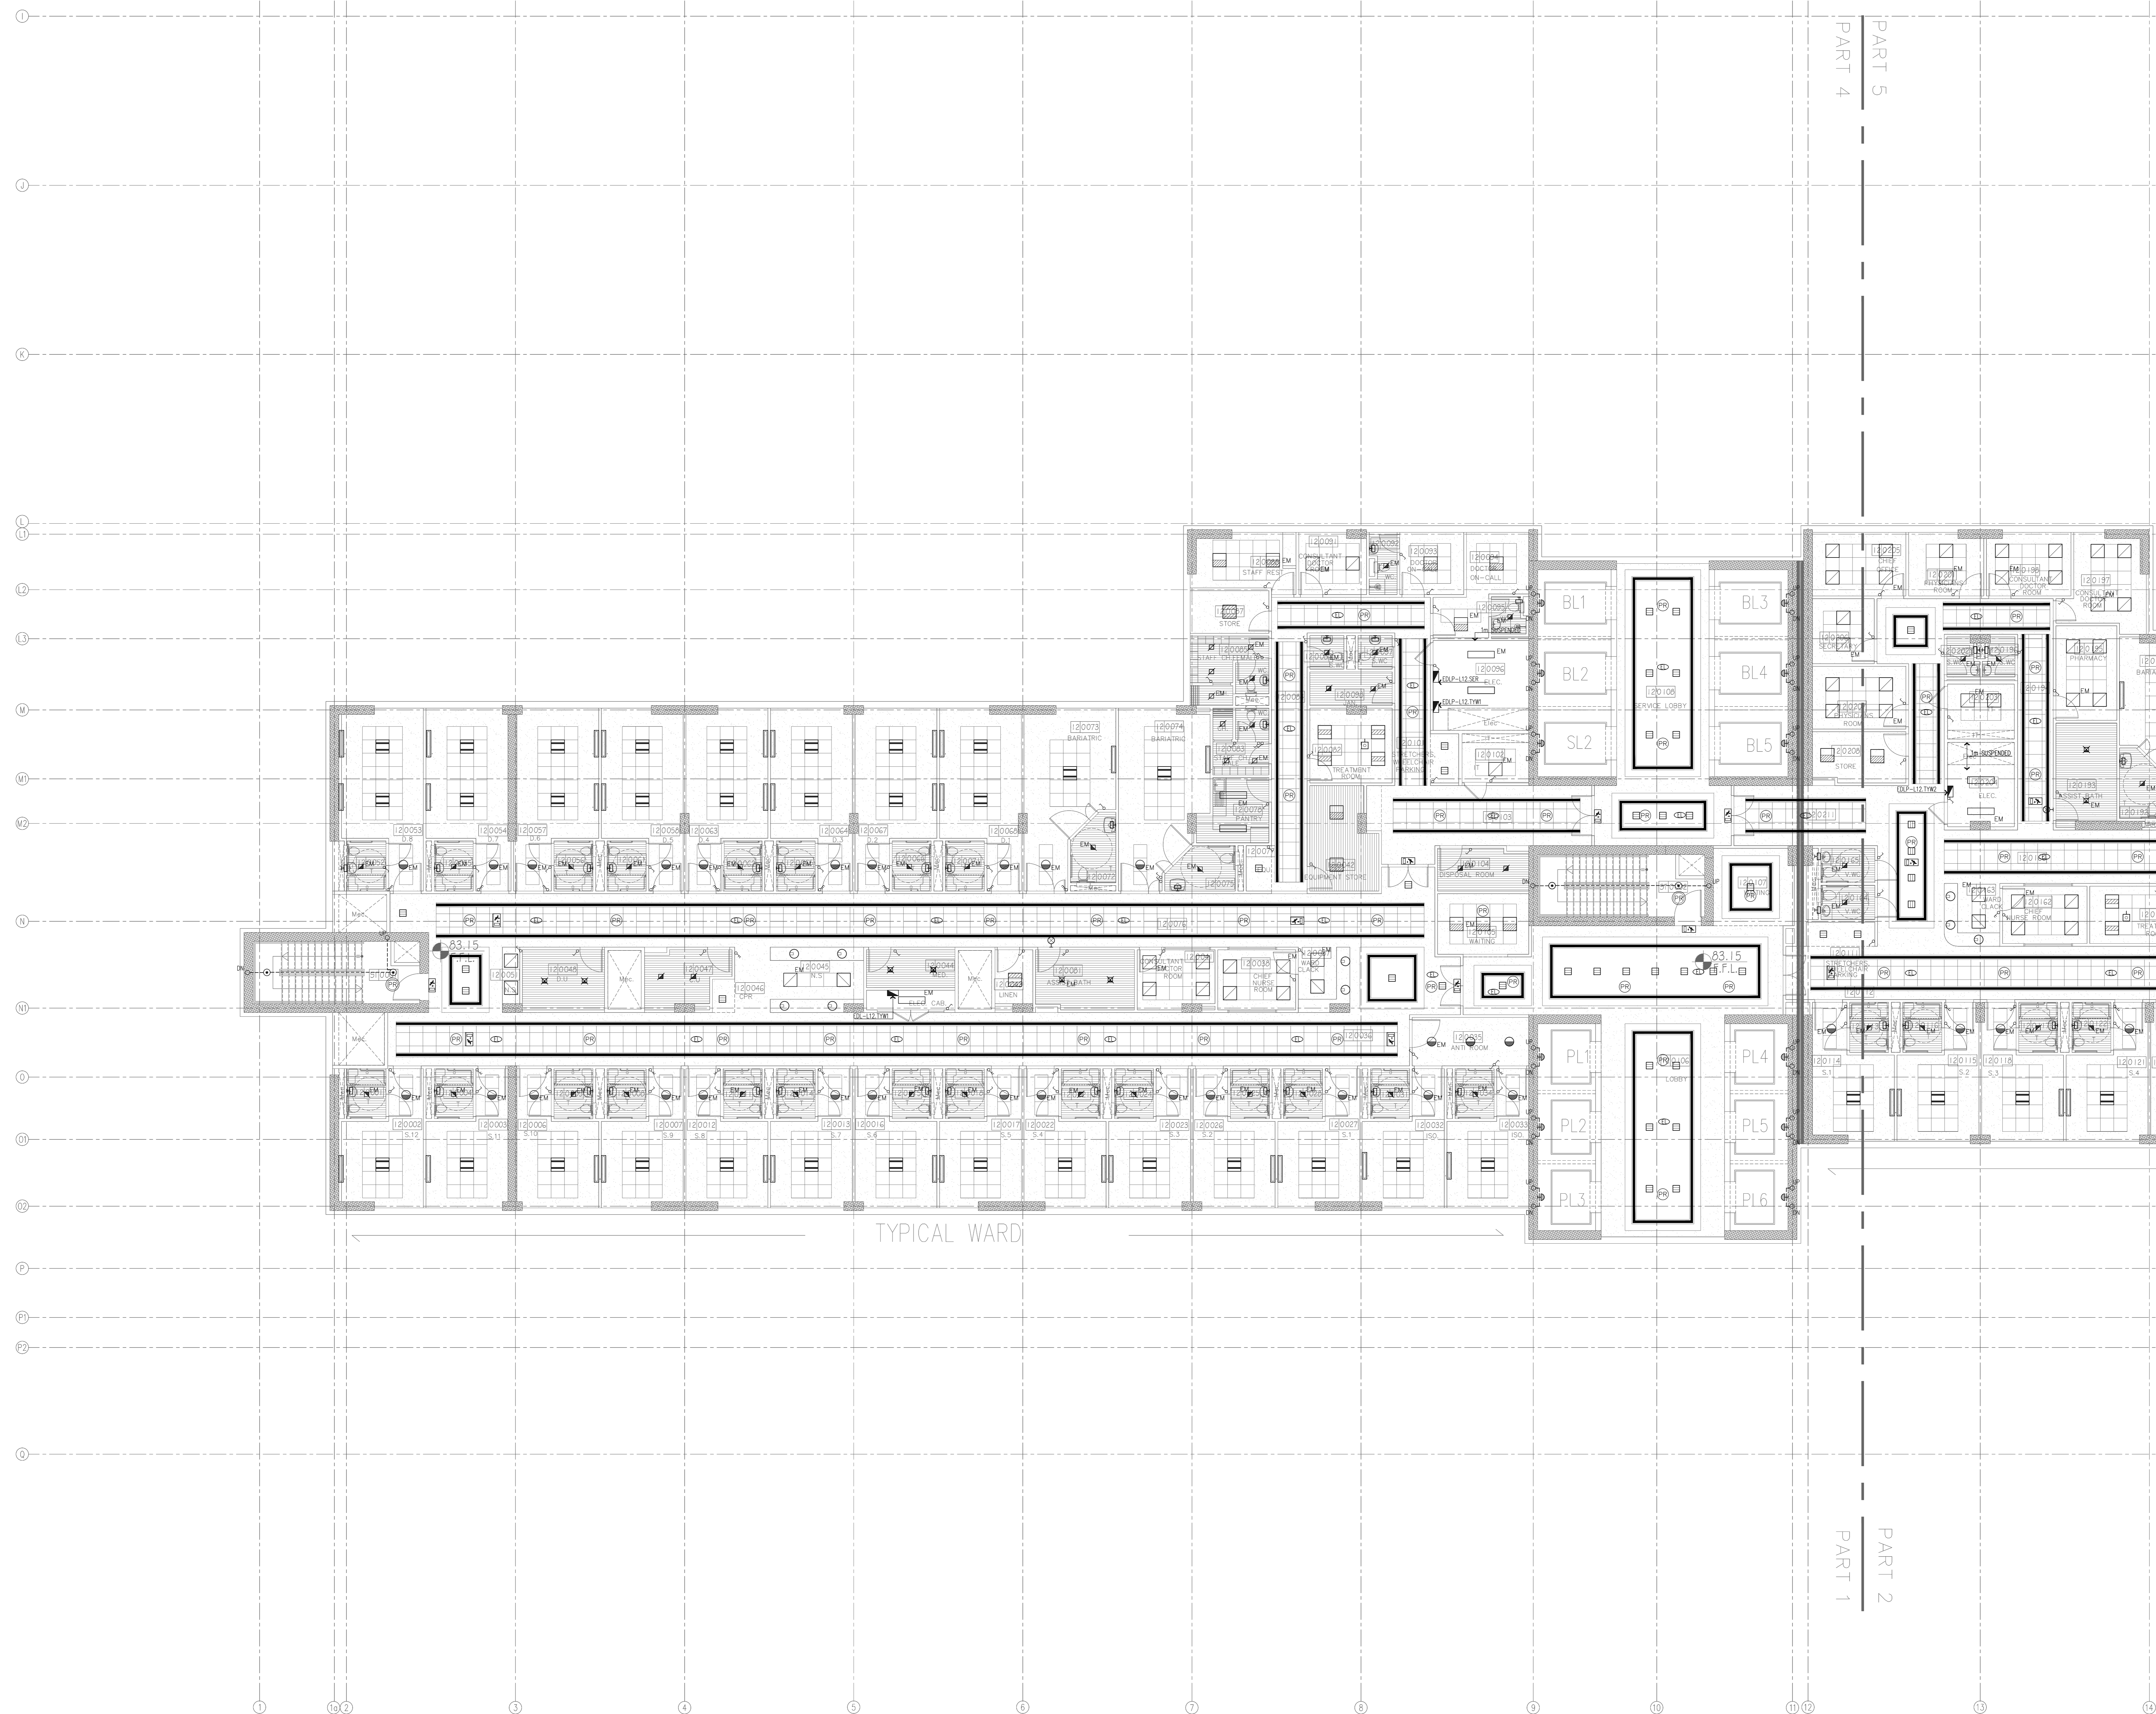

General Notes :

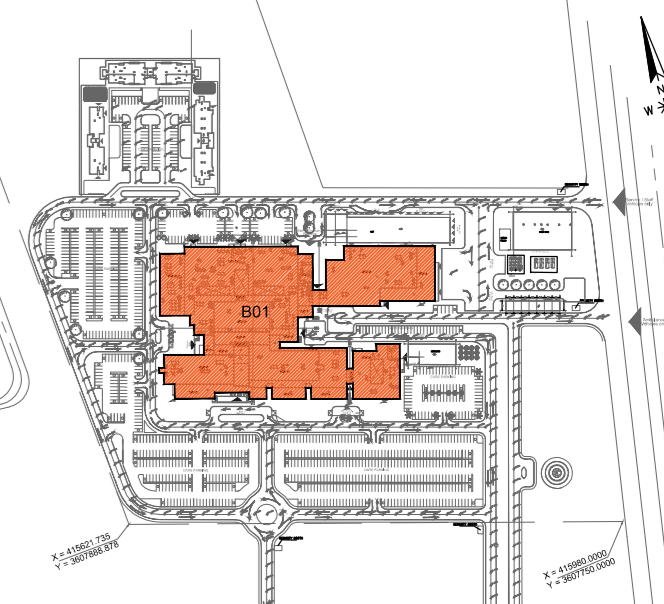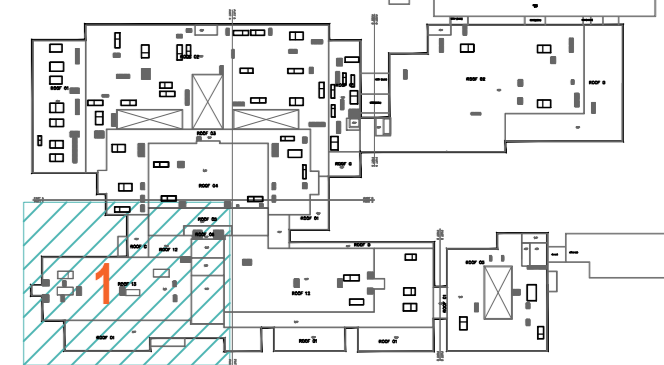

MINISTRY OF HIGHER EDUCATION
AND SCIENTIFIC RESEARCH
University OF Karbala



PROJECT MANAGEMENT CONSULTANT



MAIN Contractor



PRINCIPAL ENGINEERING CONSULTANT

ARABTECH JARDANEH

HDP | healthcare designers
and project managers

CONSULTING INTERNATIONAL ARCHITECTS :
LEO A DALY PLANNING ARCHITECTURE ENGINEERING INTERIOR

THIS DRAWING IS THE
COPYRIGHT OF ARABTEC
JARDANEH ENGINEERS
ARCHITECTS AND MUST NOT
BE RETAINED, COPIED OR USED
WITHOUT THE CONSULTANT'S
AUTHORIZATION

[illegible]

DRAWN BY:	E.D	DESIGNED BY:	H.O/M.S.
CHECKED BY:	M.KH	APPROVED BY:	F.J
QC REVIEW BY:	B.M	DWG ISSUE DATE: 26.10.2	


PROJECT:
KARBALA 600 BED TEACHING
UNIVERSITY HOSPITAL, IRAQ

CONCEPT DESIGN STAGE	PRELIMINARY DESIGN STAGE
DESIGN DEVELOPMENT STAGE	CONSTRUCTION DRAWINGS STAGE

TWELFTH FLOOR PLAN
LIGHTING LAYOUT
PART 1

JOB #	01586	DWG KUH-EL-160	BLOCK #	BO
1:100	⊗ (AO)	Shd. 01 of 02	REV. #	RC

A floor plan of a building with various rooms labeled. A specific area, likely a staircase or a small room, is highlighted with blue diagonal hatching and a large red number '2' in the center. This area is located in the lower-middle part of the plan, between a larger room on the left and a smaller room on the right.

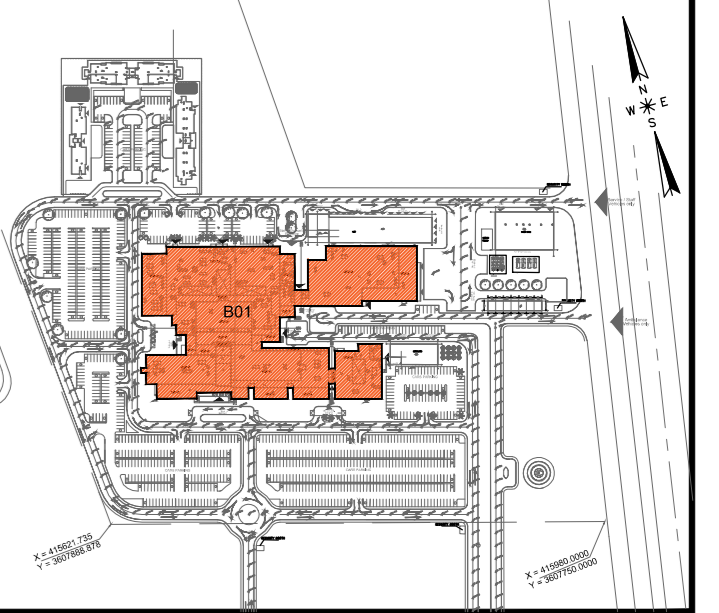

MAIN Contractor :  

HDP | healthcare designers
and project managers

CONSULTING INTERNATIONAL ARCHITECTS :
LEO A DALY PLANNING ARCHITECTURE ENGINEERING INTERIORS

THIS DRAWING IS THE
COPYRIGHT OF ARABTECH
JARDANEH ENGINEERS &
ARCHITECTS AND MUST NOT BE
RETAINED, COPIED OR USED
WITHOUT THE CONSULTANTS'
AUTHORIZATION

[illegible]

DRAWN BY:	E.D	DESIGNED BY:	H.O/M.SH
CHECKED BY:	M.KH	APPROVED BY:	F.J
QC REVIEW BY:	B.M	DWG ISSUE DATE: 26.10.2014	


PROJECT:
KARBALA 600 BED TEACHING
UNIVERSITY HOSPITAL, IRAQ

CONCEPT DESIGN STAGE	PRELIMINARY DESIGN STAGE
DESIGN DEVELOPMENT STAGE	CONSTRUCTION DRAWINGS STAGE



DRAWING TITLE:

TWELFTH FLOOR PLAN
LIGHTING LAYOUT
PART 2

01586	DWG KUH- EL-161	BLOCK * B01
1:100 @ (A0)	Sh. 02 of 02	REV. * R0

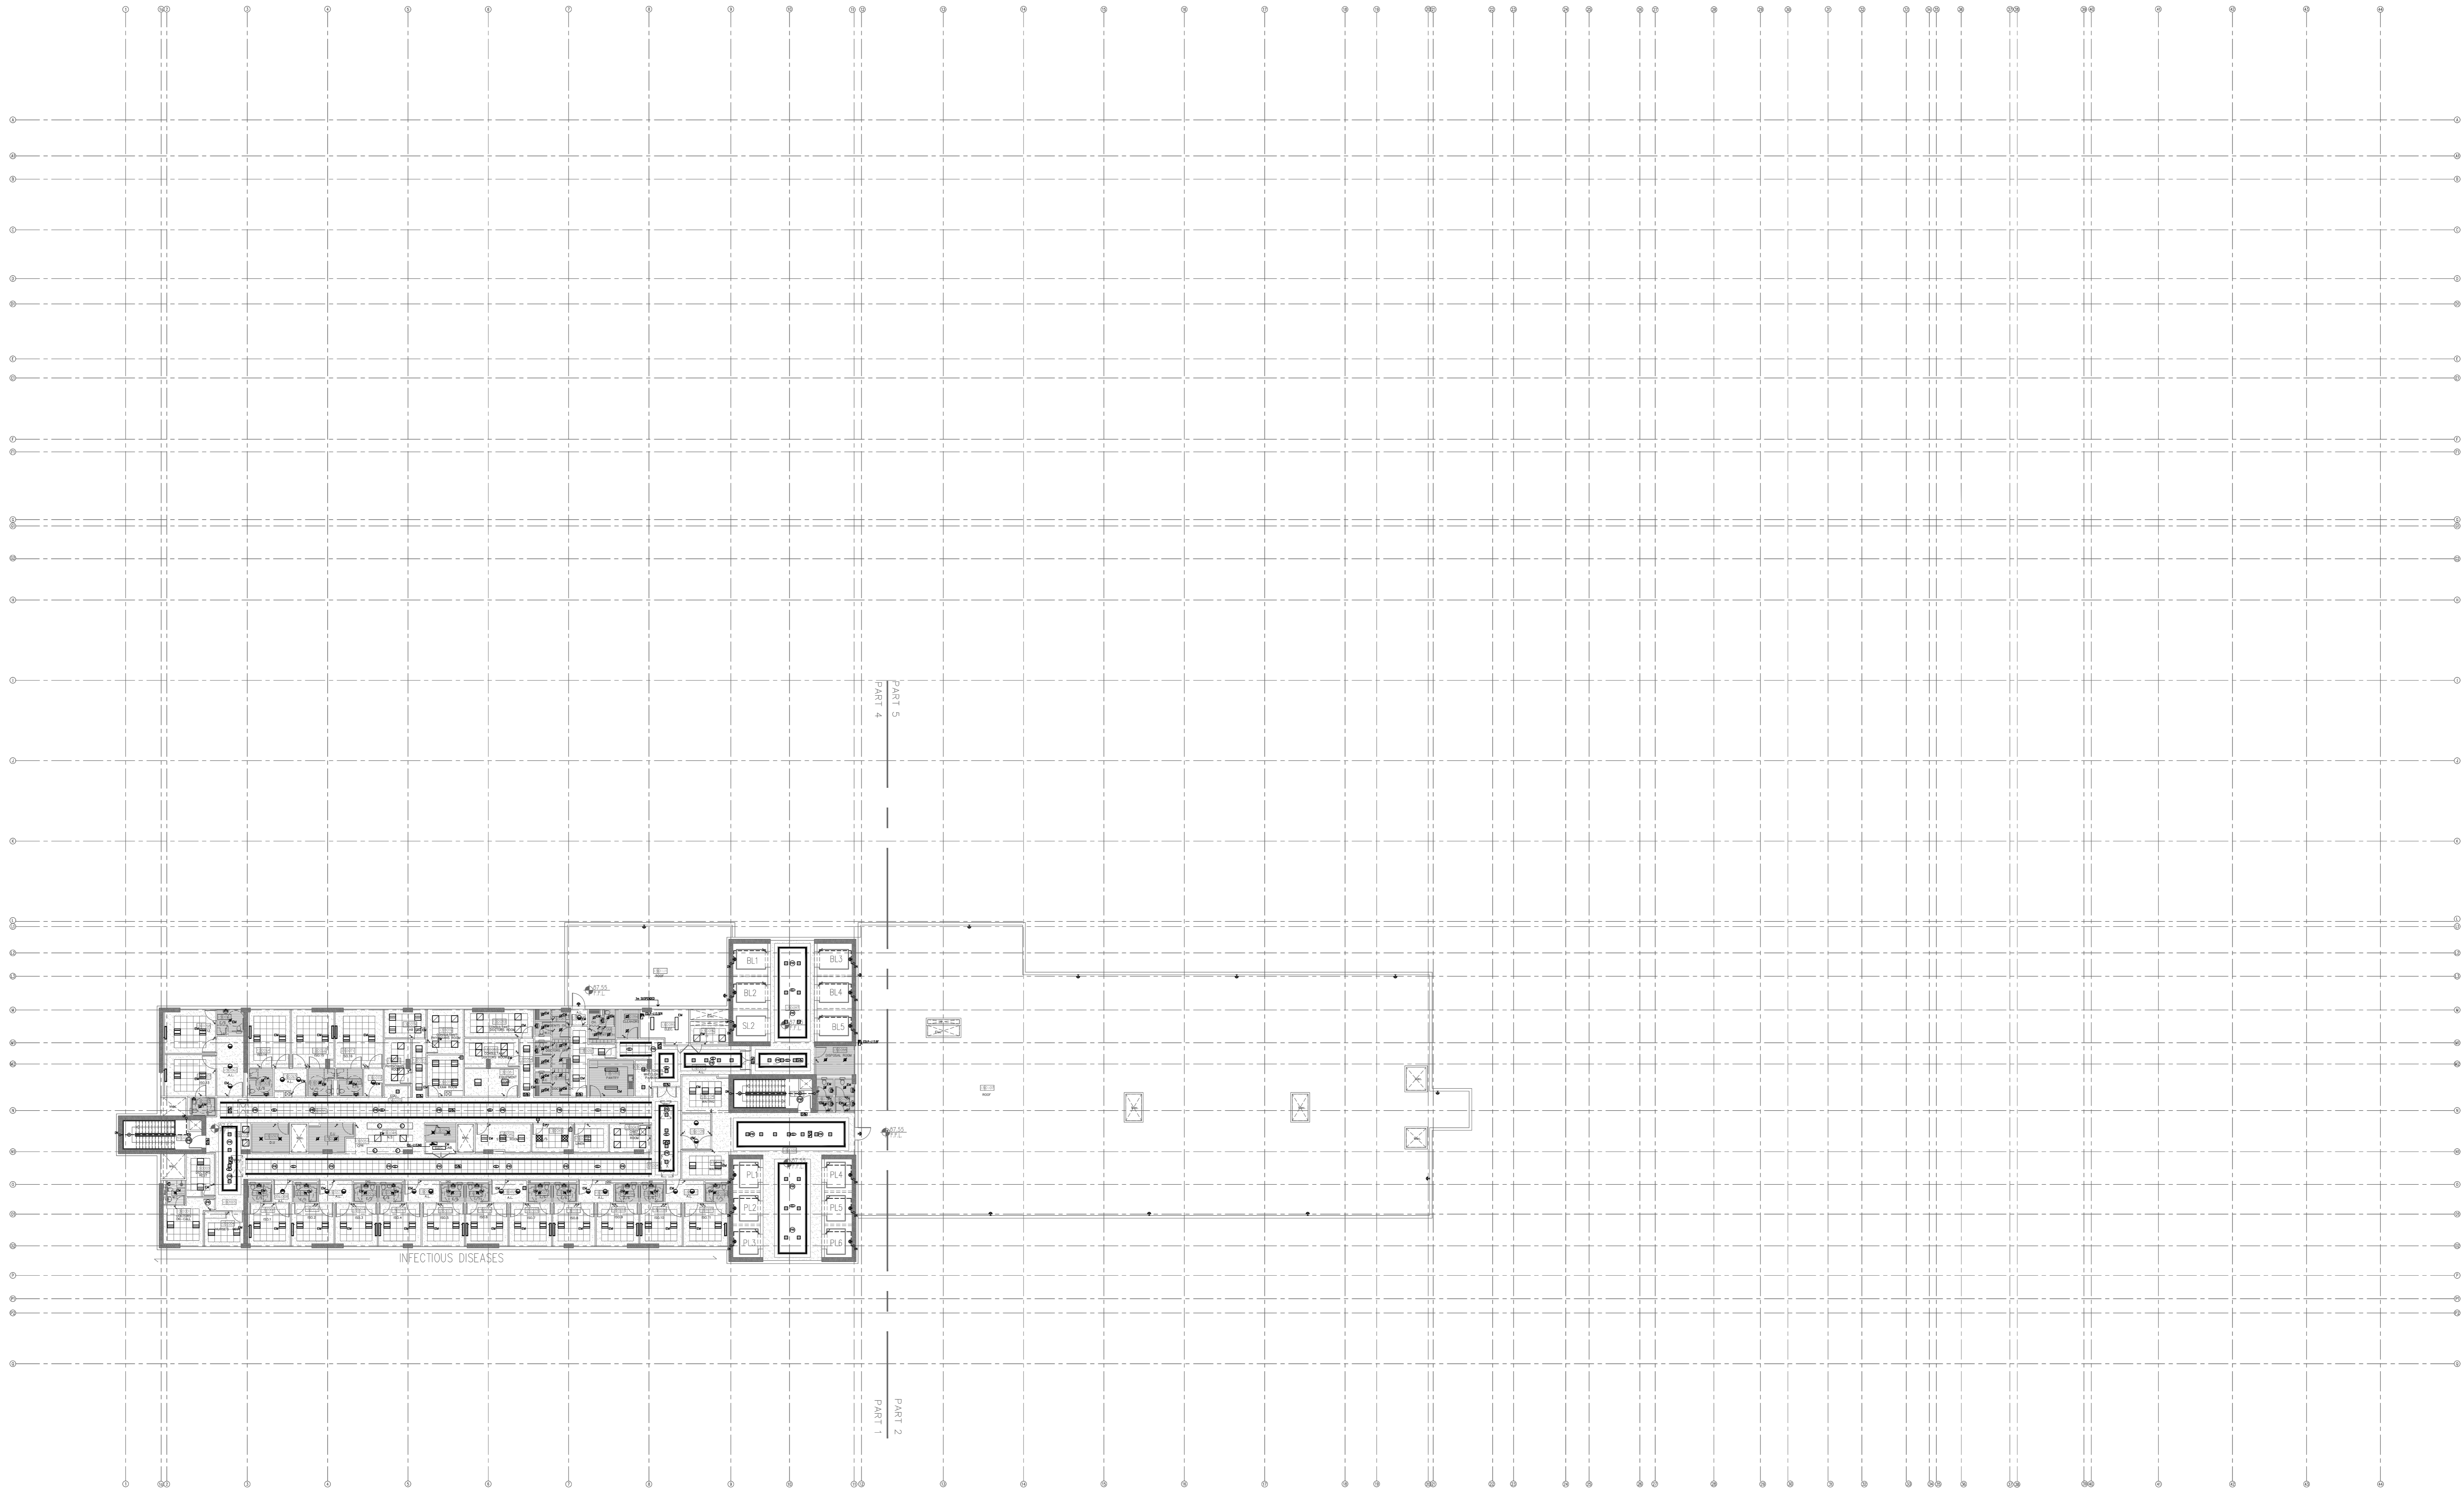

General Notes :

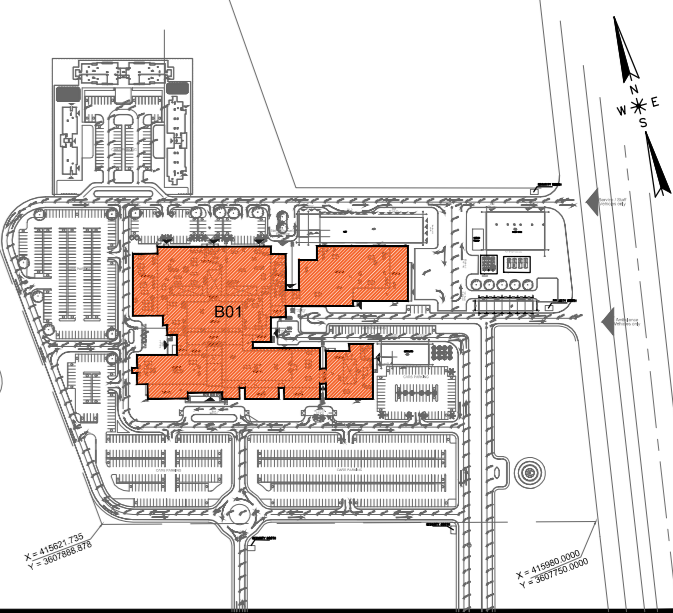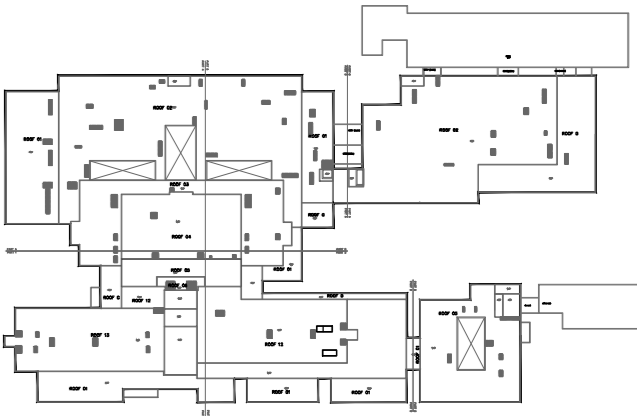

OWNER:
MINISTRY OF HIGHER EDUCATION
AND SCIENTIFIC RESEARCH
University Of Karbala



PROJECT MANAGEMENT CONSULTANT:
AM TECH

MAIN Contractor :
FOURTH DIMENSION
Consulting Engineering & Construction
CIS C

PRINCIPAL ENGINEERING CONSULTANT:
ARABTECH JARDANEH

CONSULTING HEALTH PLANNERS:
HDP healthcare designers
and project managers

CONSULTING INTERNATIONAL ARCHITECTS:
LEO A DALY
PLANNING ARCHITECTURE ENGINEERING INTERIORS

THIS DRAWING IS THE
COPYRIGHT OF ARABTECH
JARDANEH ENGINEERS &
ARCHITECTS AND MUST NOT BE
REPRODUCED, COPIED OR USED
WITHOUT THE CONSULTANTS'
AUTHORIZATION

REV.	DESCRIPTION	APPRO. BY	DATE

DRAWN BY: E.D	DESIGNED BY: H.O/M/SH
CHECKED BY: M.KH	APPROVED BY: F.J
QC REVIEW BY: B.M	DWG ISSUE DATE: 26.10.2014

PROJECT: KARBALA 600 BED TEACHING UNIVERSITY HOSPITAL, IRAQ	
CONCEPT DESIGN STAGE	PRELIMINARY DESIGN STAGE
DESIGN DEVELOPMENT STAGE	CONSTRUCTION DRAWINGS STAGE

DRAWING TITLE:

THIRTEENTH FLOOR PLAN
LIGHTING LAYOUT
OVERALL

A01	01586	DWG	KUH-EL-162	BLOCK	B01
1:250	01	01	01	REV.	RO



PROJECT MANAGEMENT CONSULTANT :

 **AM
TECH**

MAIN Contractor :



FOURTH DIMENSION
Contracting Engineering procurement



C.B.C

PRINCIPAL ENGINEERING CONSULTANT :
ARABTECH JARDANEH

HDP | healthcare designers
and project managers

CONSULTING INTERNATIONAL ARCHITECTS :
LEO A DALY PLANNING ARCHITECTURE ENGINEERING INTERIORS

THIS DRAWING IS THE
COPYRIGHT OF ARABTECH
JARDANEH ENGINEERS &
ARCHITECTS AND MUST NOT BE
RETAINED, COPIED OR USED
WITHOUT THE CONSULTANTS'
AUTHORIZATION

[illegible]


DRAWN BY:	E.D	DESIGNED BY:	H.O/M.SH
CHECKED BY:	M.KH	APPROVED BY:	F.J
QC REVIEW BY:	B.M	DWG ISSUE DATE: 26.10.2014	

PROJECT:
KARBALA 600 BED TEACHING
UNIVERSITY HOSPITAL, IRAQ



DESIGN DEVELOPMENT STAGE	CONSTRUCTION DRAWINGS STAGE
DRAWING TITLE:	

THIRTEENTH FLOOR PLAN
LIGHTING LAYOUT
PART 1

01586	DWG KUH-EL-163	BLOCK * B01
1:100 @ (A0)	Sheet 01 of 02	REV. * R0

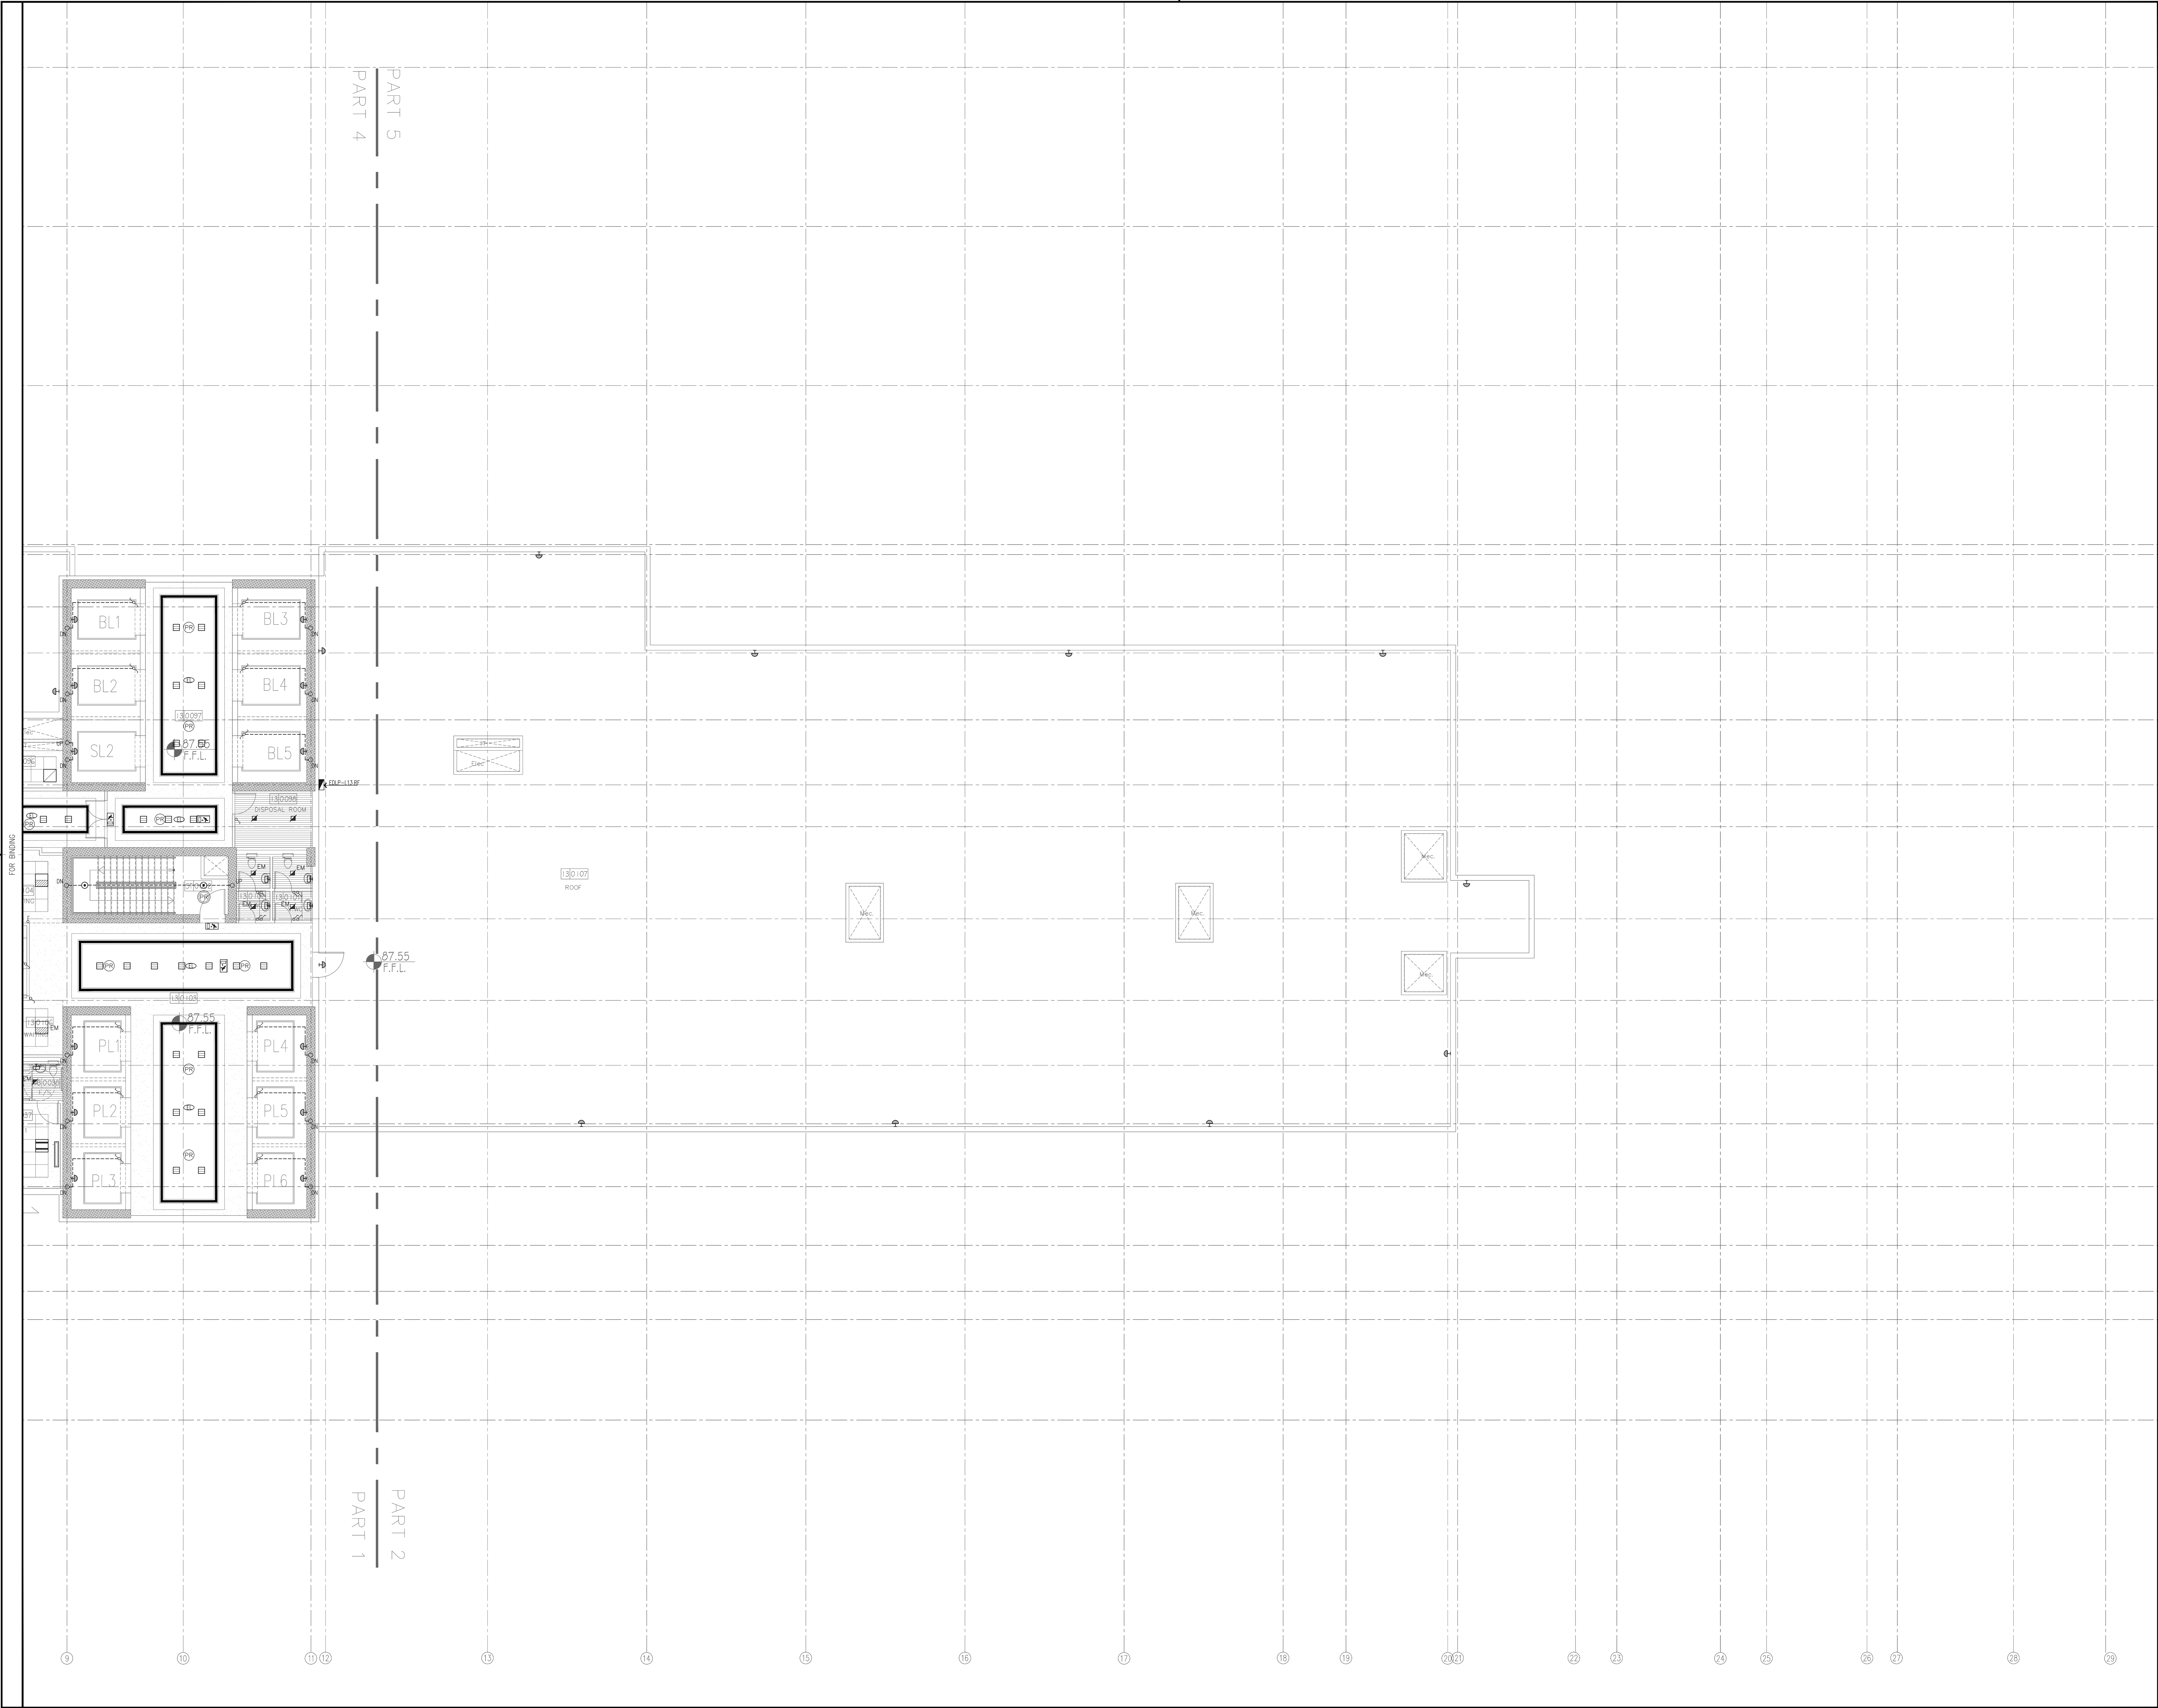

General Notes :

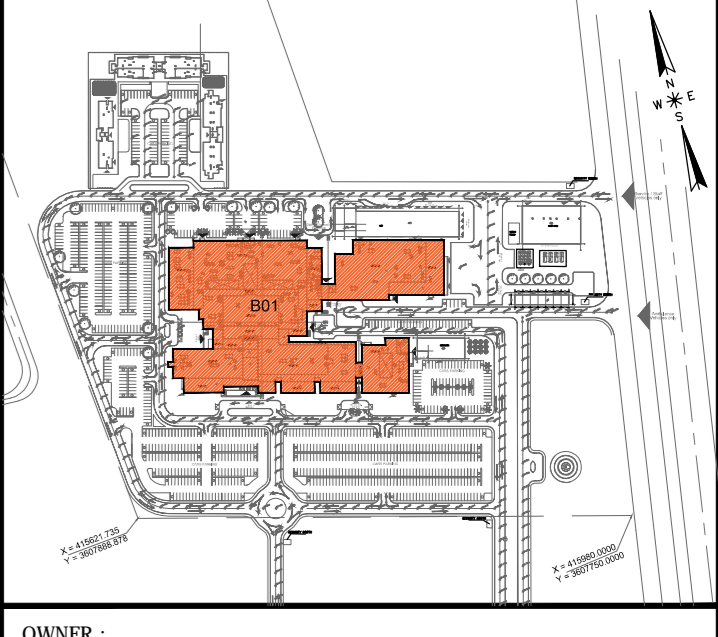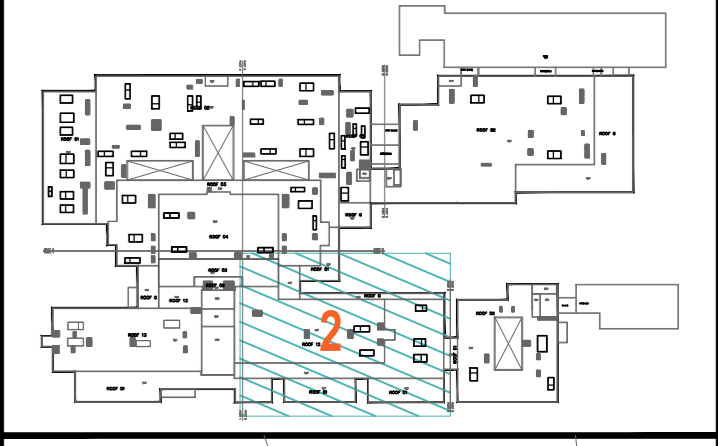

OWNER:
MINISTRY OF HIGHER EDUCATION
AND SCIENTIFIC RESEARCH
University Of Karbala



PROJECT MANAGEMENT CONSULTANT:
AM TECH

MAIN Contractor :
FOURTH DIMENSION
Consulting Engineering & Construction

PRINCIPAL ENGINEERING CONSULTANT:
ARABTECH JARDANEH

CONSULTING HEALTH PLANNERS:
HDP healthcare designers
and project managers

CONSULTING INTERNATIONAL ARCHITECTS:
LEO A DALY PLANNING ARCHITECTURE ENGINEERING INTERIORS

THIS DRAWING IS THE
COPYRIGHT OF ARABTECH
JARDANEH ENGINEERS &
ARCHITECTS AND MUST NOT BE
REPRODUCED, COPIED OR USED
WITHOUT THE CONSULTANTS'
AUTHORIZATION

REV.	DESCRIPTION	APPRO. BY	DATE


DRAWN BY: E.D. DESIGNED BY: H.O./K.A.
CHECKED BY: M.K.H. APPROVED BY: F.J.
QC REVIEW BY: B.M. DWG ISSUE DATE: 26.10.2014

PROJECT:
**KARBALA 600 BED TEACHING
UNIVERSITY HOSPITAL, IRAQ**

CONCEPT DESIGN STAGE	PRELIMINARY DESIGN STAGE
DESIGN DEVELOPMENT STAGE	CONSTRUCTION DRAWINGS STAGE

DRAWING TITLE:
**THIRTEENTH FLOOR PLAN
LIGHTING LAYOUT
PART 2**

A01 01586 DWG: KUH-EL-164 BLOCK: B01
1:100 Sht. 02 of 02 REV: RO

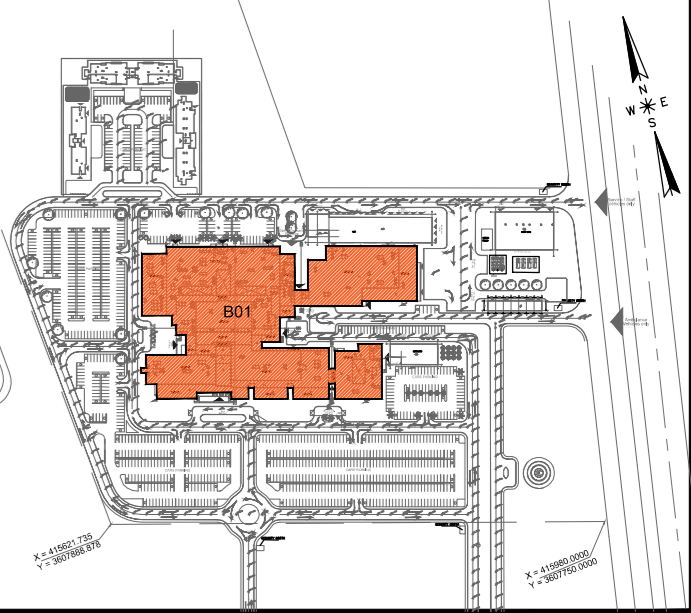

PROJECT MANAGEMENT CONSULTANT :

 **AM
TECH**

MAIN Contractor :



FOURTH DIMENSION
Contracting Engineering procurement



CIBC

PRINCIPAL ENGINEERING CONSULTANT :
ARABTECH JARDANEH

CONSULTING HEALTH PLANNERS :

HDP | healthcare designers
and project managers

CONSULTING INTERNATIONAL ARCHITECTS :
LEO A DALY PLANNING ARCHITECTURE ENGINEERING INTERIORS

THIS DRAWING IS THE
COPYRIGHT OF ARABTECH
JARDANEH ENGINEERS &
ARCHITECTS AND MUST NOT BE
RETAINED, COPIED OR USED
WITHOUT THE CONSULTANTS'
AUTHORIZATION

[illegible]

DRAWN BY:	E.D	DESIGNED BY:	H.O/M.SH
CHECKED BY:	M.KH	APPROVED BY:	F.J
QC REVIEW BY:	B.M	DWG ISSUE DATE: 26.10.2014	

PROJECT:
KARBALA 600 BED TEACHING
UNIVERSITY HOSPITAL, IRAQ

CONCEPT DESIGN STAGE	PRELIMINARY DESIGN STAGE
DESIGN DEVELOPMENT STAGE	CONSTRUCTION DRAWINGS STAGE

DRAWING TITLE:

ROOF FLOOR PLAN
LIGHTING LAYOUT
OVERALL

01586	DWG KUH-EL-165	BLOCK * B01
1:250 @ (A0)	Sheet 01 of 01	REV. * R0

